


NOTE:
REFER TO UTILITY PLANS SHEET C200 THROUGH C203 FOR LOCATION OF ALL PROPOSED UNDERGROUND UTILITIES AND ASSOCIATED STRUCTURES.

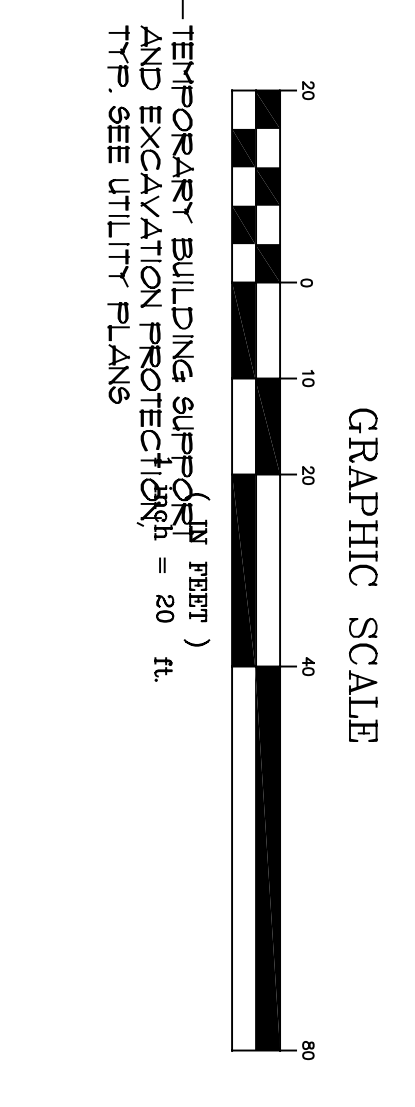

MAINE MEDICAL CENTER
Pkg C - Site Utilities
Portland, Maine
MMC Project No. 21846


TRO
ARCHITECTURE
ENGINEERING
INTERIOR DESIGN
The Riebler Organization
60 Bridge Street
Portland, ME 04101
617-486-9400

DATE: 08/17/24
SCALE: 1"=20'
SHEET NUMBER: PK-C
DRAWN BY: [Name]
CHECKED BY: [Name]
APPROVED BY: [Name]

CONSTRUCTION NO. 4677
DATE ISSUED: 08/17/24
SCALE: 1"=20'
SHEET NUMBER: PK-C
DRAWN BY: [Name]
CHECKED BY: [Name]
APPROVED BY: [Name]

PROJECT: MAINE MEDICAL CENTER
SHEET: C201

NO.	DATE	DESCRIPTION
1	08/17/24	PERMIT SET
2	08/27/24	BD SET
3	08/27/24	ISSUE LOG

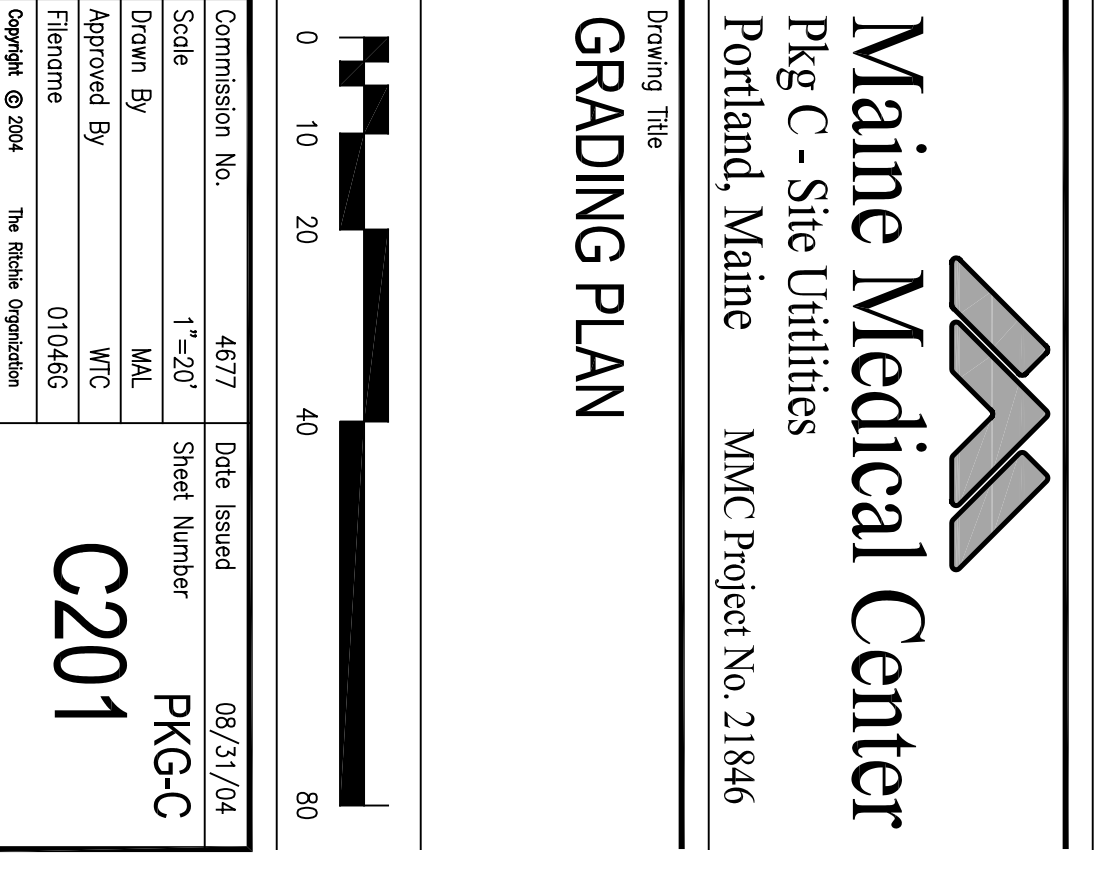

General Notes: