


NOTE:
SEE UTILITY PLAN SHEETS C200 THROUGH C207 FOR LOCATION OF ALL PROPOSED UNDERGROUND UTILITIES AND ASSOCIATED STRUCTURES.

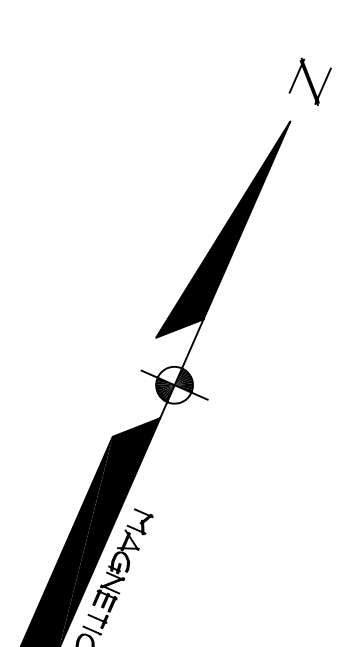


MATCHLINE - SEE SHEET C201

EXISTING PARKING GARAGE

MATCHLINE - SEE BELOW

MATCHLINE - SEE SHEET C200

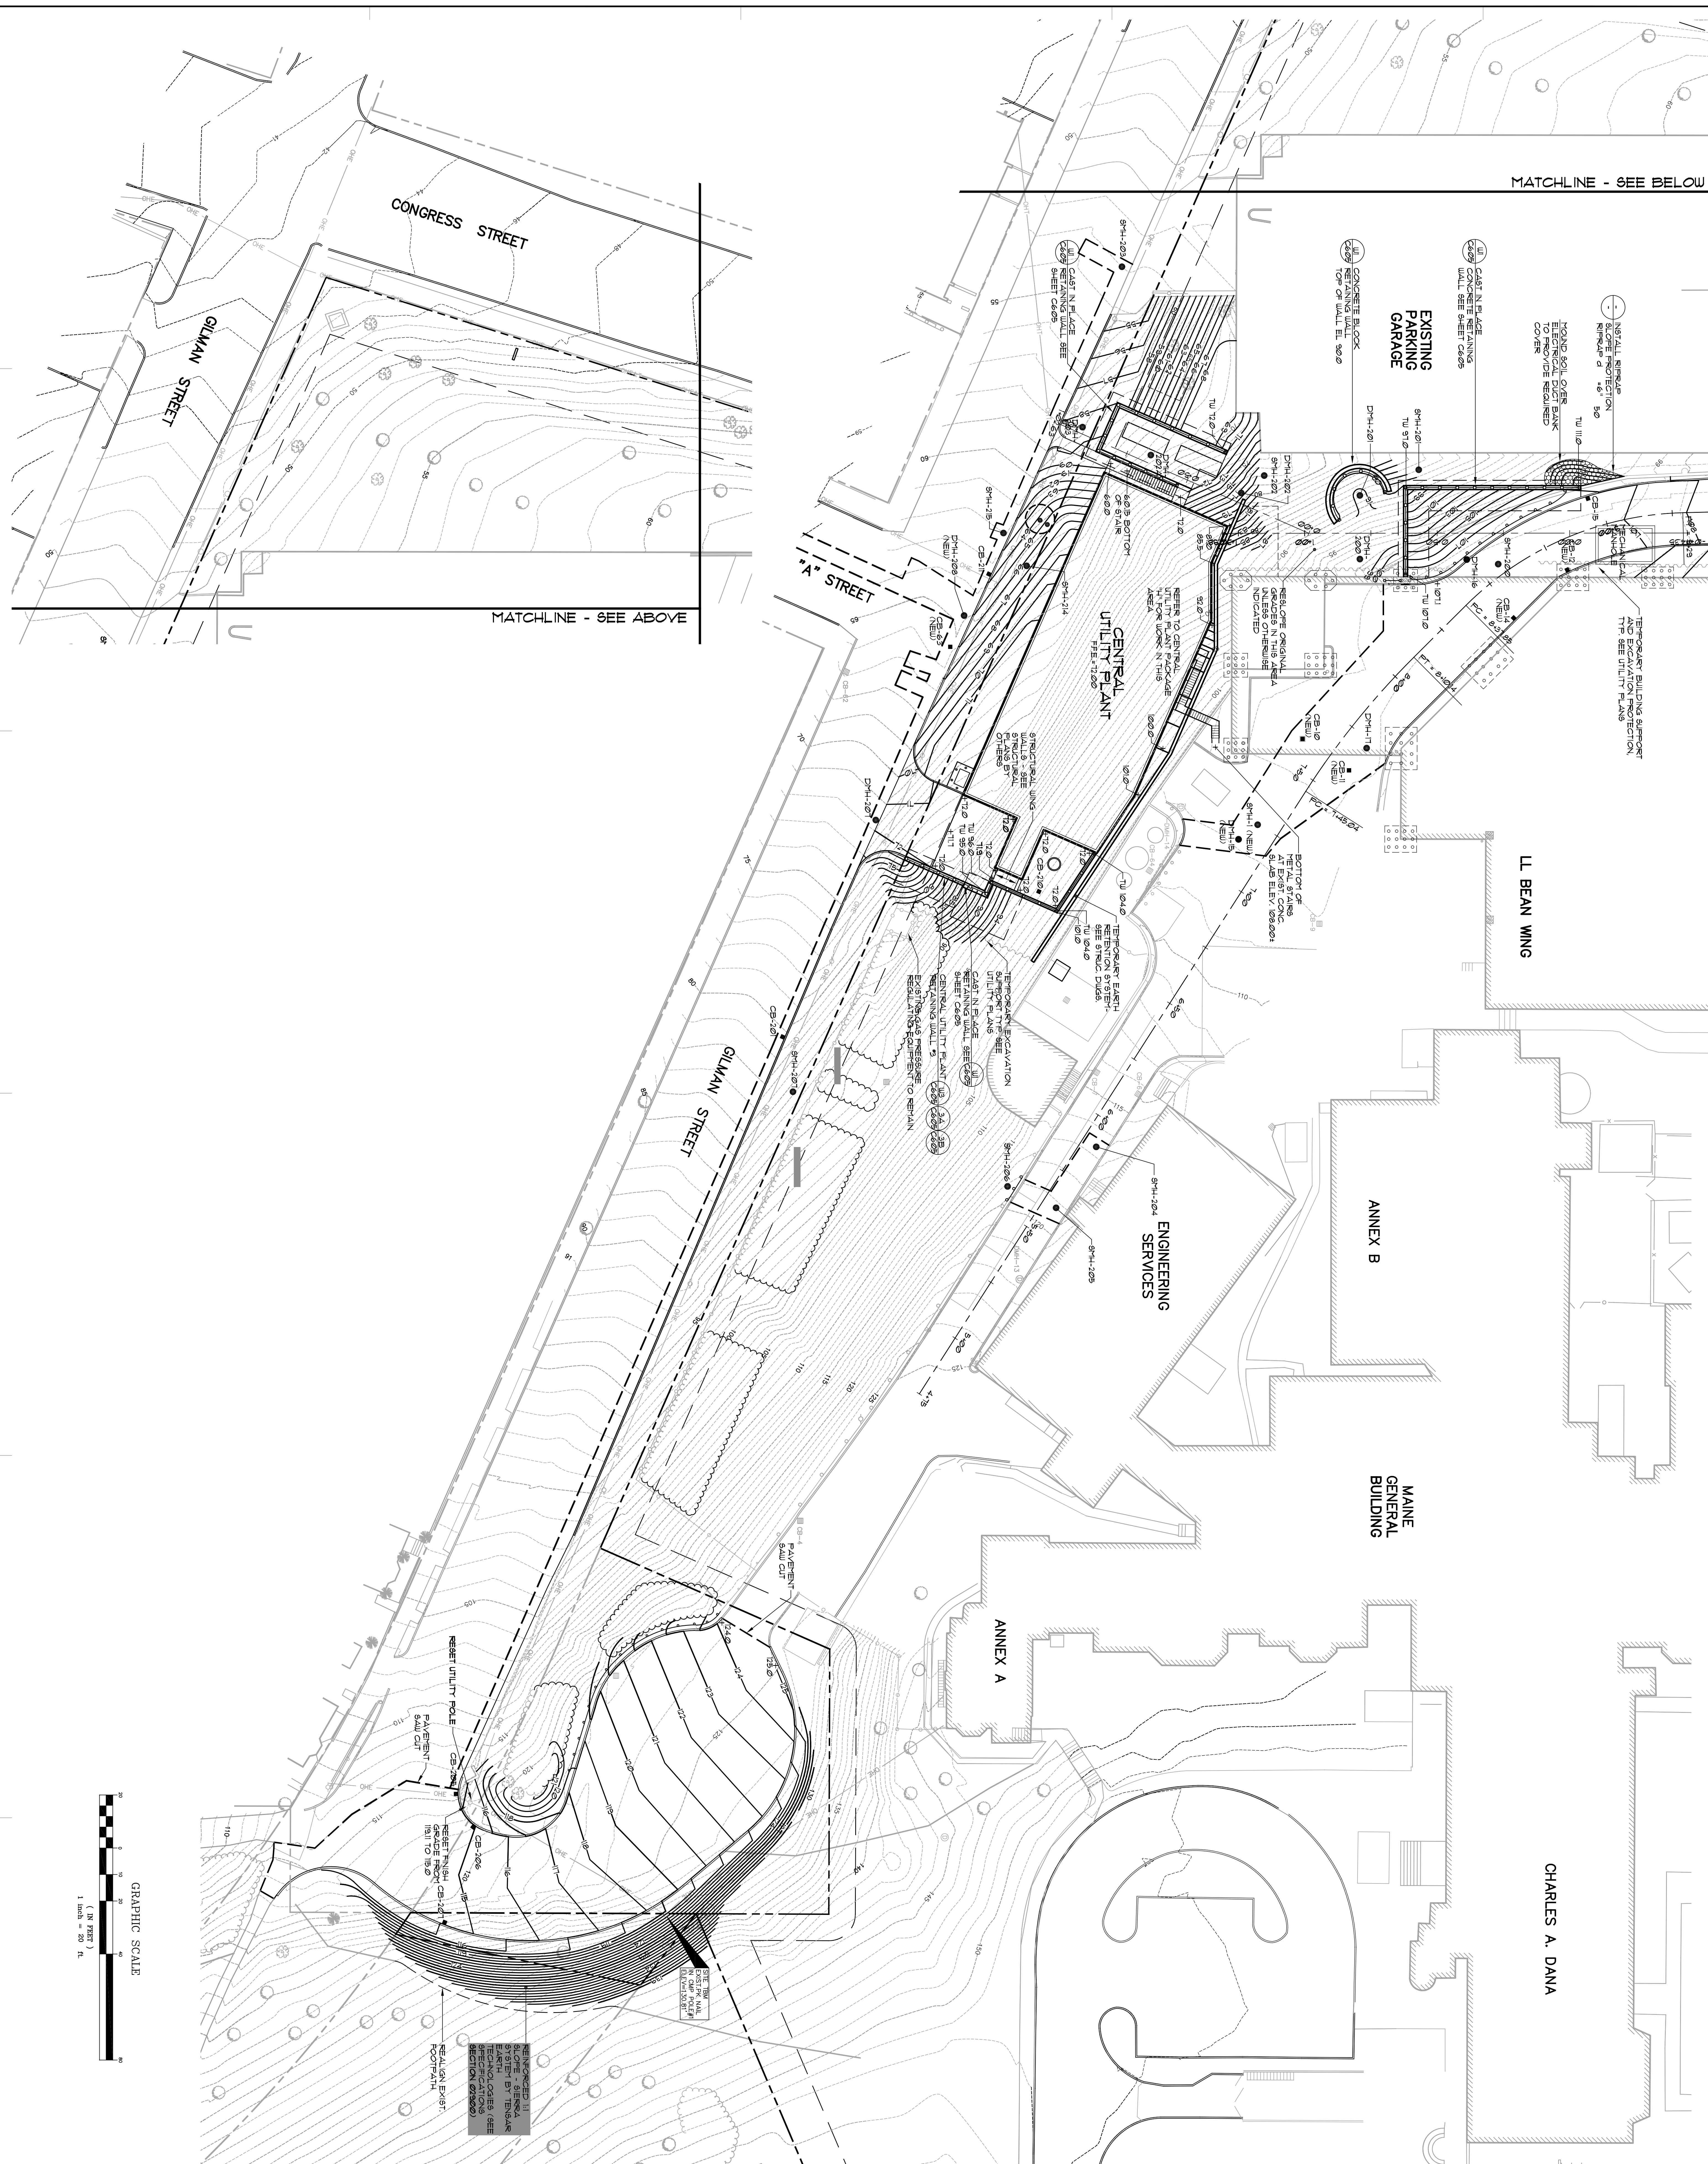

CHARLES A. DANA

LL BEAN WING

MAINE GENERAL BUILDING

ANNEX B

ENGINEERING SERVICES

ANNEX A

CENTRAL UTILITY PLANT


A STREET

CONGRESS STREET


GILMAN STREET

MATCHLINE - SEE ABOVE

GRAPHIC SCALE

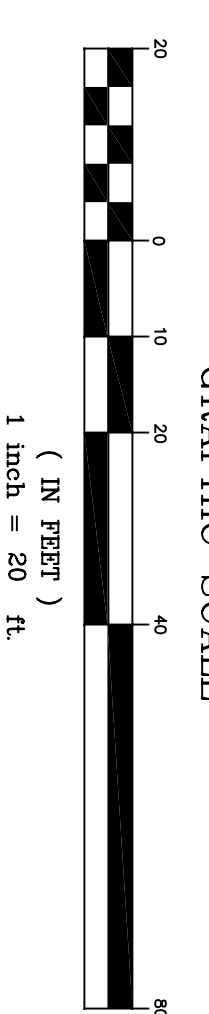

| WORK | ISSUE DATE | DESCRIPTION |
|-----------|------------|-------------|
| PERMIT | 09/19/24 | PERMIT SET |
| ISSUE LOG | 09/27/24 | 80 SET |

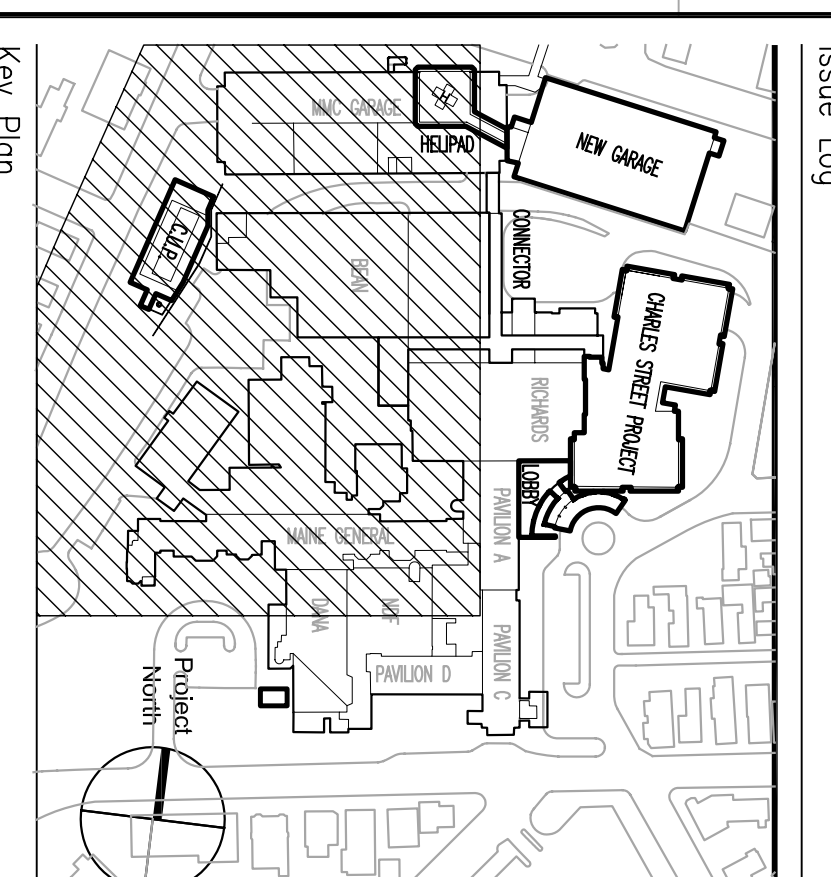

TRO
ARCHITECTURE
ENGINEERING
INTERIOR DESIGN

The Rubell Organization
60 Bridge Street
Newport, 01785-0940

Maine Medical Center
Pkg C - Site Utilities
Portland, Maine
MMC Project No. 21846

Preparing This
GRADING PLAN

0 10 20 40 80

0 10 20 40 80

08/27/24
PKG-C
C202

4677 Date Issued
1"-20" Sheet Number
MM
11/20/24
The Rubell Organization