


MATCHLINE - SEE SHEET 304

MATCHLINE - SEE SHEET 304

**General Notes:**

1. ALL UTILITIES SHOWN ARE BASED ON FIELD SURVEY DATA AND EXISTING RECORD DRAWINGS. THE CONTRACTOR SHALL VERIFY THE LOCATION AND DEPTH OF ALL UTILITIES PRIOR TO CONSTRUCTION. SEE ELECTRICAL, CIVIL AND MECHANICAL DRAWINGS FOR DETAILS OF ALL UTILITIES.
2. ELECTRICAL AND MECHANICAL UTILITIES SHALL BE INSTALLED IN ACCORDANCE WITH THE NATIONAL ELECTRICAL CODE (NEC) AND THE NATIONAL MECHANICAL CODE (NMC). THE CONTRACTOR SHALL BE RESPONSIBLE FOR OBTAINING ALL NECESSARY PERMITS AND APPROVALS FROM THE LOCAL AUTHORITIES.
3. THE CONTRACTOR SHALL BE RESPONSIBLE FOR PROTECTING ALL EXISTING UTILITIES AND STRUCTURES. ANY DAMAGE TO EXISTING UTILITIES OR STRUCTURES SHALL BE REPAIRED AT THE CONTRACTOR'S EXPENSE.
4. SEE SHEET 10.
5. THE CONTRACTOR SHALL BE RESPONSIBLE FOR OBTAINING ALL NECESSARY PERMITS AND APPROVALS FROM THE LOCAL AUTHORITIES.
6. THE CONTRACTOR SHALL BE RESPONSIBLE FOR OBTAINING ALL NECESSARY PERMITS AND APPROVALS FROM THE LOCAL AUTHORITIES.
7. THE CONTRACTOR SHALL BE RESPONSIBLE FOR OBTAINING ALL NECESSARY PERMITS AND APPROVALS FROM THE LOCAL AUTHORITIES.
8. THE CONTRACTOR SHALL BE RESPONSIBLE FOR OBTAINING ALL NECESSARY PERMITS AND APPROVALS FROM THE LOCAL AUTHORITIES.
9. THE CONTRACTOR SHALL BE RESPONSIBLE FOR OBTAINING ALL NECESSARY PERMITS AND APPROVALS FROM THE LOCAL AUTHORITIES.
10. THE CONTRACTOR SHALL BE RESPONSIBLE FOR OBTAINING ALL NECESSARY PERMITS AND APPROVALS FROM THE LOCAL AUTHORITIES.
11. THE CONTRACTOR SHALL BE RESPONSIBLE FOR OBTAINING ALL NECESSARY PERMITS AND APPROVALS FROM THE LOCAL AUTHORITIES.

NO.	DATE	DESCRIPTION
1	09/18/24	PERMIT SET
2	09/27/24	ISSUE SET

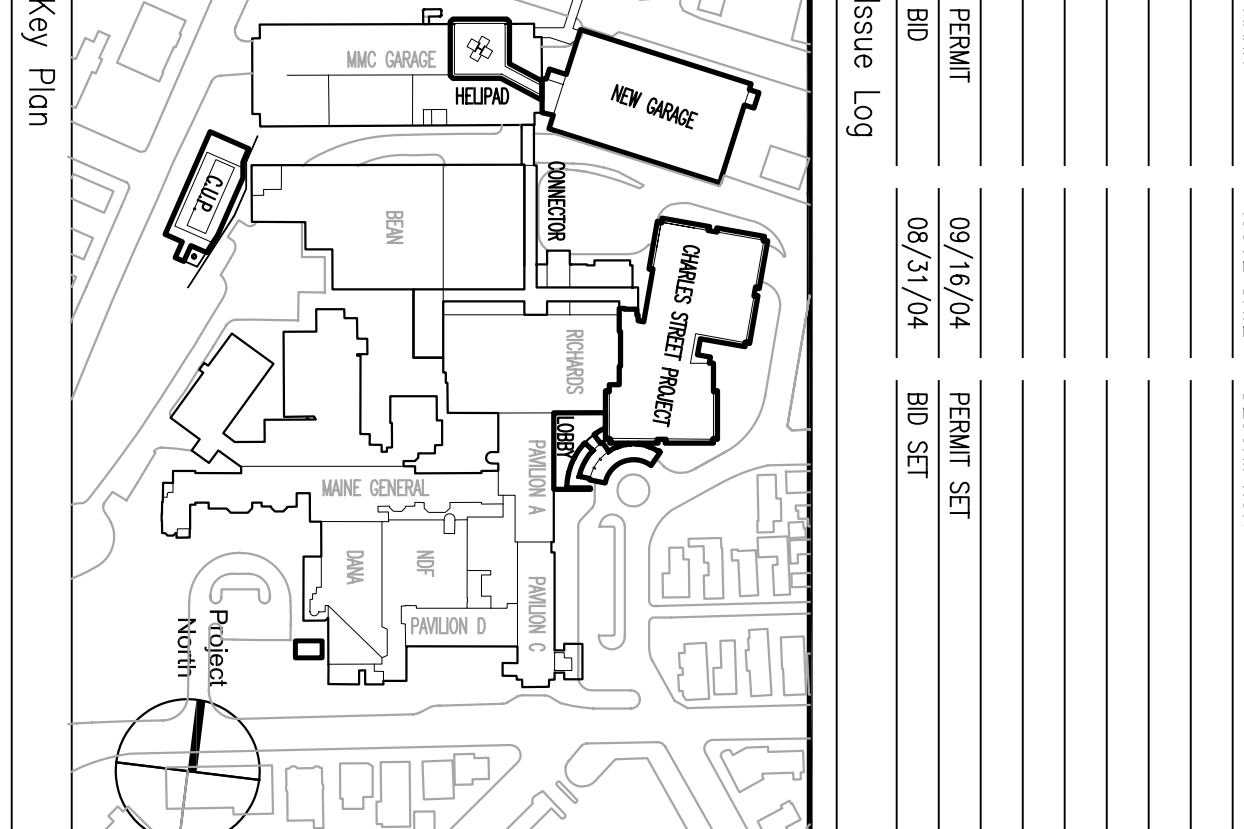

**Maine Medical Center**  
 Pkg C - Site Utilities  
 Portland, Maine  
 MMC Project No. 21846

**UTILITY PLAN**

0 5 10 20 40  
 0 3 6 12 24 48  
 0 3 6 12 24 48  
 0 3 6 12 24 48

09/27/24 PKC-C  
 Scale: 1"=10'  
 Drawn By: MJK  
 Checked By: LJS  
 Approved By: LJS  
 Project No. 21846

**C303**