
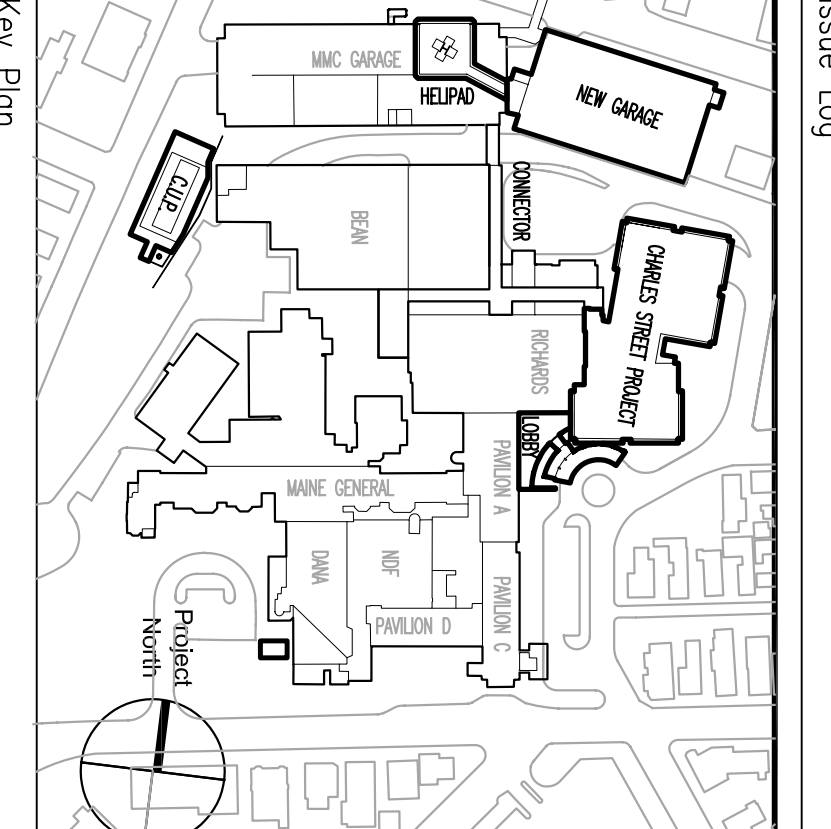
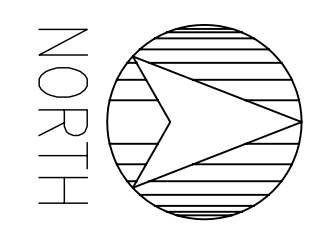


General Notes:
 1. [X]-[XT] INDICATES BOTTOM OF FLOOR ELEVATION.
 2. ALL FOUNDATION EXPOSED RETENTION DRAIN PIPES MUST BE AT LEAST 4.5 FEET OF COVER. SHALL RECEIVE INSULATION TO PREVENT FREEZING.

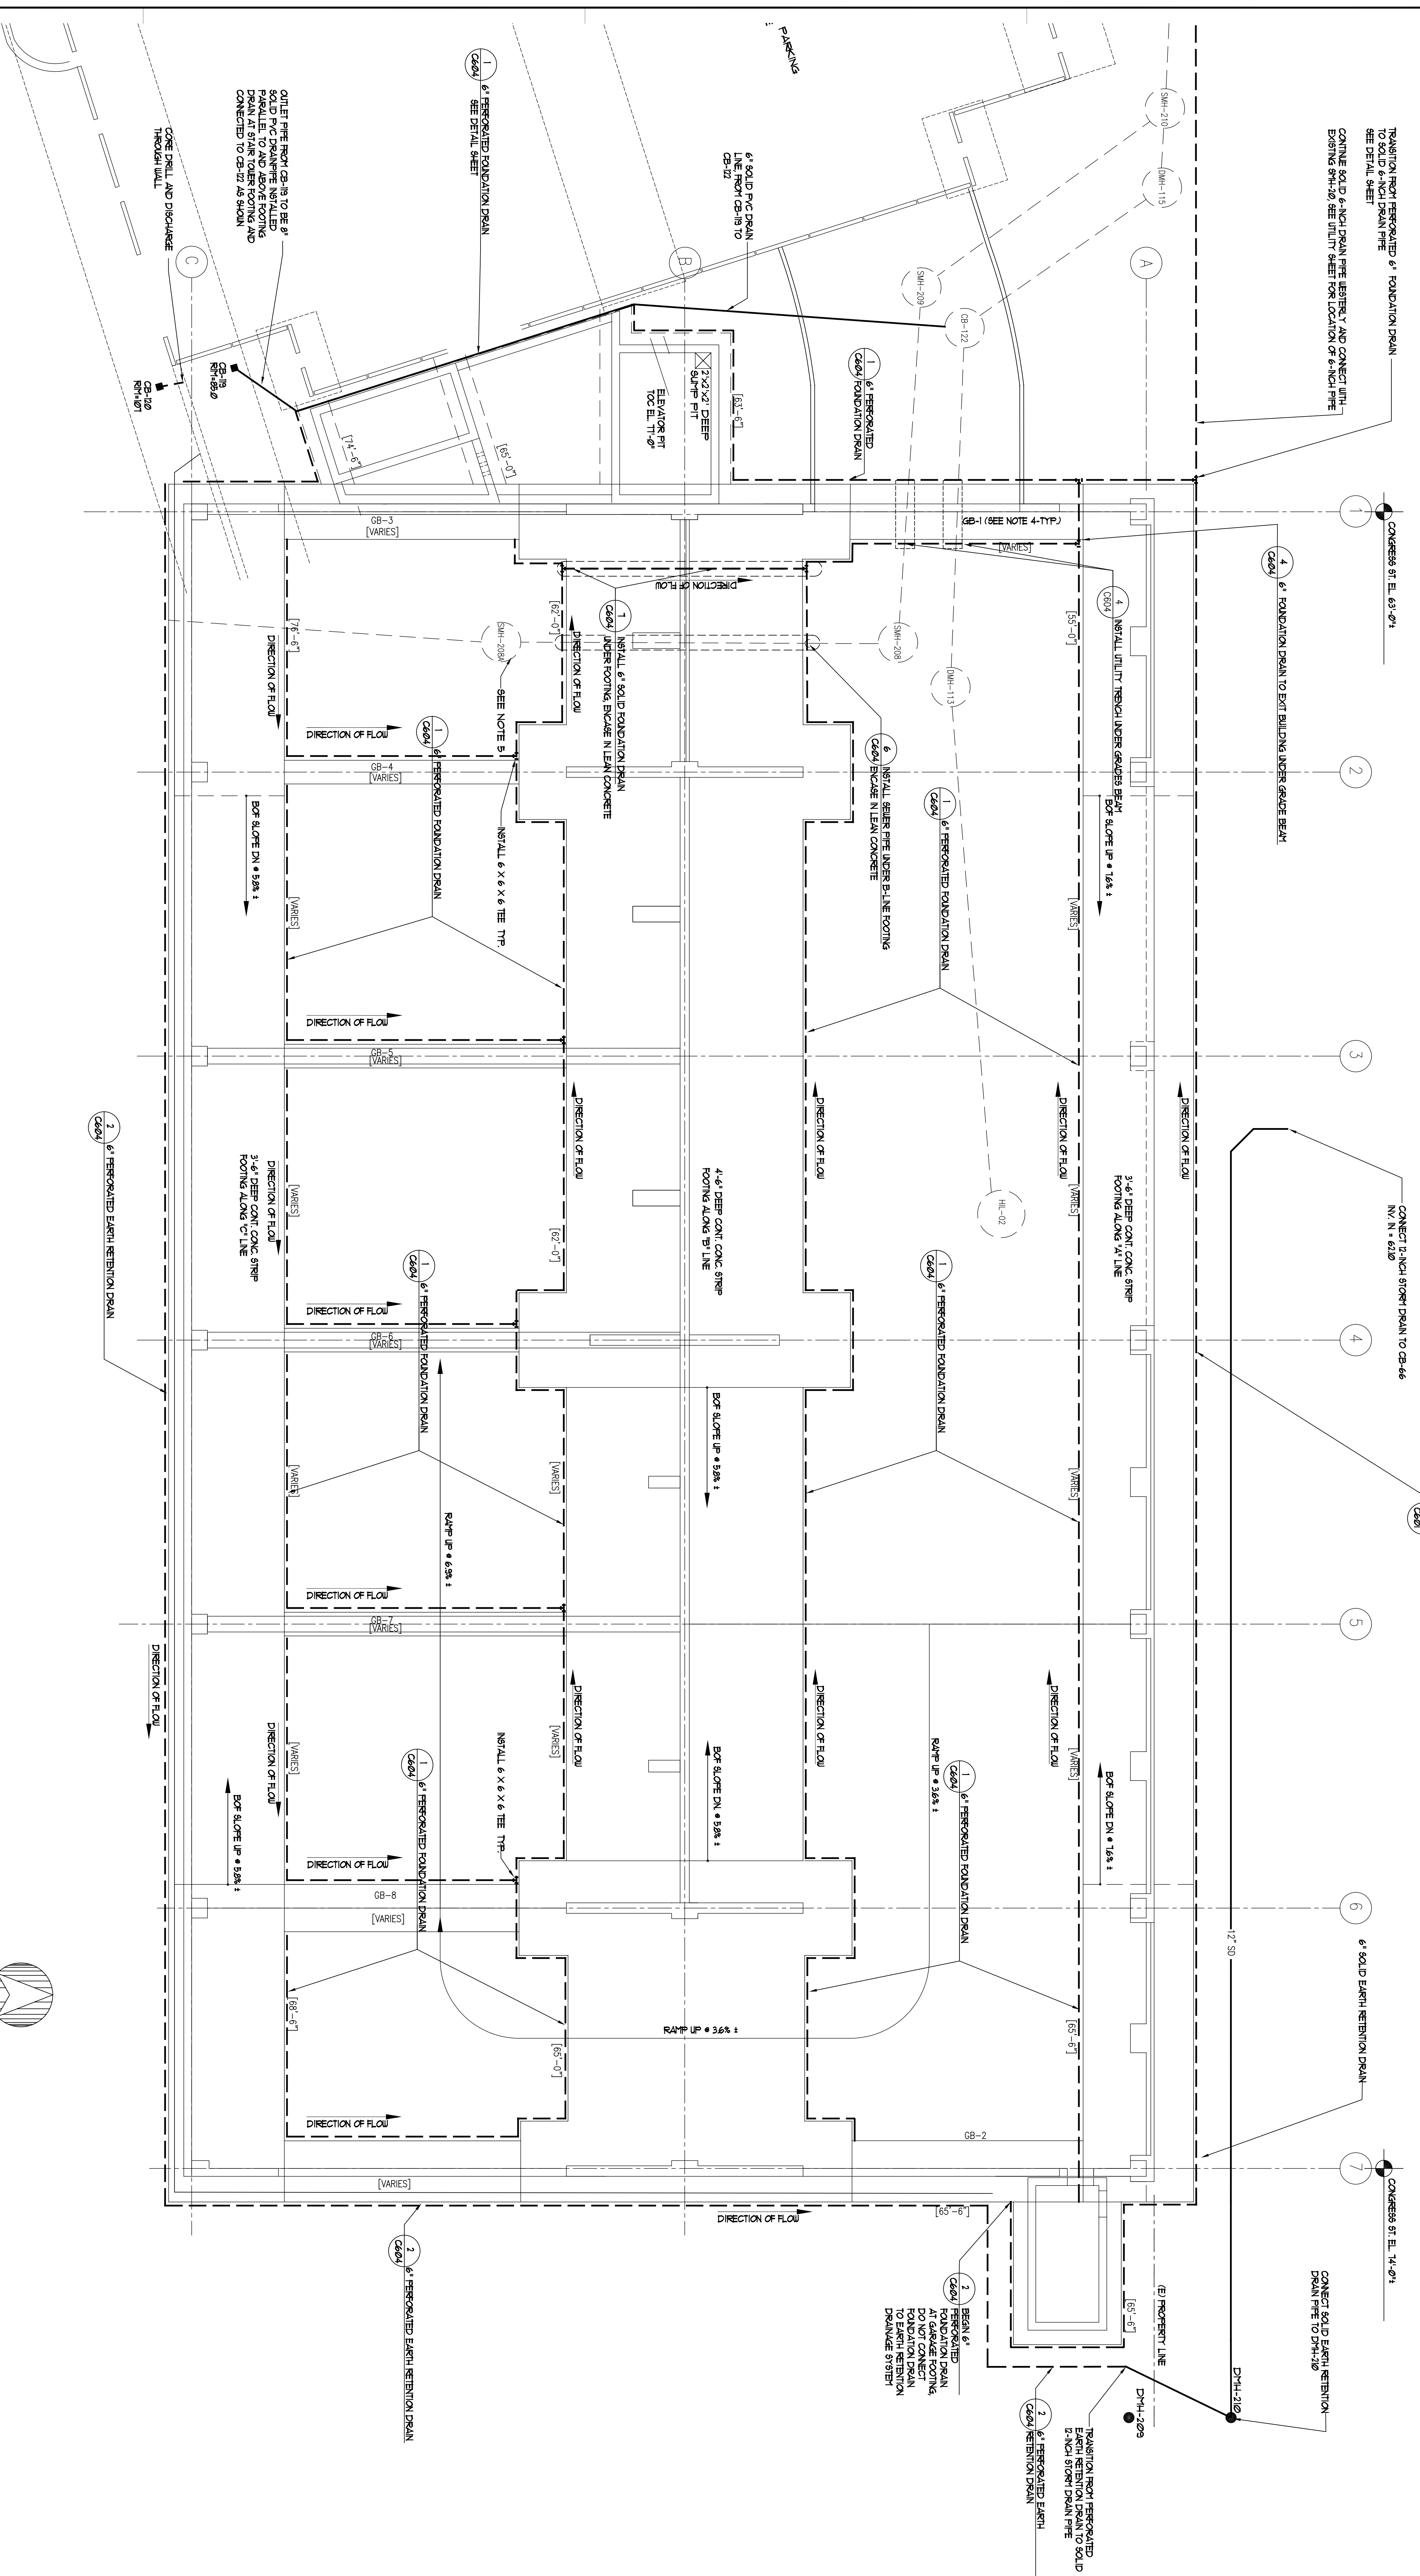

WORK	ISSUE DATE	DESCRIPTION
PERMIT SET	09/16/24	
80 SET	08/27/24	
ISSUE LOG		

TRO
 ARCHITECTURE
 ENGINEERING
 INTERIOR DESIGN

The Reliance Organization
 80 Bangor Street
 Portland, ME 04101
 617-686-9400

Maine Medical Center
 Pkg C - Site Utilities
 MMC Project No. 21846

GARAGE FOUNDATION AND SUB LEVEL 6 DRAINAGE PLAN

4677 Date Issued: 08/27/24
 Scale: 1/8"=1'-0" Sheet Number: PKG-C
 Drawn By: MLK
 Approved By: JTB
 Project No: 21846
 C-309