



0	10	20	40	60
---	----	----	----	----

4677 Date Issued: 08/17/04  
 Scale: 1"=50' Sheet Number: PKG-C  
 Drawn By: MJC  
 Approved By: (signature)  
 Project No. 21846  
**C501**

**Maine Medical Center**  
 Pkg C - Site Utilities  
 Portland, Maine  
 MMC Project No. 21846  
**LIGHTING PLAN**

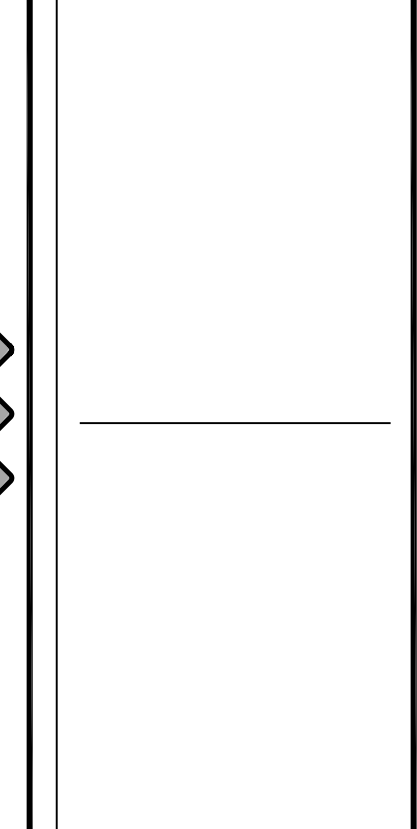

**TRO**  
 ARCHITECTURE  
 ENGINEERING  
 INTERIOR DESIGN  
 The Ruble Organization  
 60 Bridge Street  
 Portland, ME 04101  
 Telephone: 617-465-9400

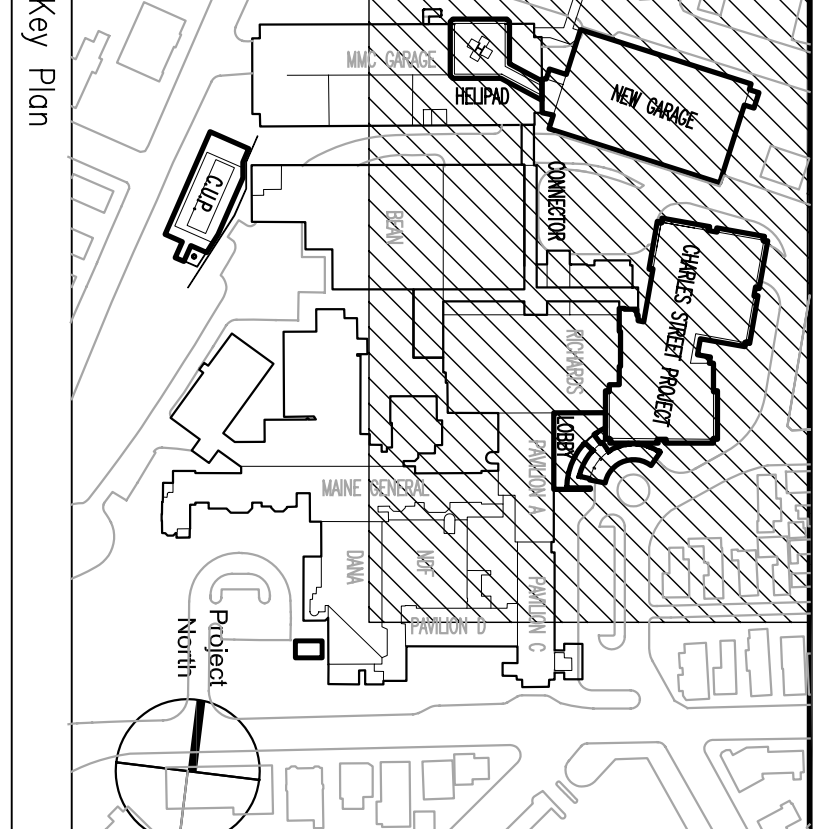

DATE	ISSUE DATE	DESCRIPTION
08/17/04	PERMIT SET	
08/27/04	BD SET	
	ISSUE LOG	

WORK ISSUED DESCRIPTION  
 \_\_\_\_\_  
 \_\_\_\_\_  
 \_\_\_\_\_

General Notes: