



**PLAN @ END**  
1"=0'-0"  
FOOTING NOT SHOWN

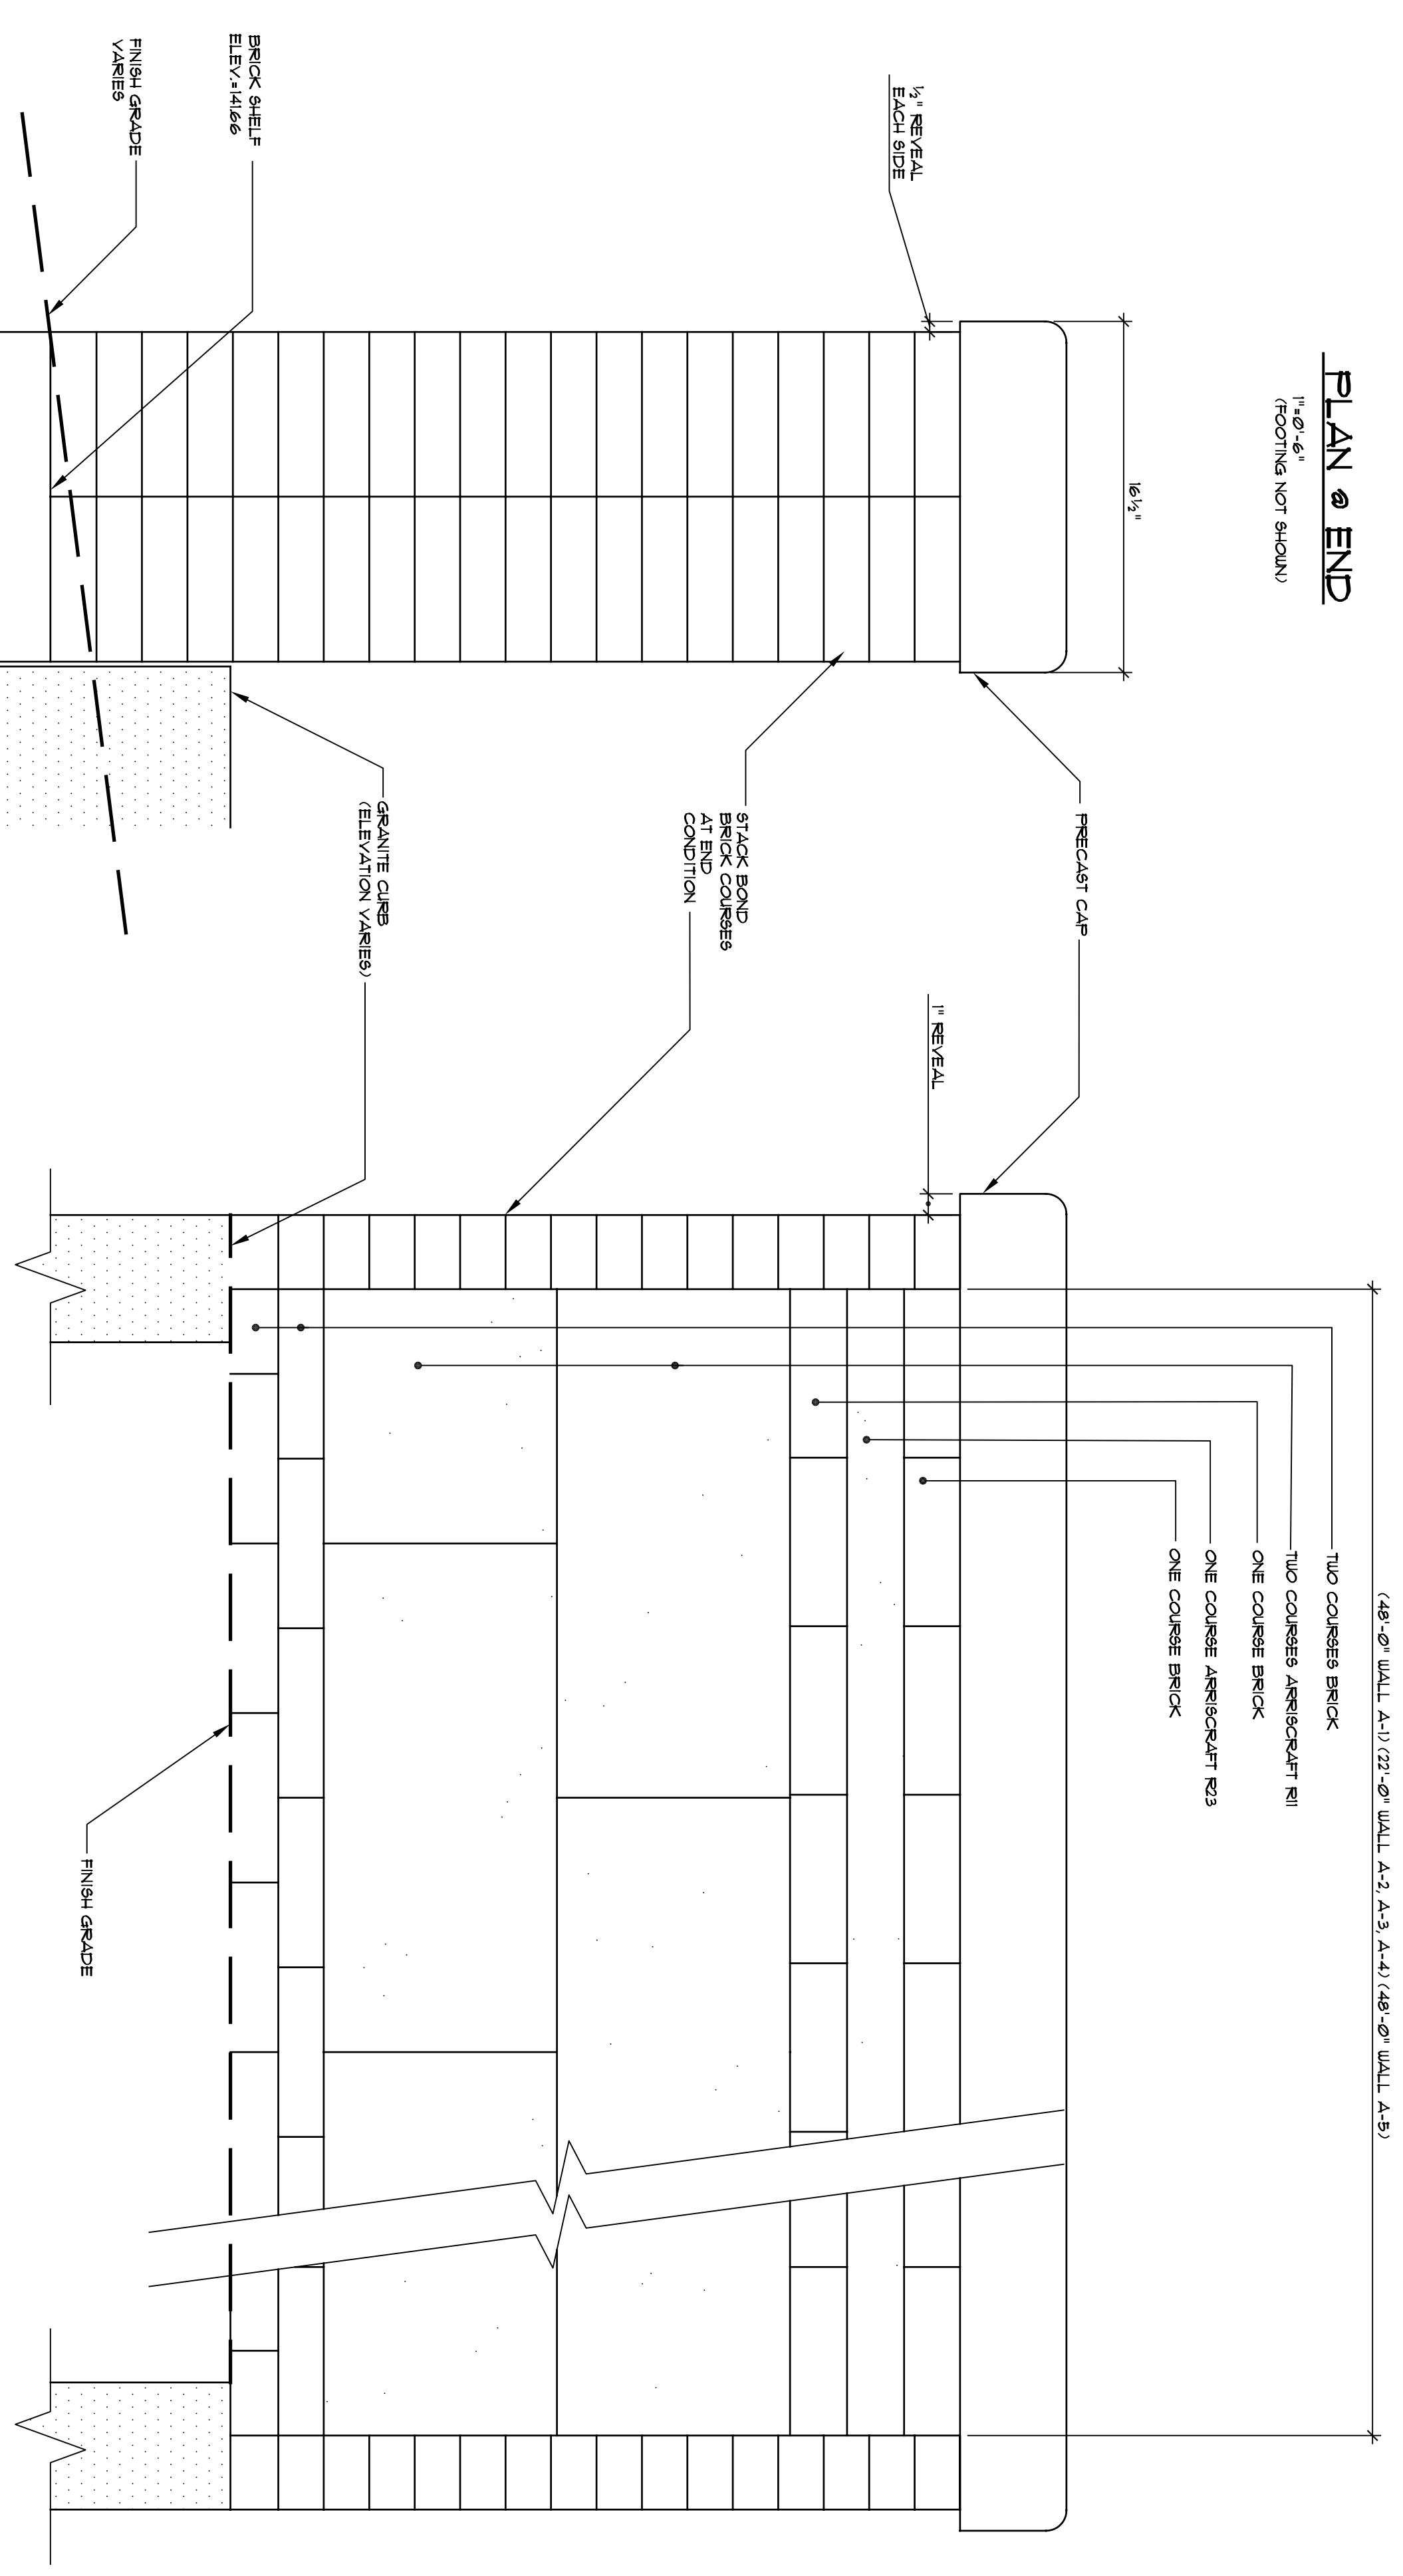


**SIDE ELEVATION (STREET SIDE)**  
1"=0'-0"  
FOOTING NOT SHOWN

**END CONDITION**  
1"=0'-0"

**1 SITE WALL "A" ELEVATION/END CONDITION**  
1"=0'-0"  
SEE SHEET C6604 FOR WALL CONNECTION DETAILS

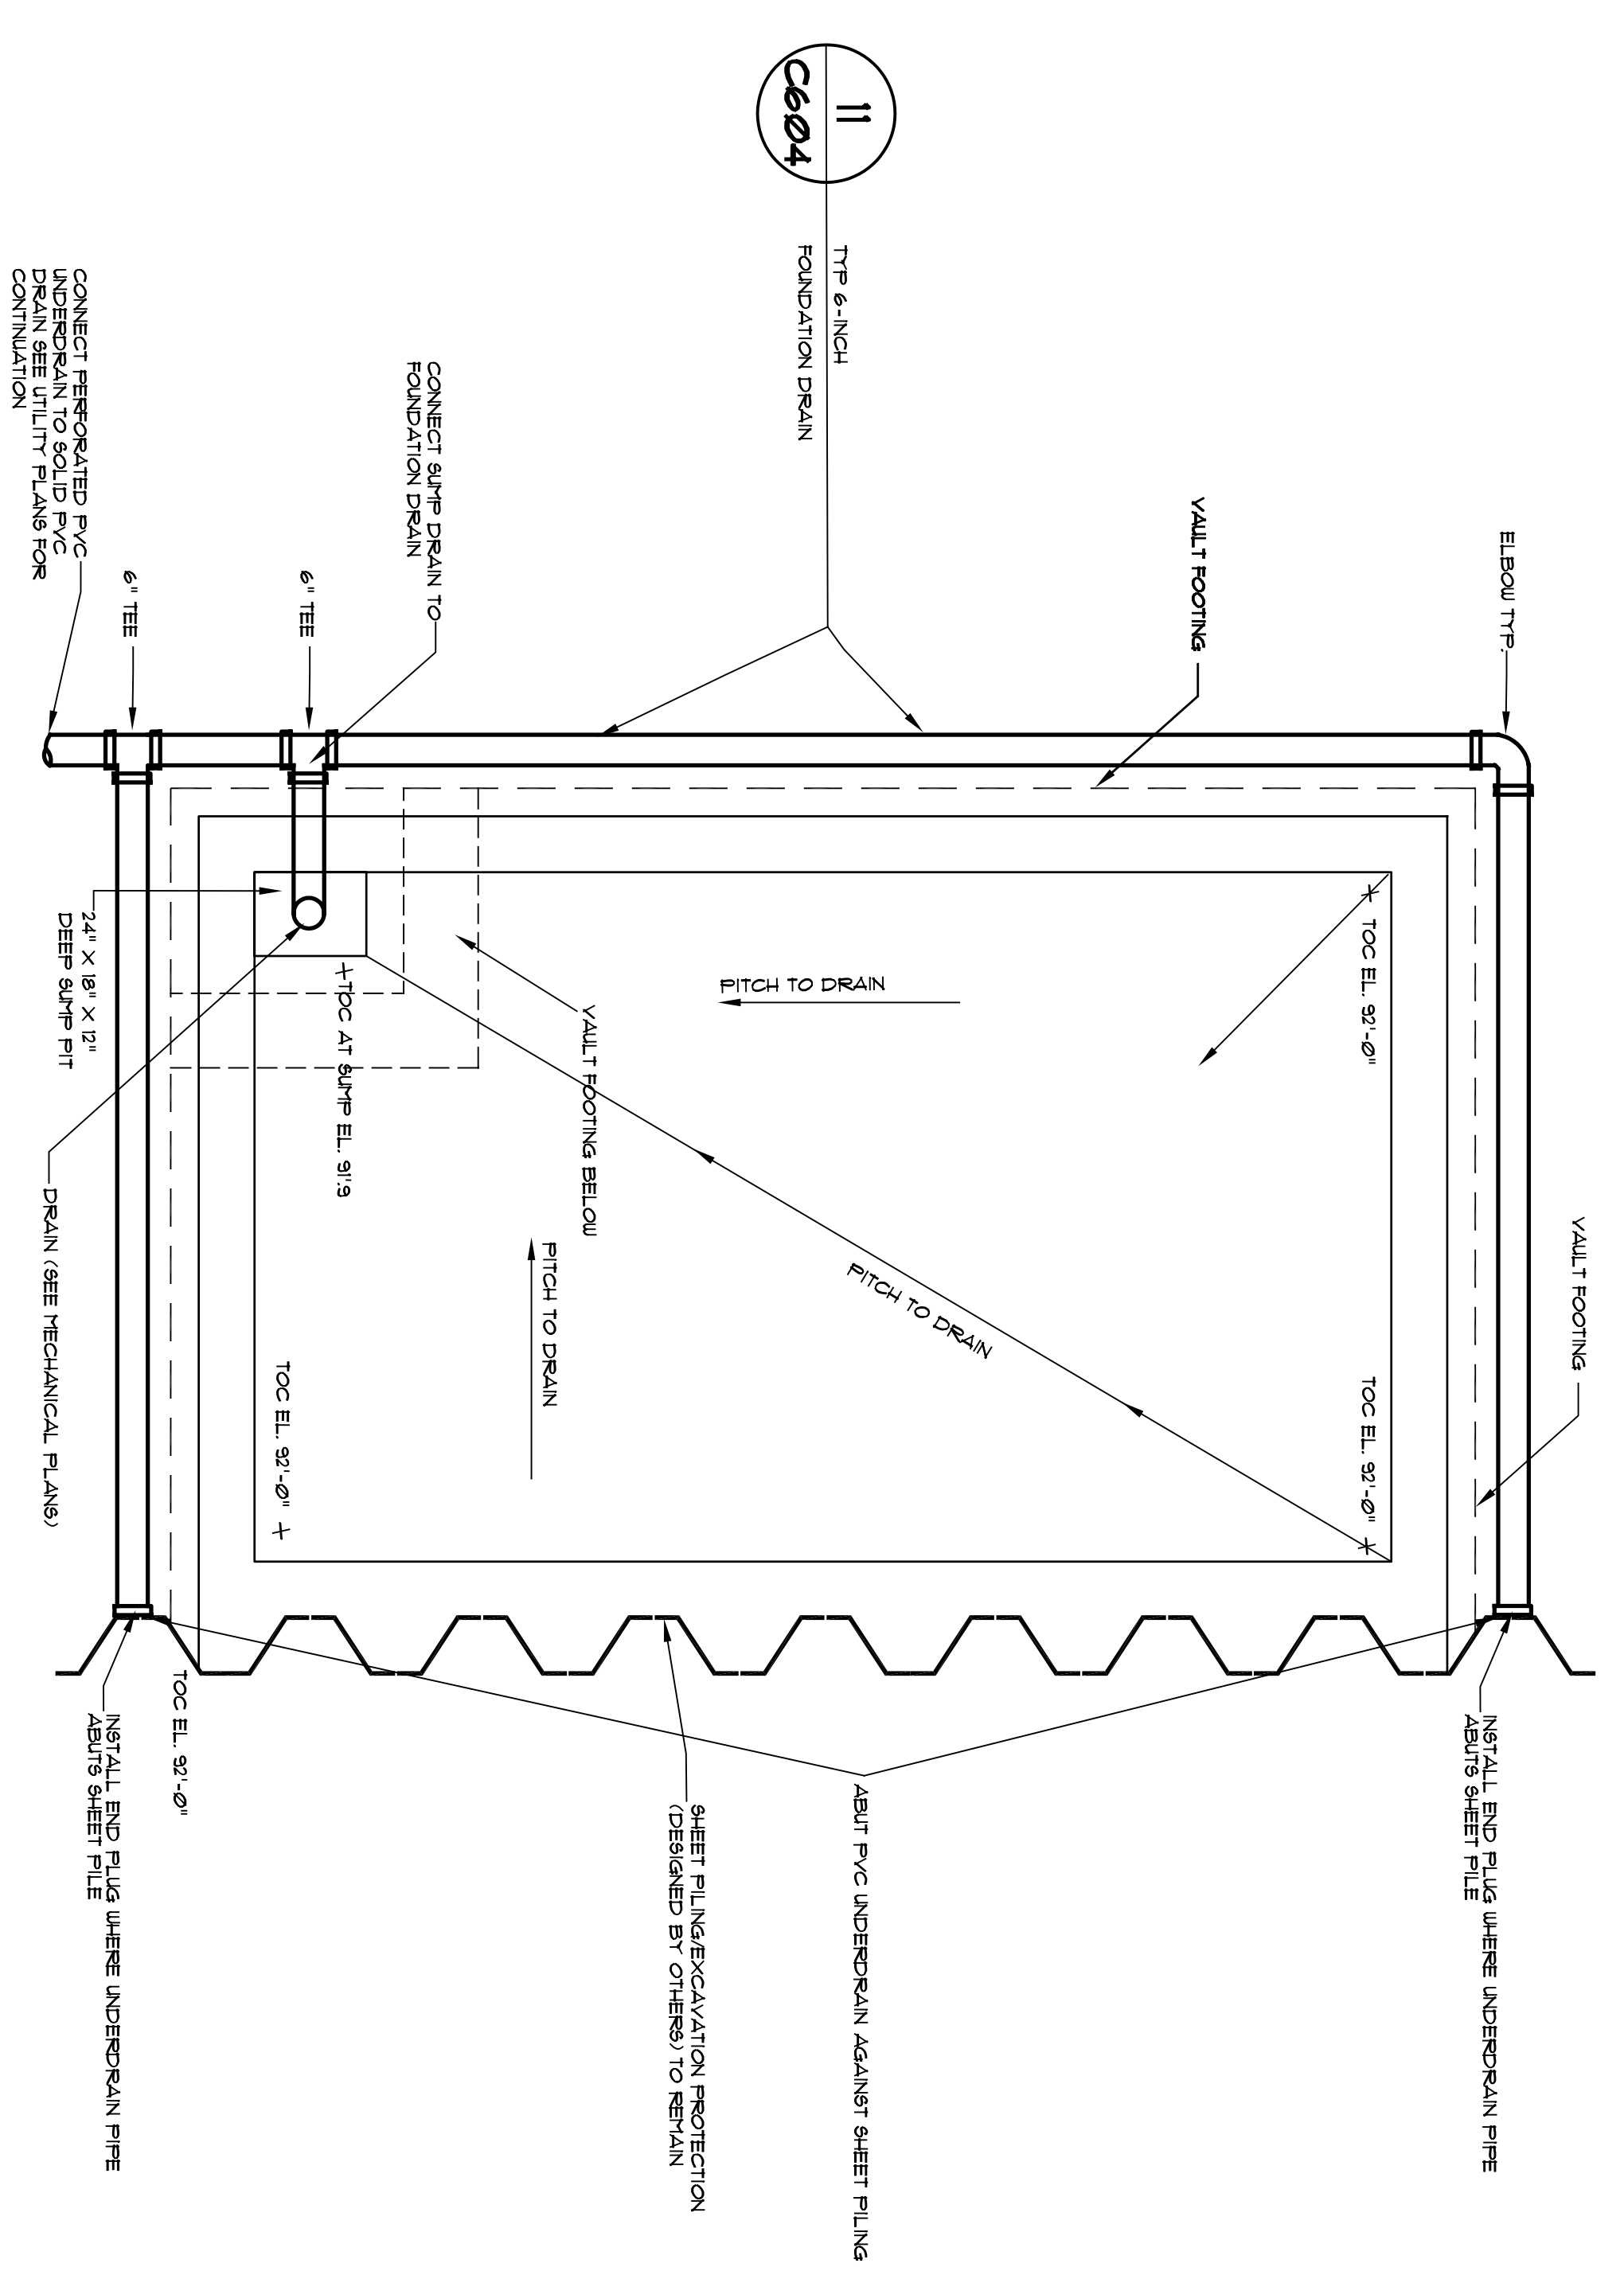


**3 MECHANICAL MANHOLE FOUNDATION DRAINAGE**  
NOT TO SCALE  
SEE MECHANICAL AND STRUCTURAL PLANS FOR MECHANICAL MANHOLE DETAILS

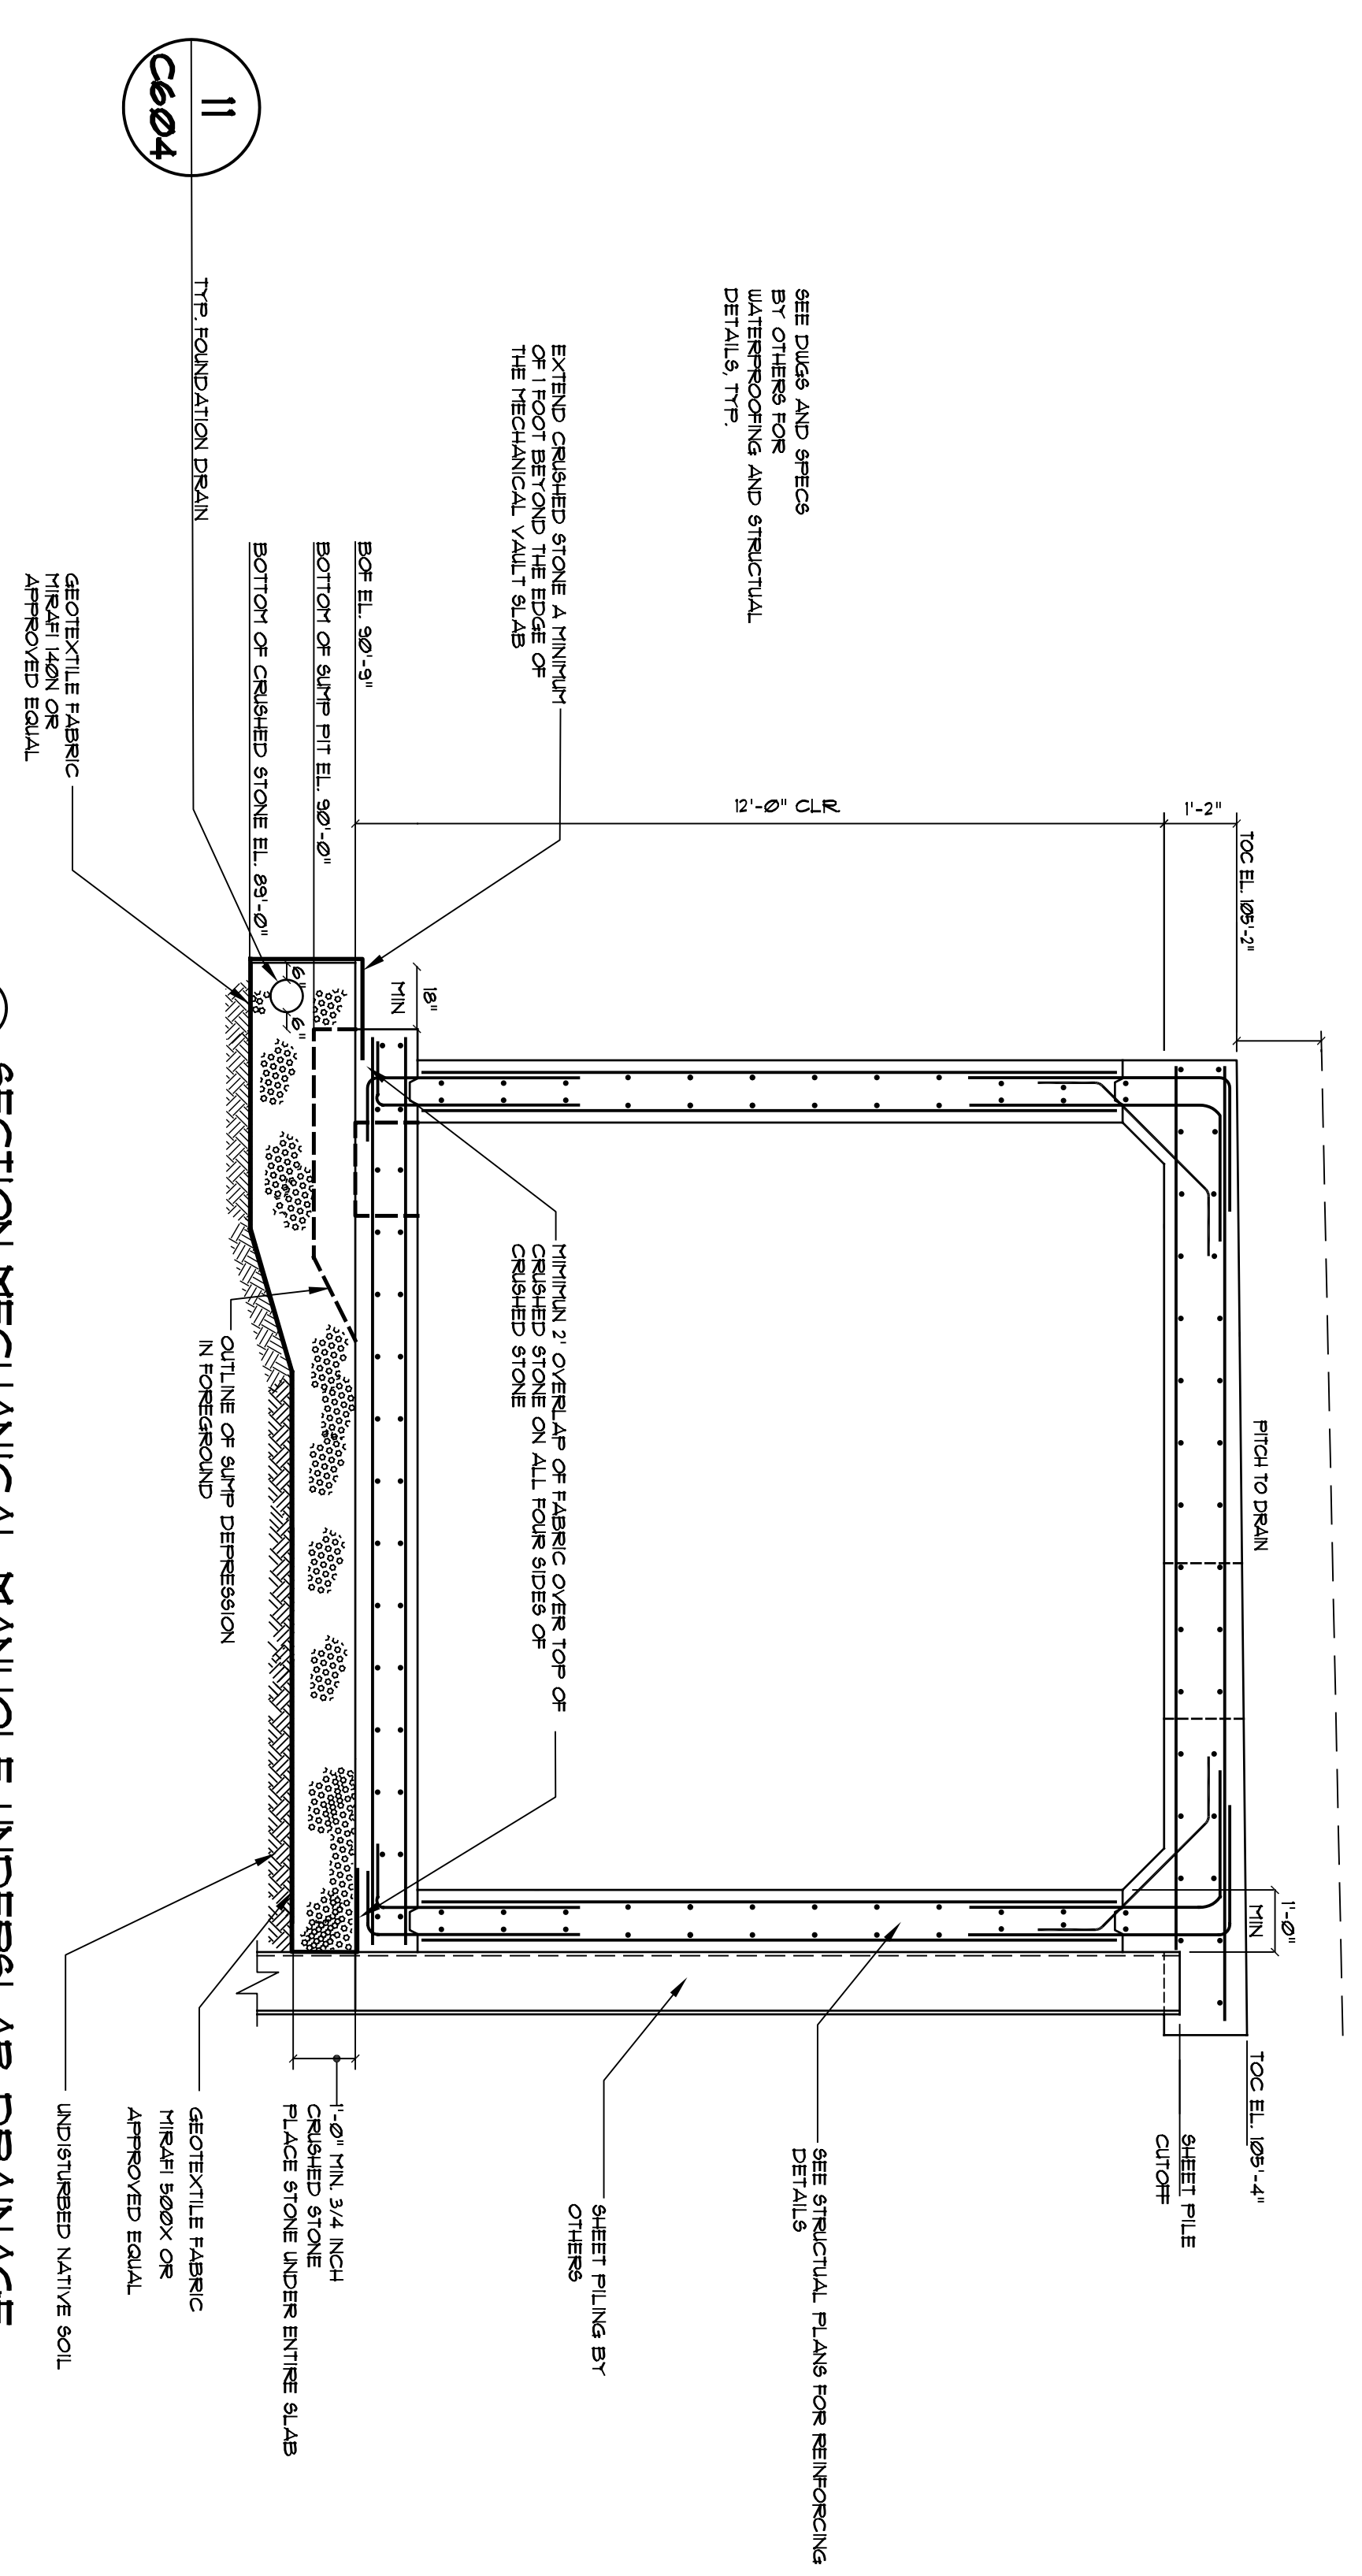

**2 SECTION MECHANICAL MANHOLE UNDERLAB DRAINAGE**  
NOT TO SCALE


NOTES:  
1. SEE SHEET C6604 FOR THE FOUNDATION AND FOOTING OF THE STONE WALL. THE FOUNDATION SHALL BE CONSTRUCTED AS SHOWN ON SHEET C6604 AND THE END OF THE STONE WALL SHALL BE FINISHED ON THE BASIS OF THE FOUNDATION AND FOOTING.  
2. THE SHEET PILING SHALL BE INSTALLED ON THE BASIS OF THE FOUNDATION AND FOOTING.  
3. CONCRETE REINFORCED PVC UNDERDRAIN AND TRANSITION TO SOLID PVC DRAIN.  
4. CONCRETE REINFORCED PVC DRAIN PIPE TO DRAIN TO THE UTILITY PLAN OR LAYOUT OF PIPE.

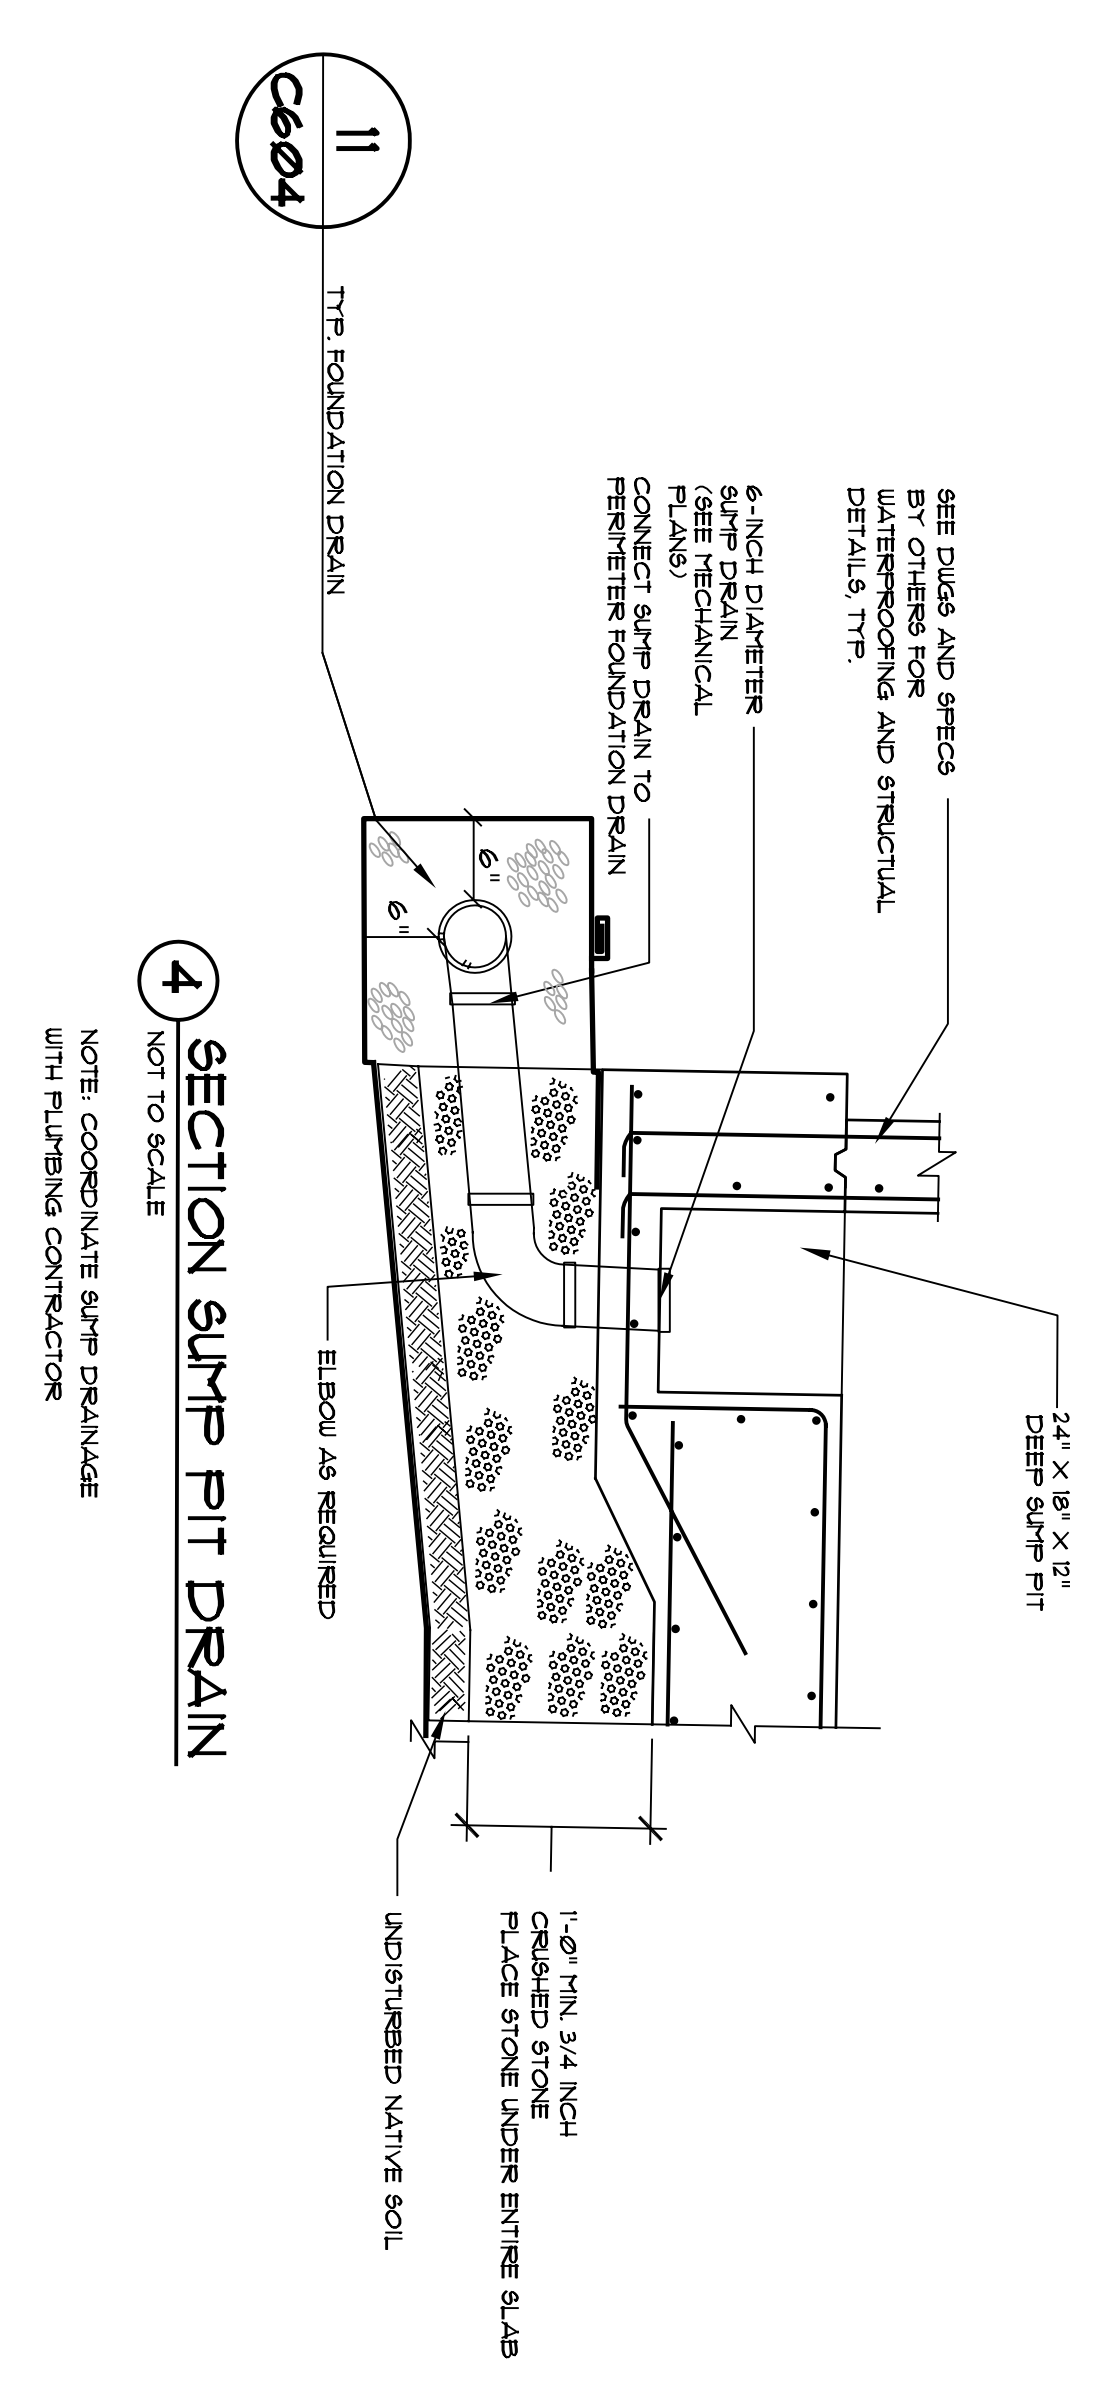

**4 SECTION SUMP PIT DRAIN**  
NOT TO SCALE  
NOTE: ACCURATE SUPPLEMENTARY WITH FINISHING CONSTRUCTION

General Notes:

WORK	ISSUE DATE	DESCRIPTION
PERMIT	09/18/24	PERMIT SET
ISSUE	09/27/24	ISSUE SET

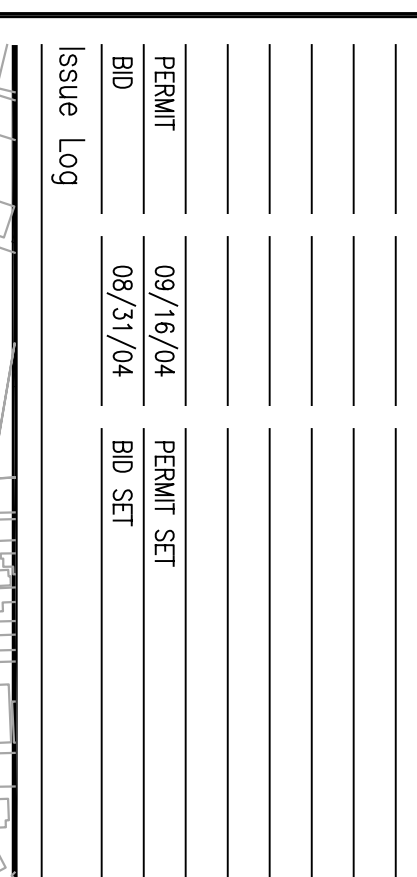

**TRO**  
ARCHITECTURE  
ENGINEERING  
INTERIOR DESIGN  
The Ruble Organization  
80 Bridge Street  
Portland, ME 04101  
Tel: 617-659-9400

**Maine Medical Center**  
Pkg C - Site Utilities  
MMC Project No. 21846

4677 Date Issued: 09/17/24  
Scale: AS SHOWN Sheet Number: PKC-C  
Drawn By: ECL  
Approved By: JLD  
Checked By: JLD  
Project No.: 21846  
Copyright © 2024 The Ruble Organization  
**C606**