
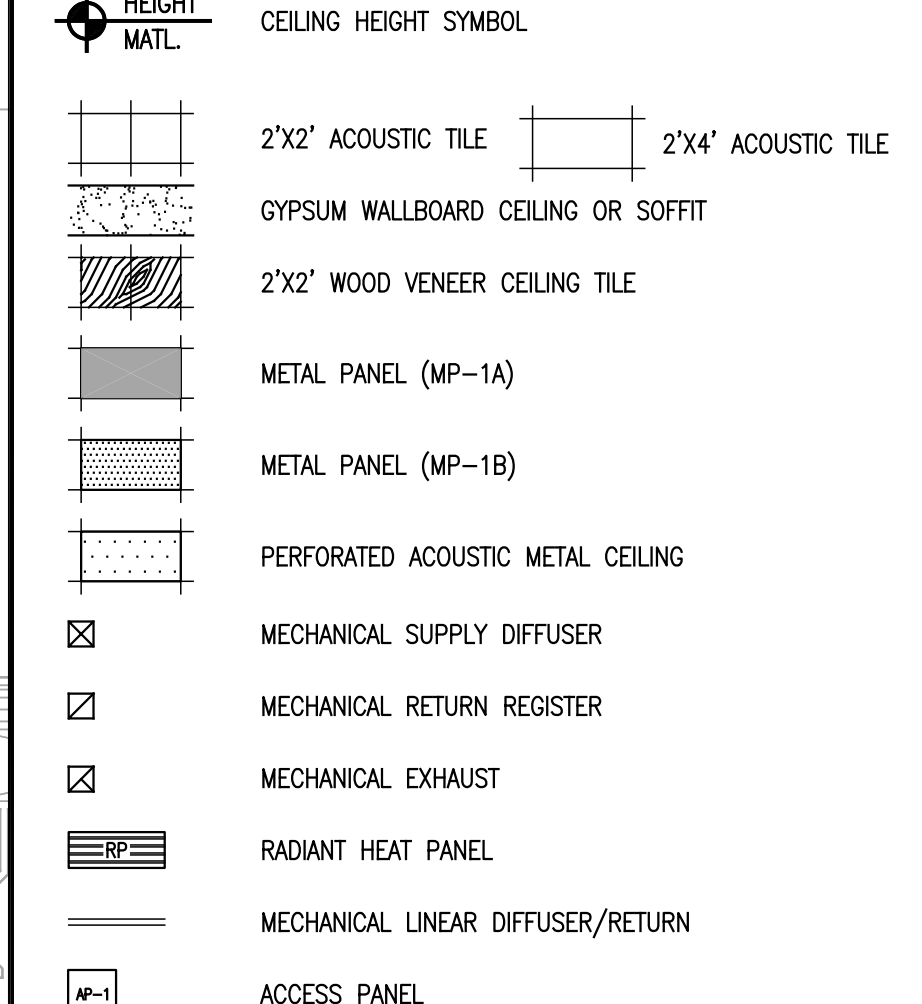



General Notes:  
 1. ALL CEILING HEIGHTS SHALL BE 8'-0" UNLESS OTHERWISE NOTED  
 2. ALL SOFFIT HEIGHTS SHALL BE 7'-2" UNLESS OTHERWISE NOTED  
 3. ALL CEILING GRIDS ARE CENTERED IN ROOMS UNLESS NOTED OTHERWISE  
 4. ABBREVIATION "ACT" DEFINES THE USE OF A FULL TILE

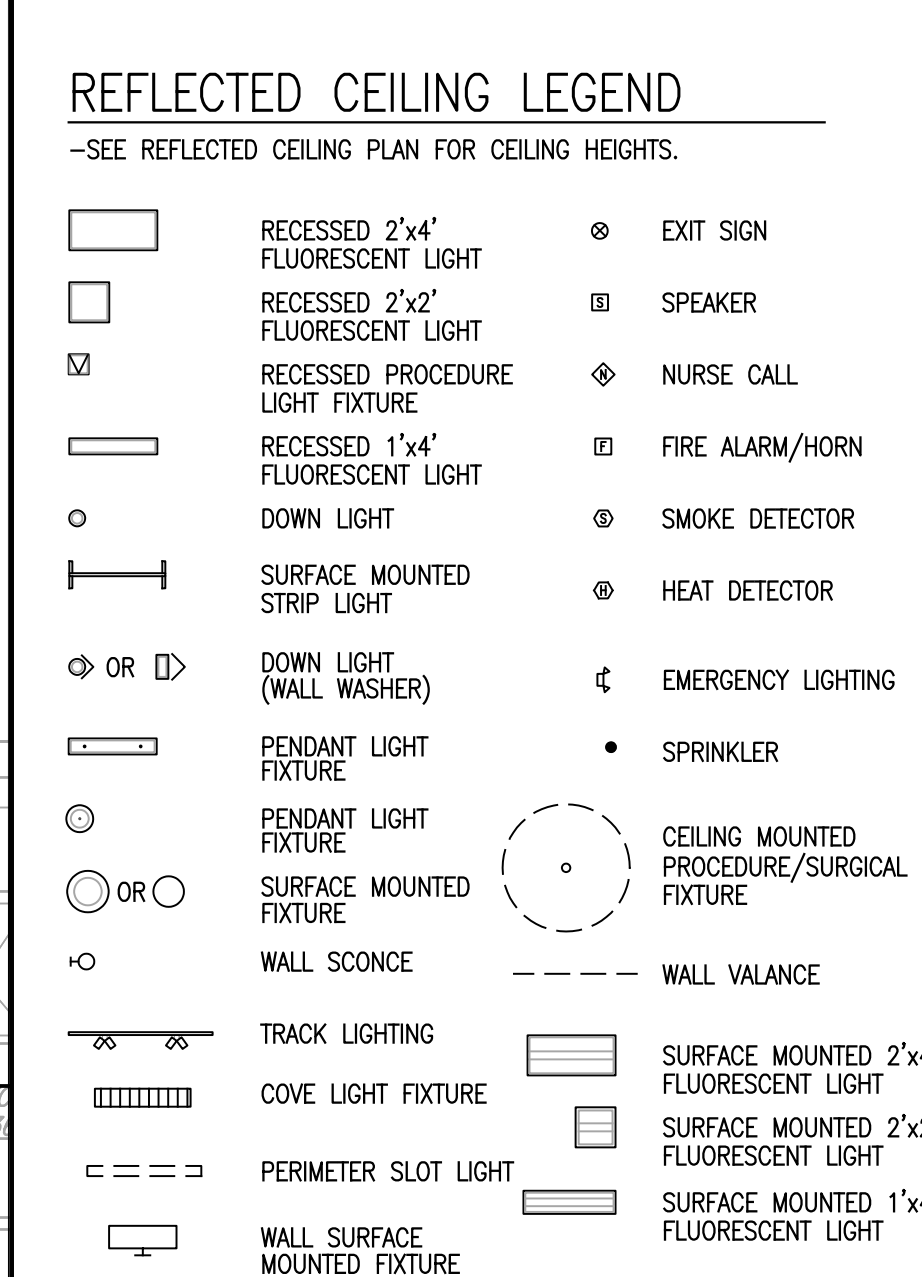

MARK	ISSUE DATE	DESCRIPTION

PERMIT	09/18/04	PERMIT SET
BD	08/28/04	BD SET

Issue Log

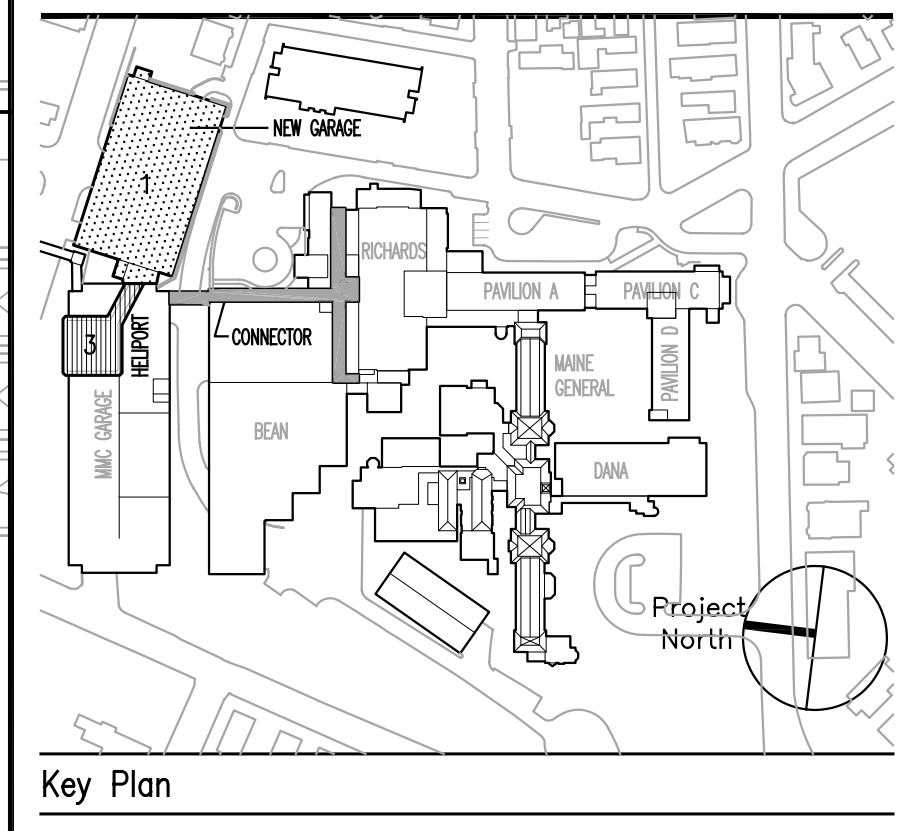

**TRO**  
 ARCHITECT  
 PLANNING  
 ENGINEERING  
 INTERIOR  
 The Ritchie Organizat'  
 80 Bridge Street  
 Newton, MA 02459-1  
 617-552-94

**Maine Medical Center**  
 Pkg F - Garage / Vault / Conn / Heliport  
 Portland, ME MMC Project No. 21845

Drawing Title  
**CONNECTOR  
 GROUND FLOOR  
 REFLECTED CEILING PLAN**

0' 4' 8' 16' 32'

Commission No.	4678	Date Issued	08/28/04
Scale	1/8" = 1'-0"	Sheet Number	PKG-F
Drawn By	BJS/RG	Approved By	JW
File Name	4678A30G.2.dwg	Project	A30G.2
Copyright	© 2004		