
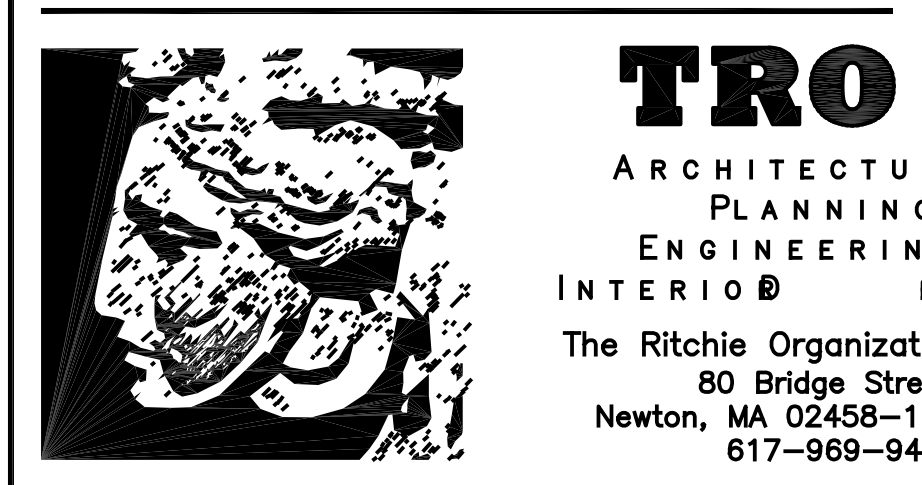


MARK	ISSUE DATE	DESCRIPTION

PERMIT	ISSUE DATE	DESCRIPTION
BD	08/28/04	BD SET

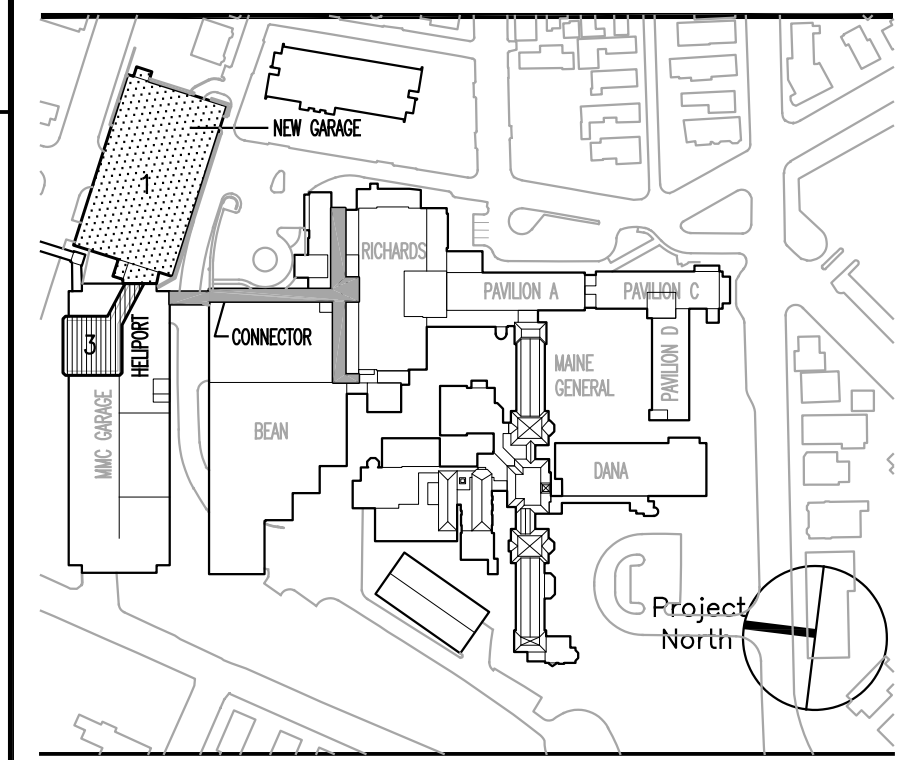

**Maine Medical Center**  
Pkg F - Garage / Vault / Conn / Heliport  
Portland, ME MMC Project No. 21845

Drawing Title  
**CONNECTOR  
EXTERIOR ELEVATIONS**

Commission No.	4678	Date Issued	08/28/04
Scale	1/8" = 1'-0"	Sheet Number	PKG-F
Drawn By	AD/LR		
Approved By	JW		
Filename	4678A405.dwg		
Copyright	© 2004 The Ritchie Organization		