



A5 NORTH CORRIDOR LINK
WALL SECTION AT CW
SCALE: 3/8" = 1'-0"

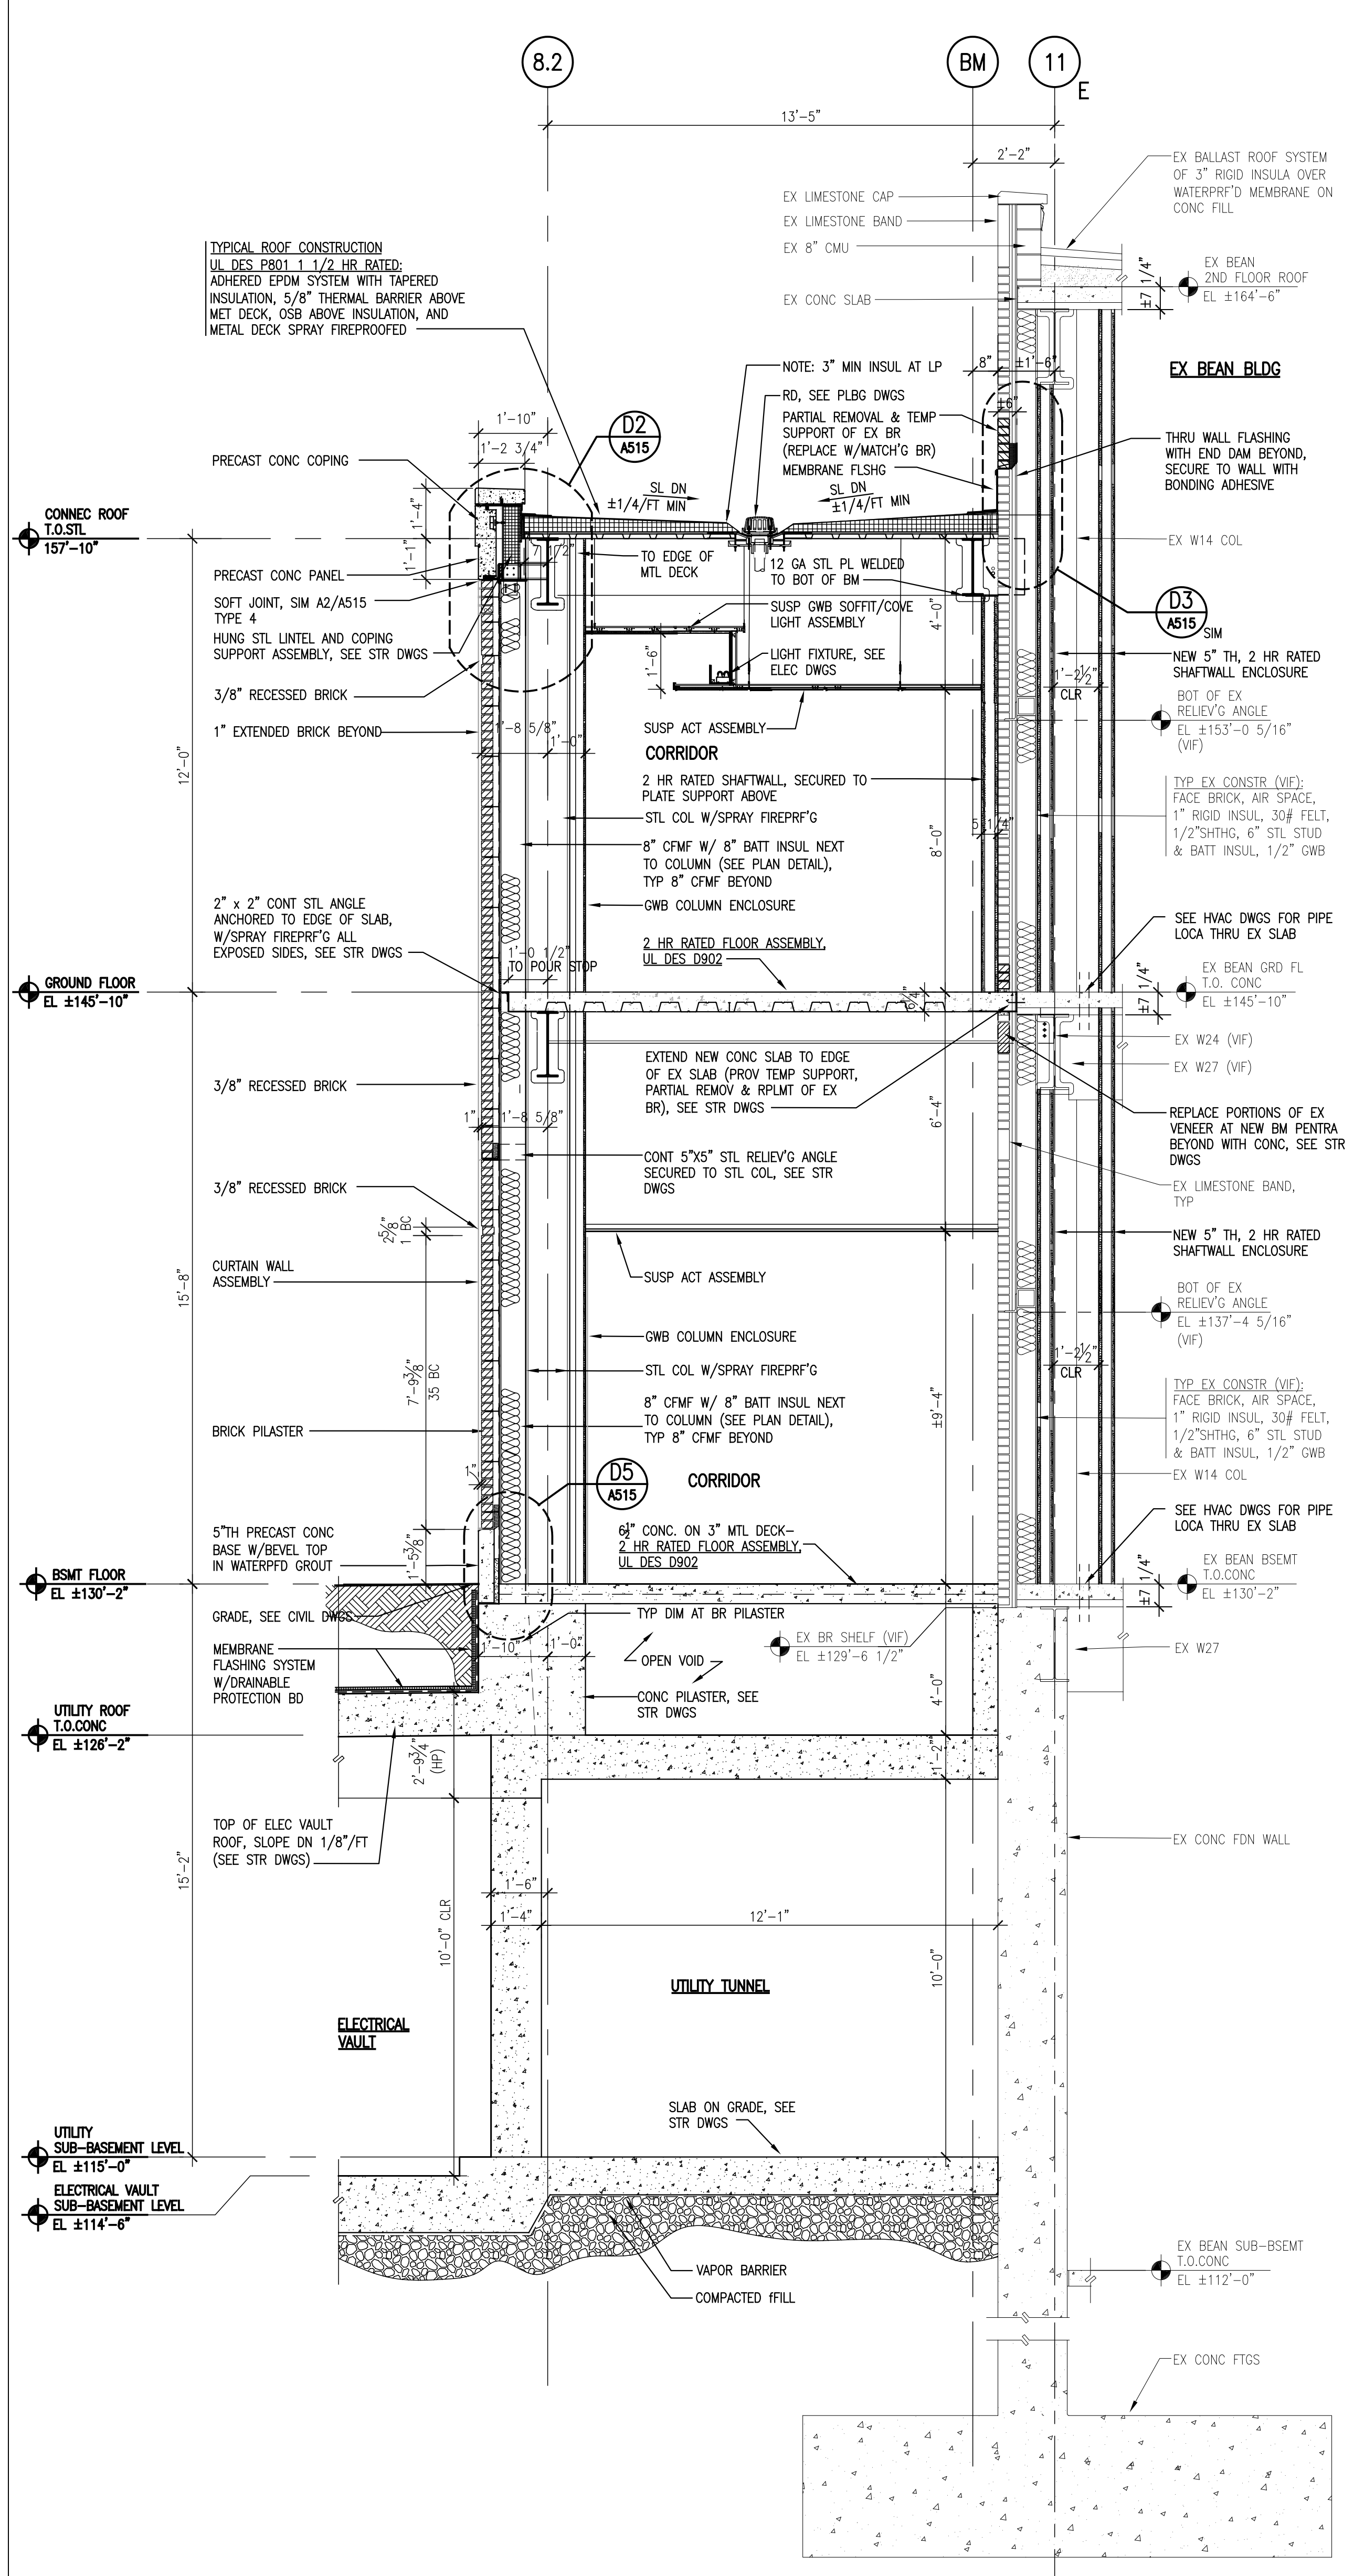


C5 NORTH CORRIDOR LINK
WALL SECTION AT BRICK PILASTER
SCALE: 3/8" = 1'-0"

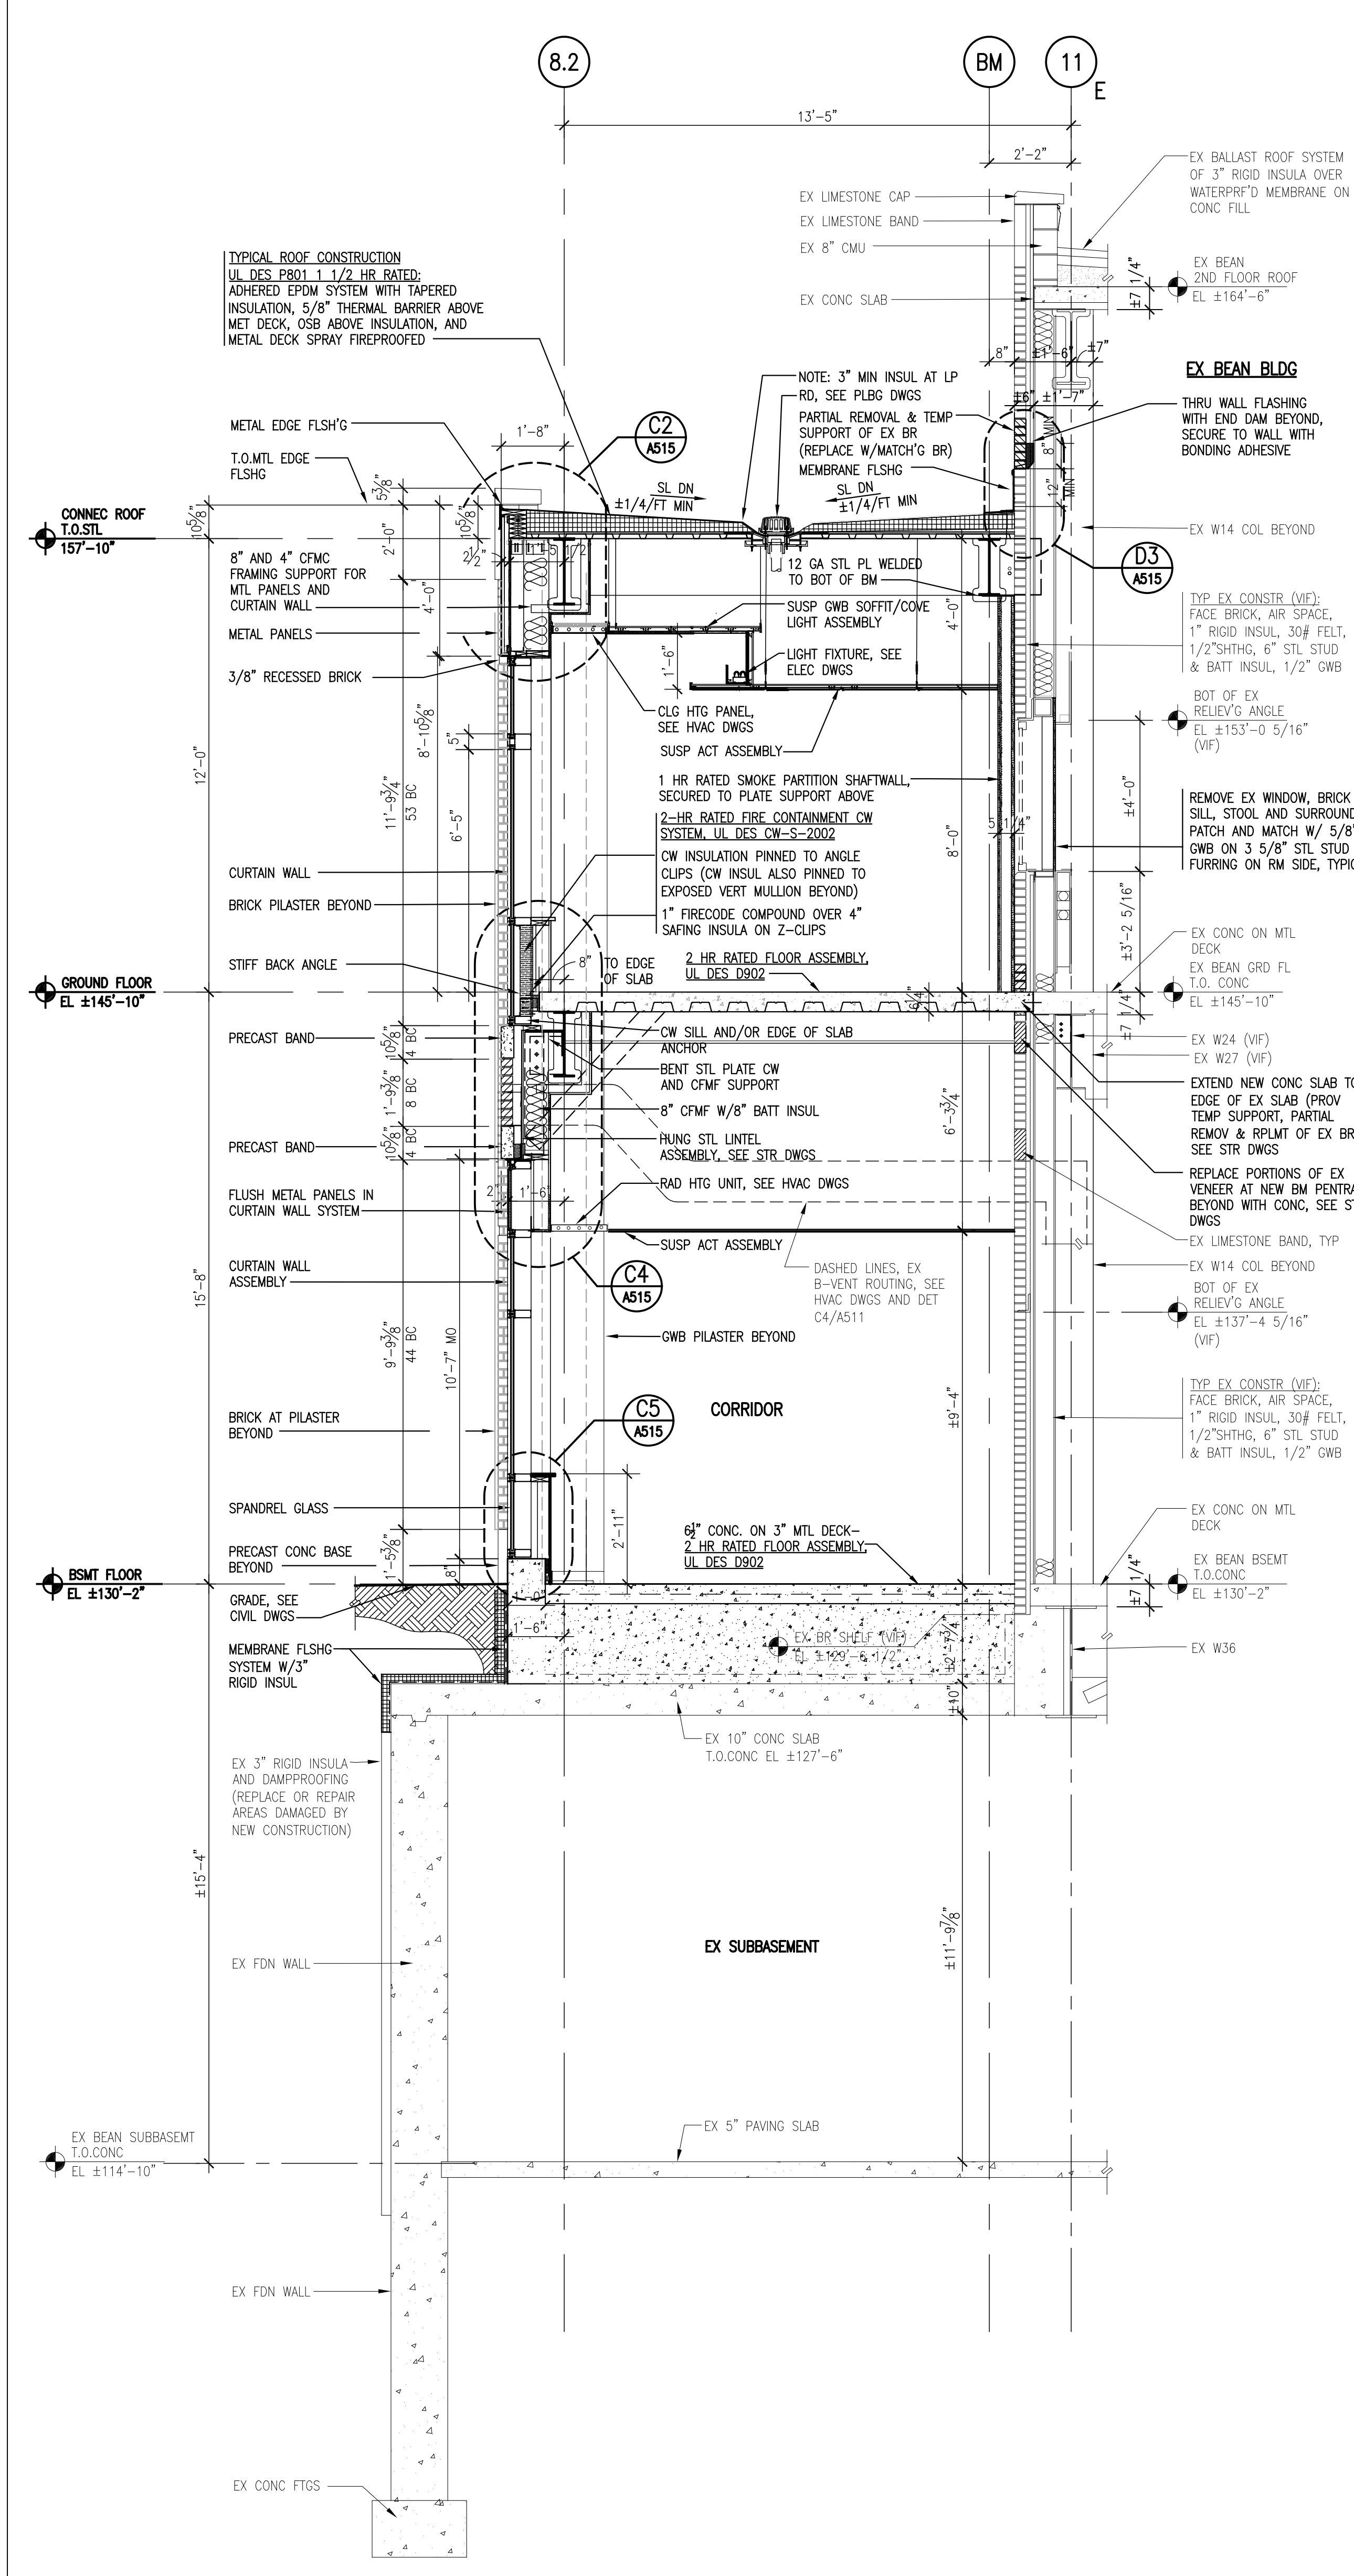

E5 NORTH CORRIDOR LINK
WALL SECTION AT CW
SCALE: 3/8" = 1'-0"

MARK	ISSUE DATE	DESCRIPTION
PERMIT	09/18/04	PERMIT SET
BD	08/28/04	BD SET

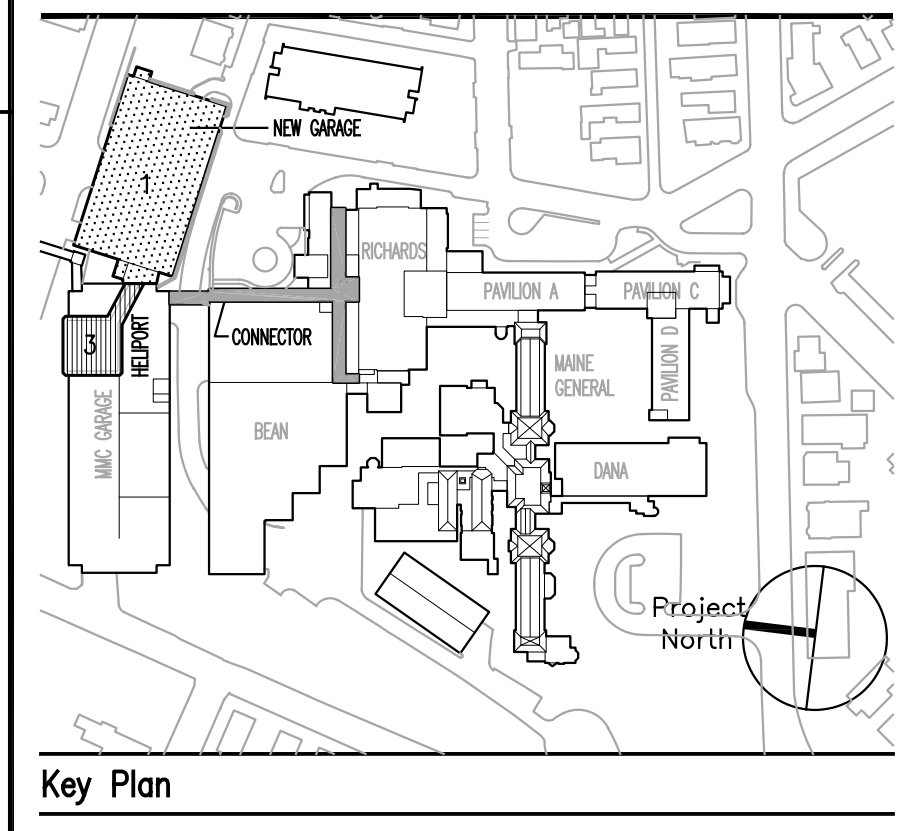

TRO
ARCHITECTURAL
PLANNING
ENGINEERING
INTERIOR
The Ritchie Organization
80 Bridge Street
Newton, MA 02459-1111
617-552-9444

Maine Medical Center
Pkg F - Garage / Vault / Conn / Heliport
Portland, ME MMC Project No. 21845

Drawing Title
**CONNECTOR
WALL SECTIONS
NUMBER 1**

Commission No.	4678	Date Issued	08/28/04
Scale	AS NOTED	Sheet Number	PKG-F
Drawn By	FC	Approved By	FC
File Name	4678A505.dwg		A505
Copyright	© 2004	The Ritchie Organization	