




**BASEMENT FLOOR PLAN
SECTOR A EQUIPMENT PLAN**
SCALE: 1/8" = 1'-0"

MARK	ISSUE DATE	DESCRIPTION
BID	12/14/07	BID SET
Issue Log		

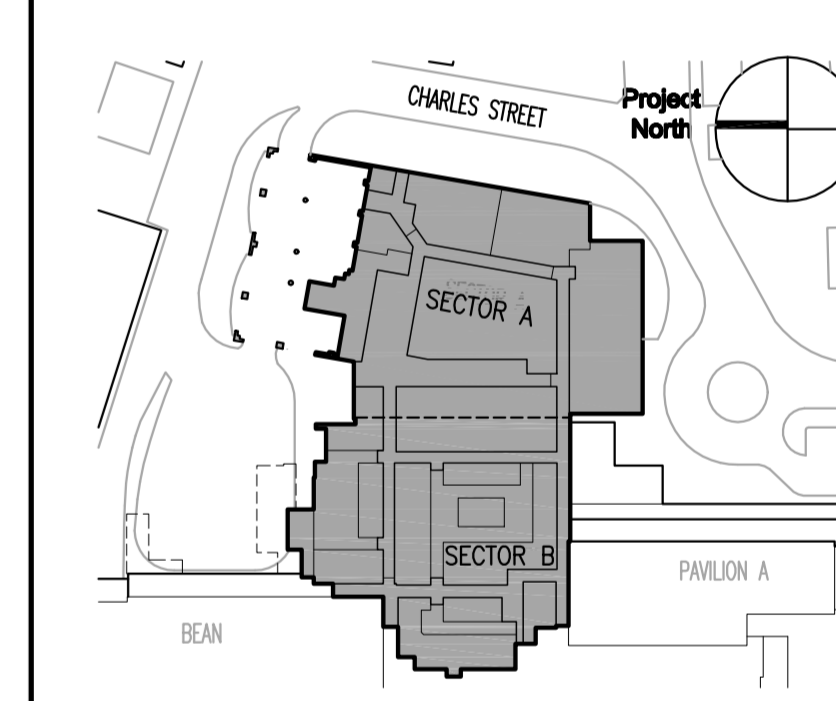

Key Plan

TRO Jung|Brannen
ARCHITECTURE INTERIOR DESIGN ENGINEERING MASTER PLANNING
22 Boston Wharf Road, Boston, Massachusetts 02210
Tel 617.502.8400 Fax 617.502.3402 www.trojungbrannen.com

Maine Medical Center
ED Expansion and Renovation
Portland, Maine MMC Project No. 21843

Drawing Title
**BASEMENT FLOOR PLAN
SECTOR A
EQUIPMENT PLAN**

Drawn By	JW/PF	Commission No.	4696
Approved By	JW	Date Issued	12/14/07

Phase / Package Number	Sheet Number
	A20B.AQ