


LEGEND


EXISTING	DESCRIPTION	PROPOSED
	BUILDING	
	SIGN	
	EDGE PAVEMENT	
	CURBLINE	
	SEWER MANHOLE	
	DRAIN MANHOLE	
	LIGHT POLE	
	GRANITE BOLLARD	

- NOTES:**
- SITE LIGHTING IS NOT INCLUDED IN THE EMERGENCY DEPARTMENT EXPANSION SCOPE OF WORK. SITE LIGHTING IS INCLUDED IN PACKAGE 'C'. SITE LIGHTING LOCATIONS SHOWN ON THIS SHEET SUPERSEDE THE LOCATIONS SHOWN ON THE PACKAGE 'C' PLANS.
 - ALL SIGNS NOTED (ST-5) ARE NOT IN CONTRACT.
 - BID ALTERNATE NO. 3 - CHANGE CONCRETE PAVING TO BITUMINOUS PAVING; ELIMINATE FLUSH CURB. ADD 4" YELLOW PAINT STRIPING AT PERIMETER OF 'ISLAND' AND 24" O.C. WITHIN ENTIRE AREA.
 - CONCRETE RETAINING WALL IS PART OF PACKAGE 'C' SCOPE OF WORK AND IS SHOWN FOR REFERENCE ONLY.

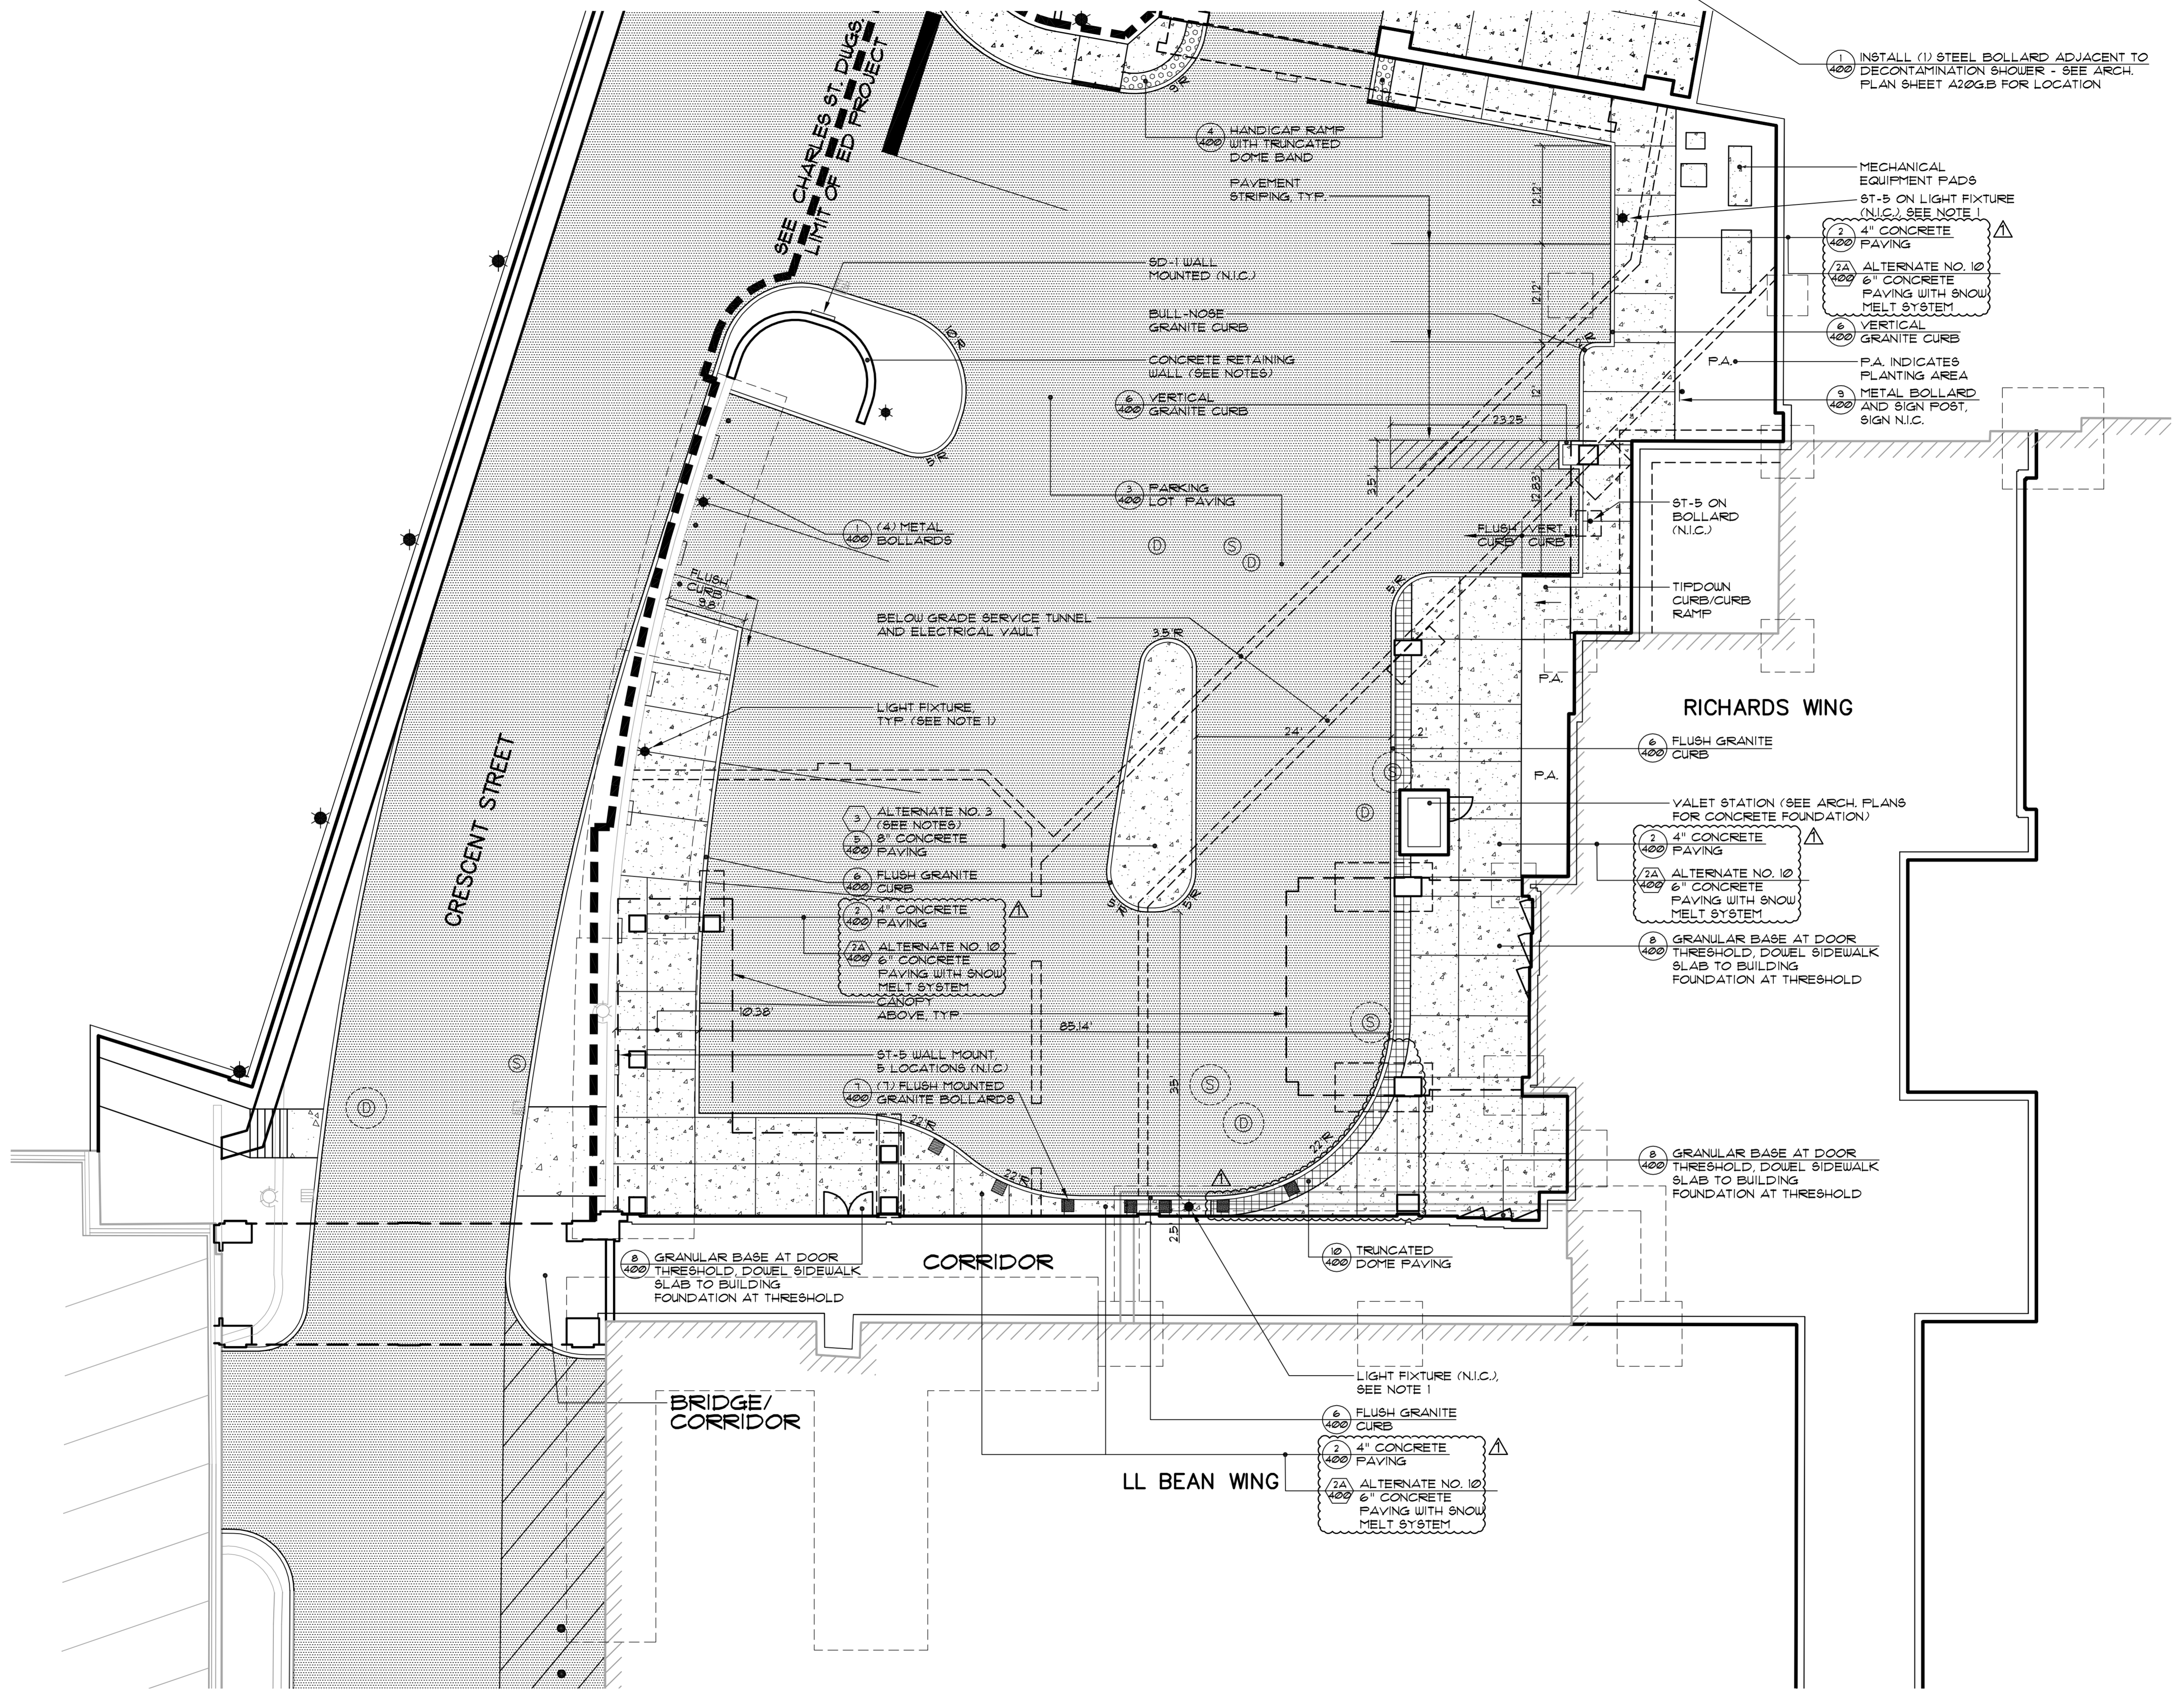

MARK	ISSUE DATE	DESCRIPTION
	1/11/08	ADDENDUM NO. 1
	12/14/07	BID SET

Issue Log

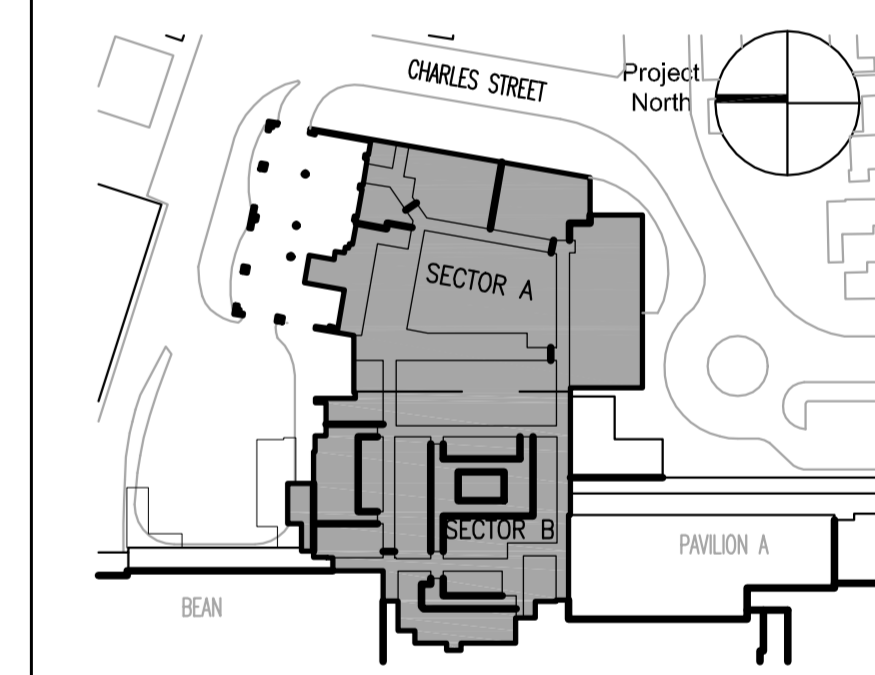

Key Plan

TRO Jung|Brannen
 ARCHITECTURE INTERIOR DESIGN ENGINEERING MASTER PLANNING
 22 Boston Wharf Road, Boston, Massachusetts 02210
 Tel 617.502.8400 Fax 617.502.3402 www.trojngbrannen.com

Maine Medical Center
 ED Expansion and Renovation
 Portland, Maine MMC Project No. 21843

Drawing Title
SITE PLAN

Drawn By	MAL	Commission No.	4696
Approved By	WTC	Date Issued	12/14/07
Phase / Package Number	Sheet Number		
	C100		

