 


Project Title  
**MAINE MEDICAL CENTER  
HVAC, LAB  
RENOVATIONS**  
PORTLAND, MAINE

HA Project No. 08101

Key Plan



Mark	Date	Description
-	10-31-08	ISSUED FOR BID
-	10-10-08	75% REVIEW


Issue Dates

Drawing Status

Drawing Title  
**ELECTRICAL  
RISER DIAGRAM AND  
CONDUIT ROUTING PLAN**


PA / PE: WRH Drawn By: RJB

Drawing Number  
**E20.0**

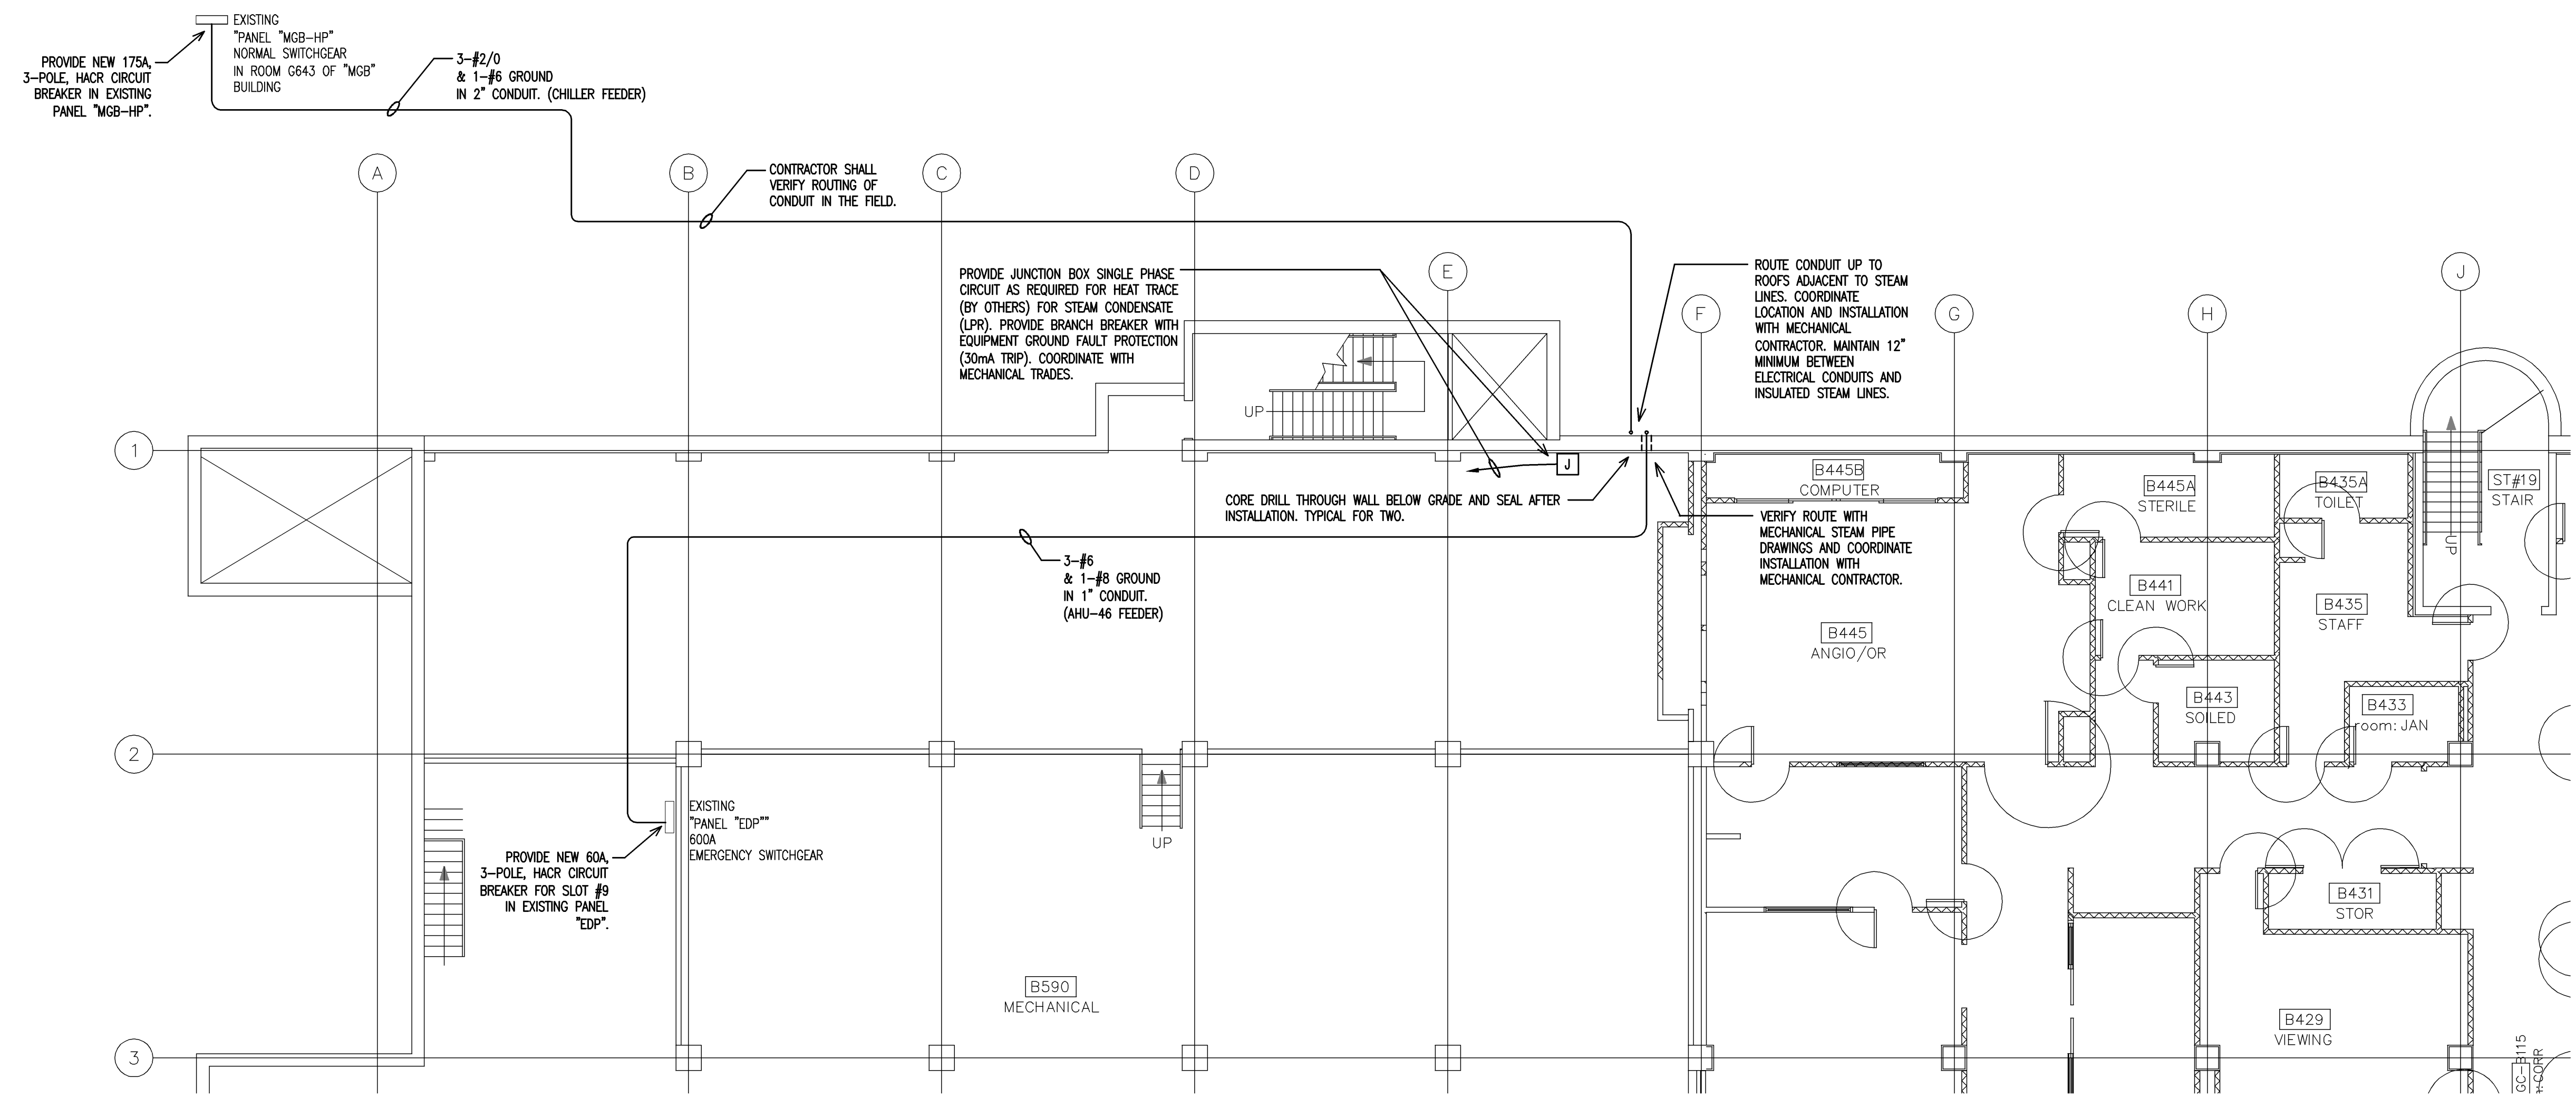

**PROPOSED CONDUIT ROUTING GROUND FLOOR PLAN**  
Scale: 1/8" = 1'-0"

- GENERAL NOTES**
1. COORDINATE ALL WORK WITH OTHER TRADES.
  2. COORDINATE WITH PHASING OF PROJECT.

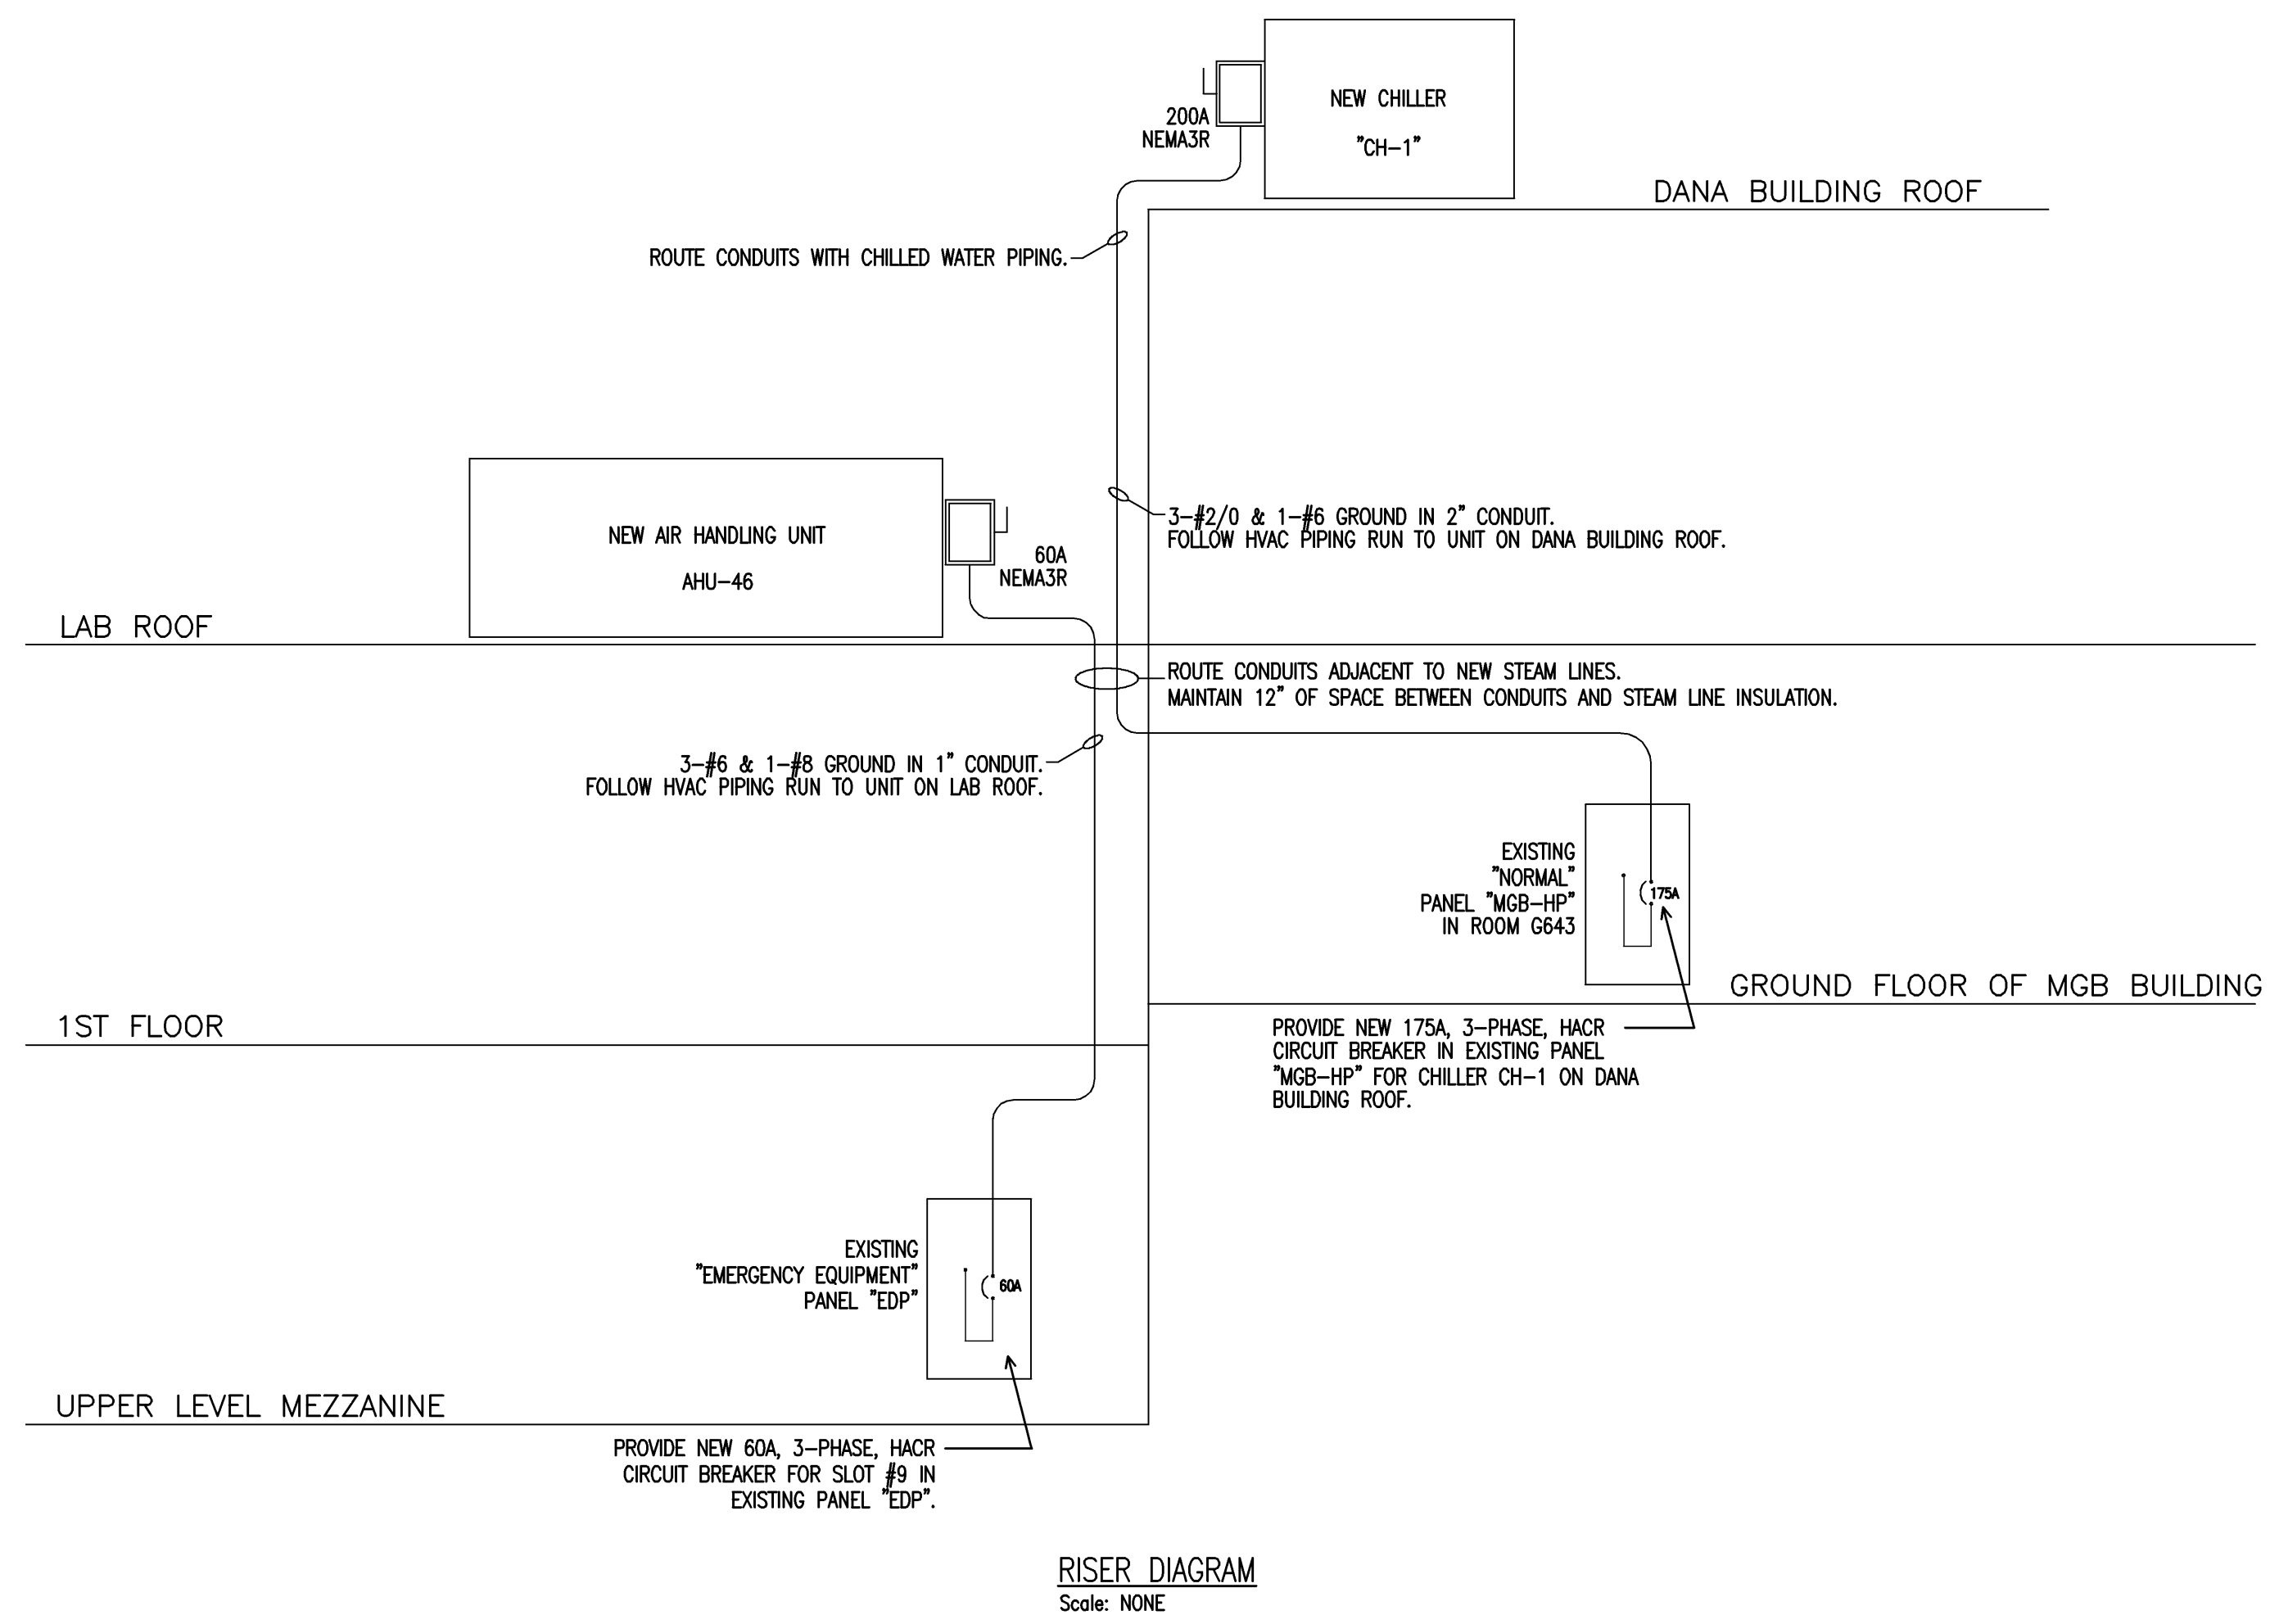

**RISER DIAGRAM**  
Scale: NONE