



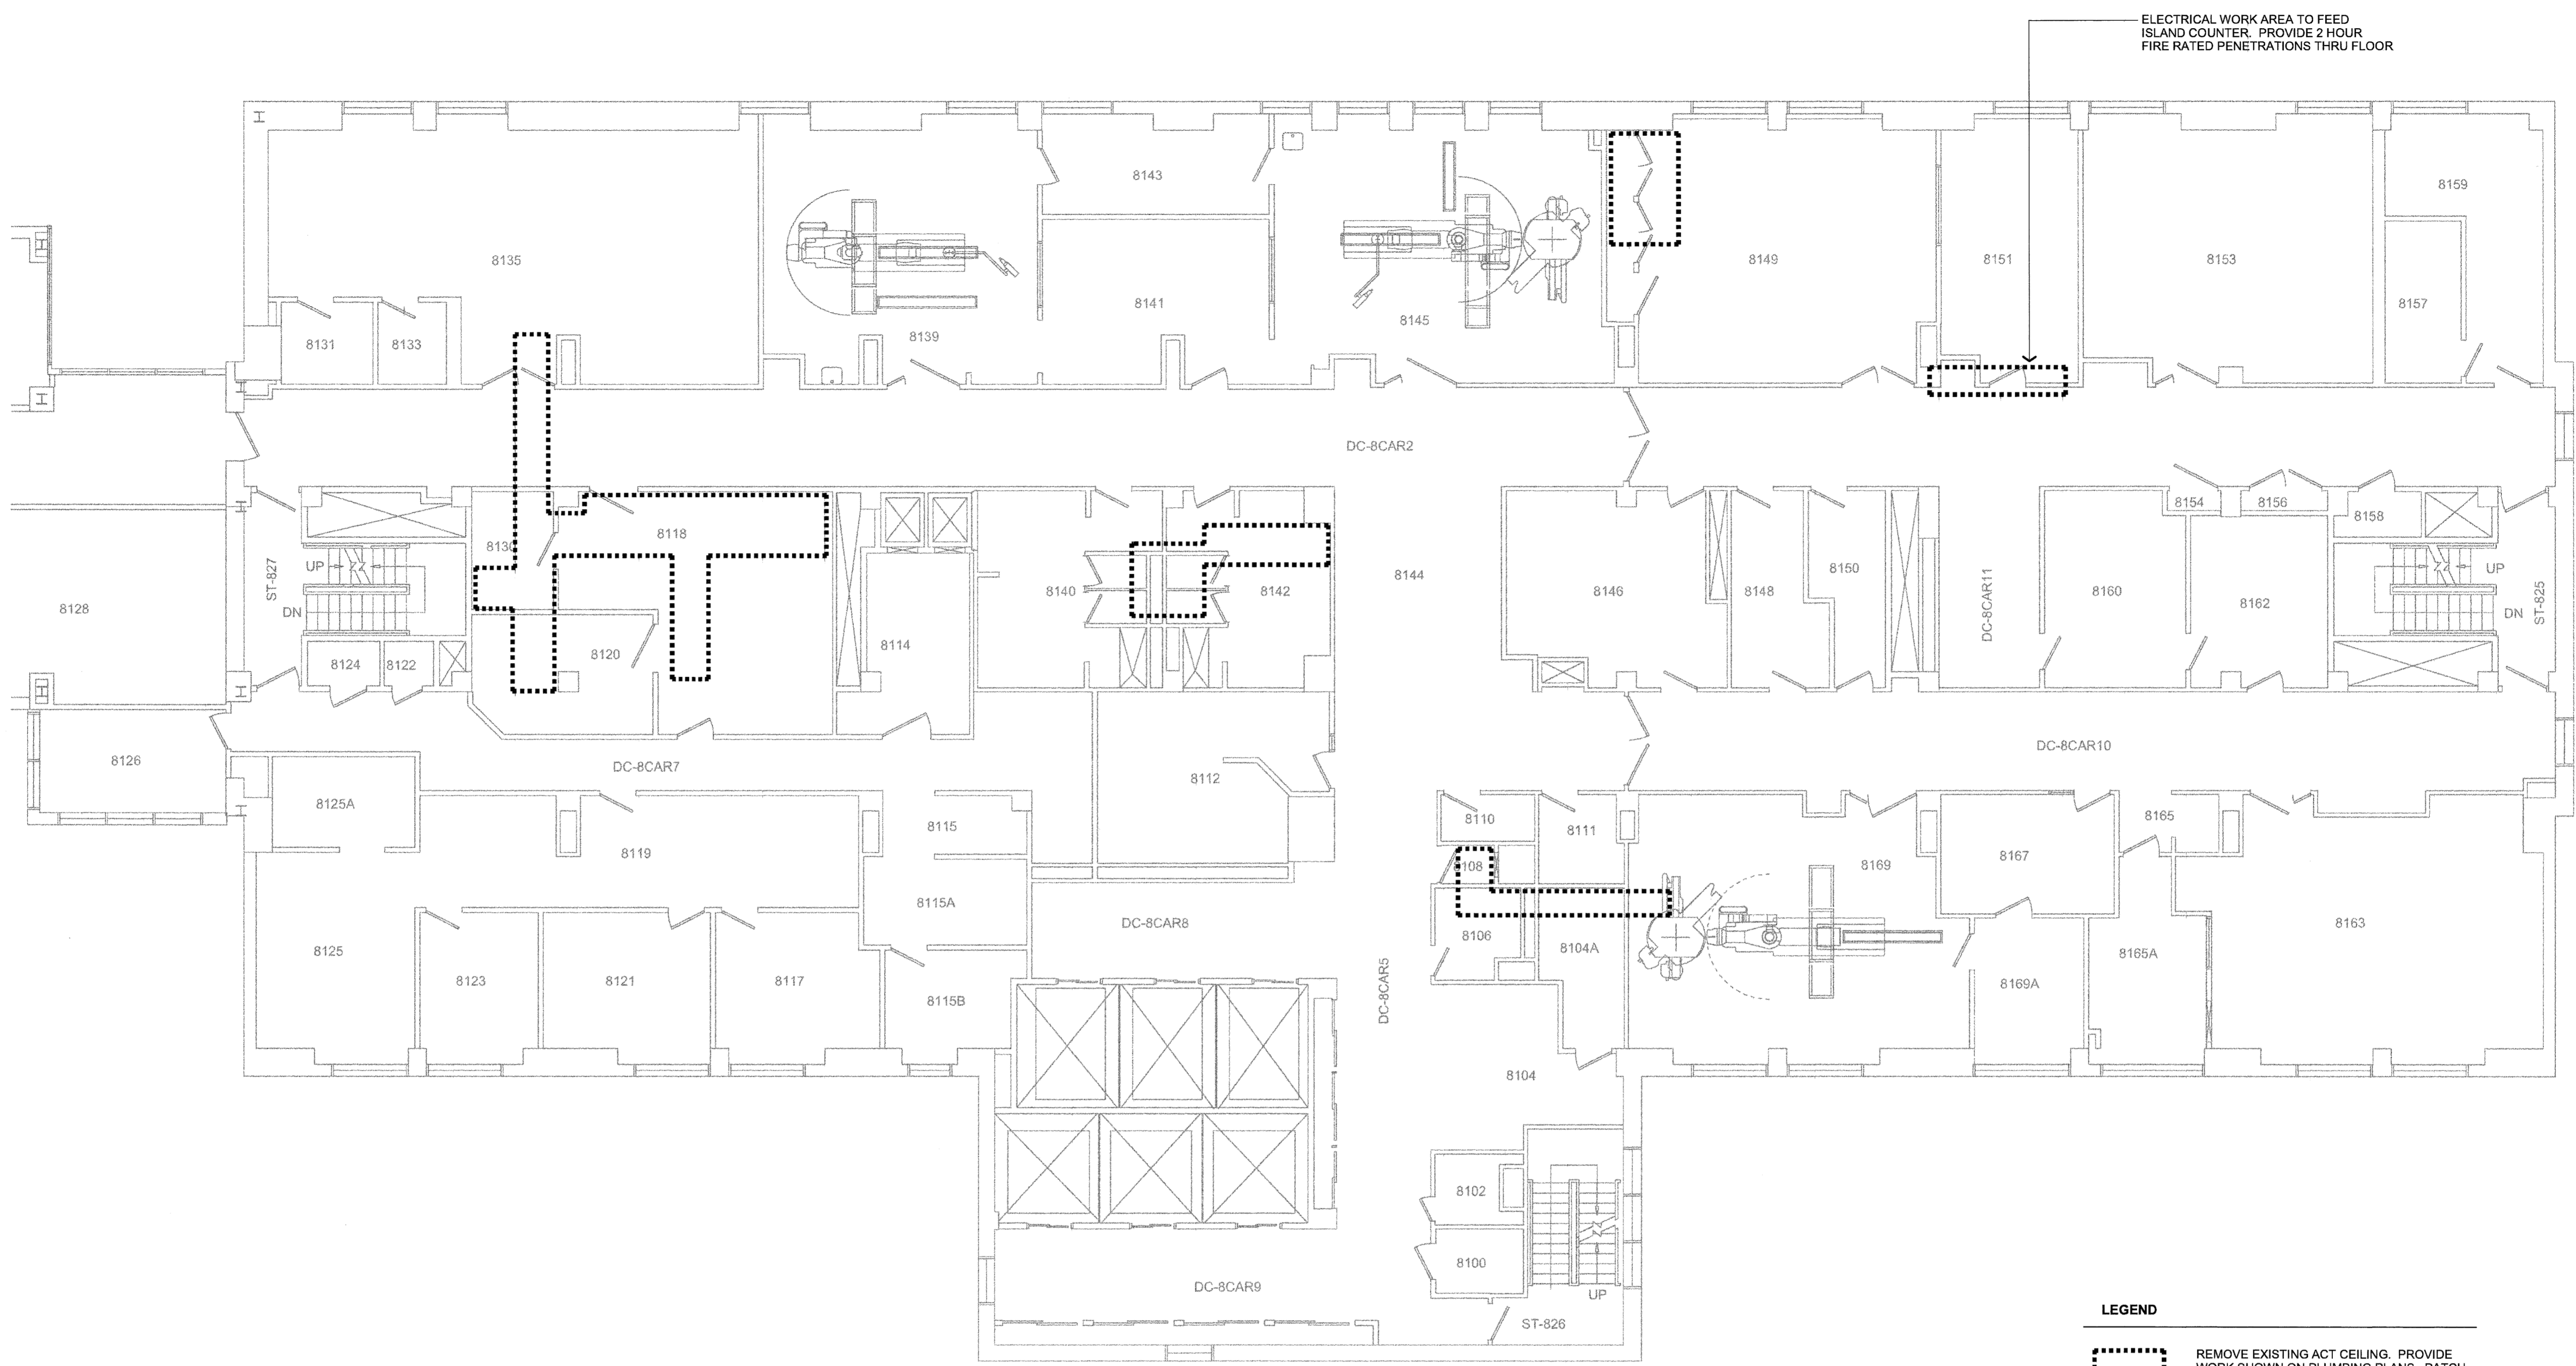

Mark M. Wilcox

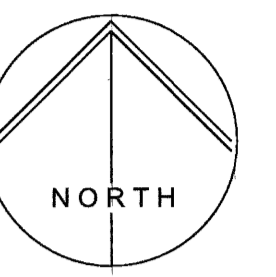

LEGEND
[Dashed line symbol] REMOVE EXISTING ACT CEILING. PROVIDE WORK SHOWN ON PLUMBING PLANS. PATCH CEILING TO MATCH EXISTING. WORK SHALL BE DONE AT NIGHT OR ON WEEKENDS.

**Richards Wing
Ninth Floor**

Renovations

Maine Medical Center
Portland, Maine 04102

Architect
Winton Scott Architects
Portland, Maine

Mechanical Engineering
Mechanical Systems Engineers
Yarmouth, Maine

Electrical Engineering
Swiftcurrent Engineering Services
Yarmouth, Maine

**Eighth
Floor Plan
A 1.2**

Scale: 1/8" = 1' - 0"

March 16, 2009