



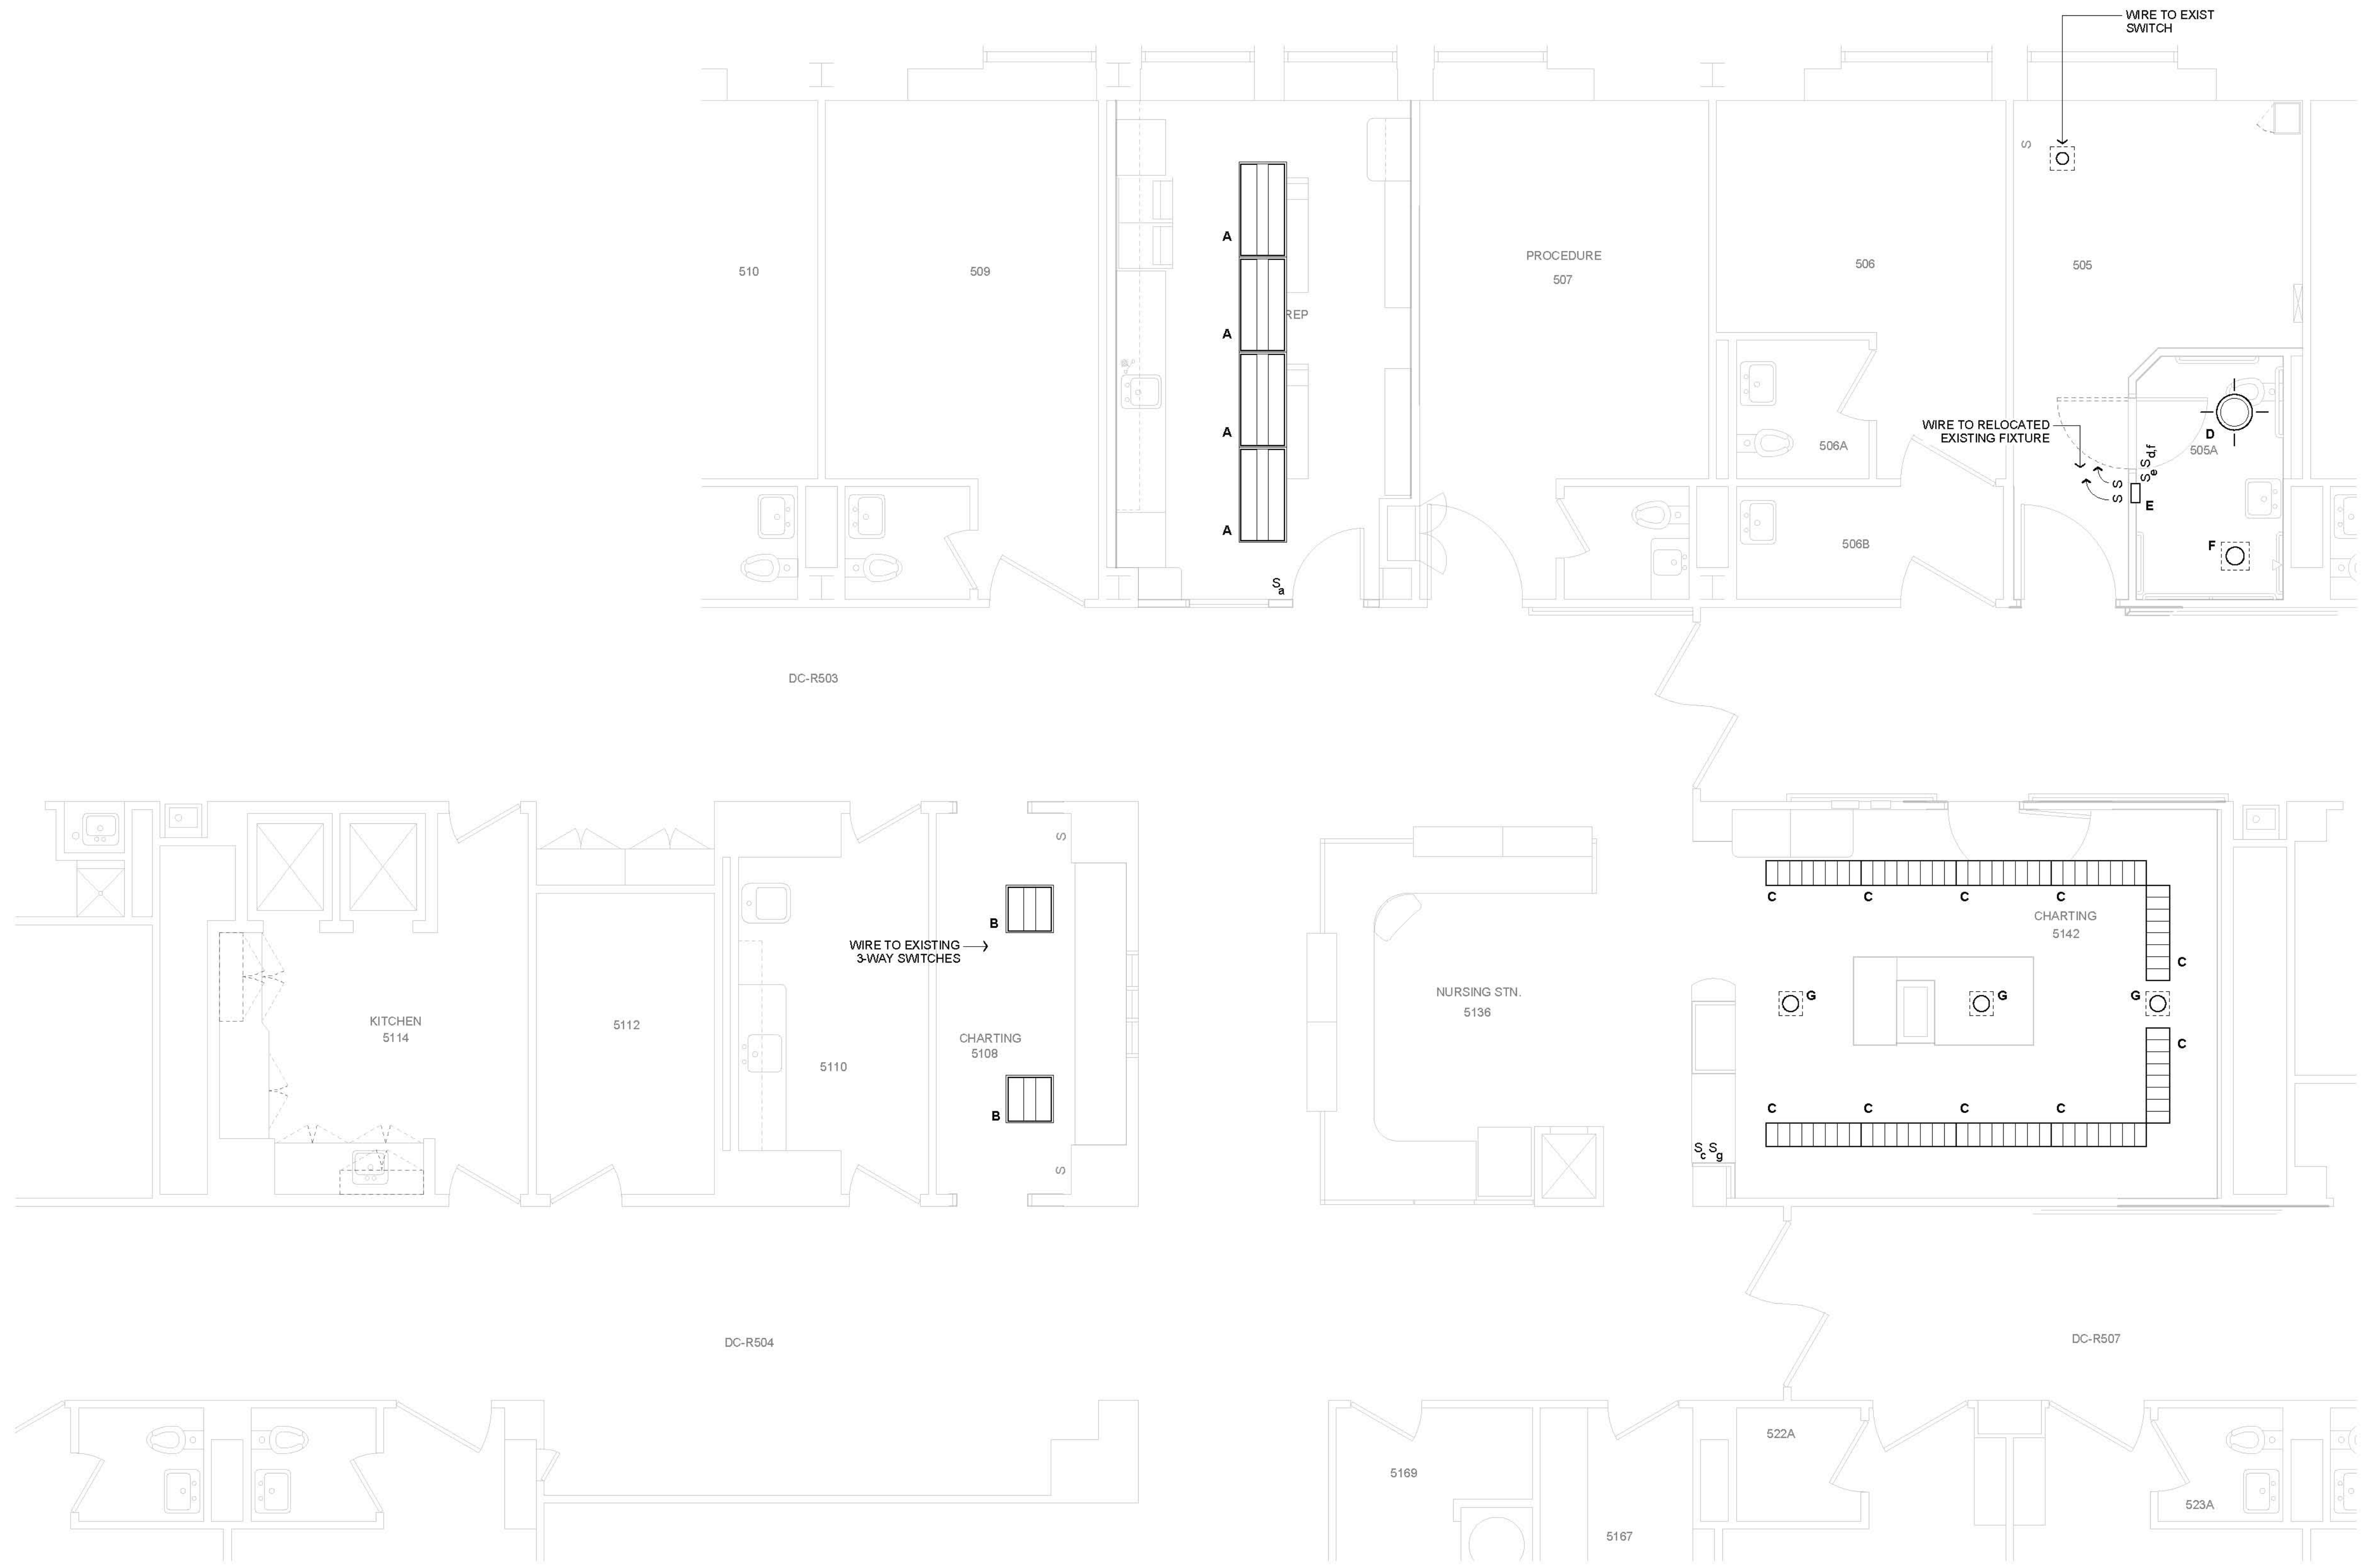

Mark M. Wilcox

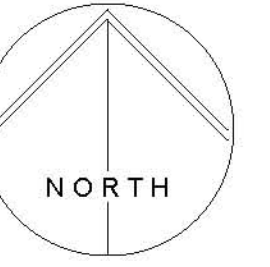

Lighting Fixture Schedule

	Manufacturer	Model No.	Mounting	Lamping	Remarks
A	LIGHTOLIER	QV52GPFV332 120 HI	RECESSED	(3) 32W T8	2 X 4 DIRECT - INDIRECT WITH DOWNLIGHT
B	LIGHTOLIER	QV52GPFOS2FT 120 HI	RECESSED	(2) 40W TT	2 X 2 DIRECT - INDIRECT
C	LIGHTOLIER	VRS1G8LS232 120 HI	RECESSED	(3) 32W T8	1 X 4 PARABOLIC
D	SPI ADVENT	AIC1060 2F26 120 BAL SBA	SURFACE	(2) 28W CF	18" DIA CEILING LIGHT
E	KENALL	MSL S 0 MW 2 RL 120 1	RECESSED	RED LED	PATIENT NIGHT LIGHT
F	LIGHTOLIER	8069WMH / 8242HCUV3	RECESSED	(2) 28W CF	SHOWER LIGHT
G	LIGHTOLIER	8037CTBW / S71428 U	RECESSED	(2) 28W CF	DOWNLIGHT

Richards Wing

Fifth Floor

Renovations

Maine Medical Center
Portland, Maine 04102

Architect
Winton Scott Architects, PA
Portland, Maine

Mechanical Design / Build
Johnson & Jordan
Portland, Maine

Electrical Lighting Plan

E 3.1

Scale: 1/4" = 1' - 0"

August 28, 2009