

CONSULTANTS

Epilepsy Reading Room
 Richards Building
 6th Floor


MARK DATE DESCRIPTION

ISSUE: For Permit
 PROJECT NO: ----
 CAD DWG FILE: unknown
 DRAWN BY: MP
 CHECKED BY: DD

SHEET TITLE

Floor Plan

Sheet **A-1** of 1

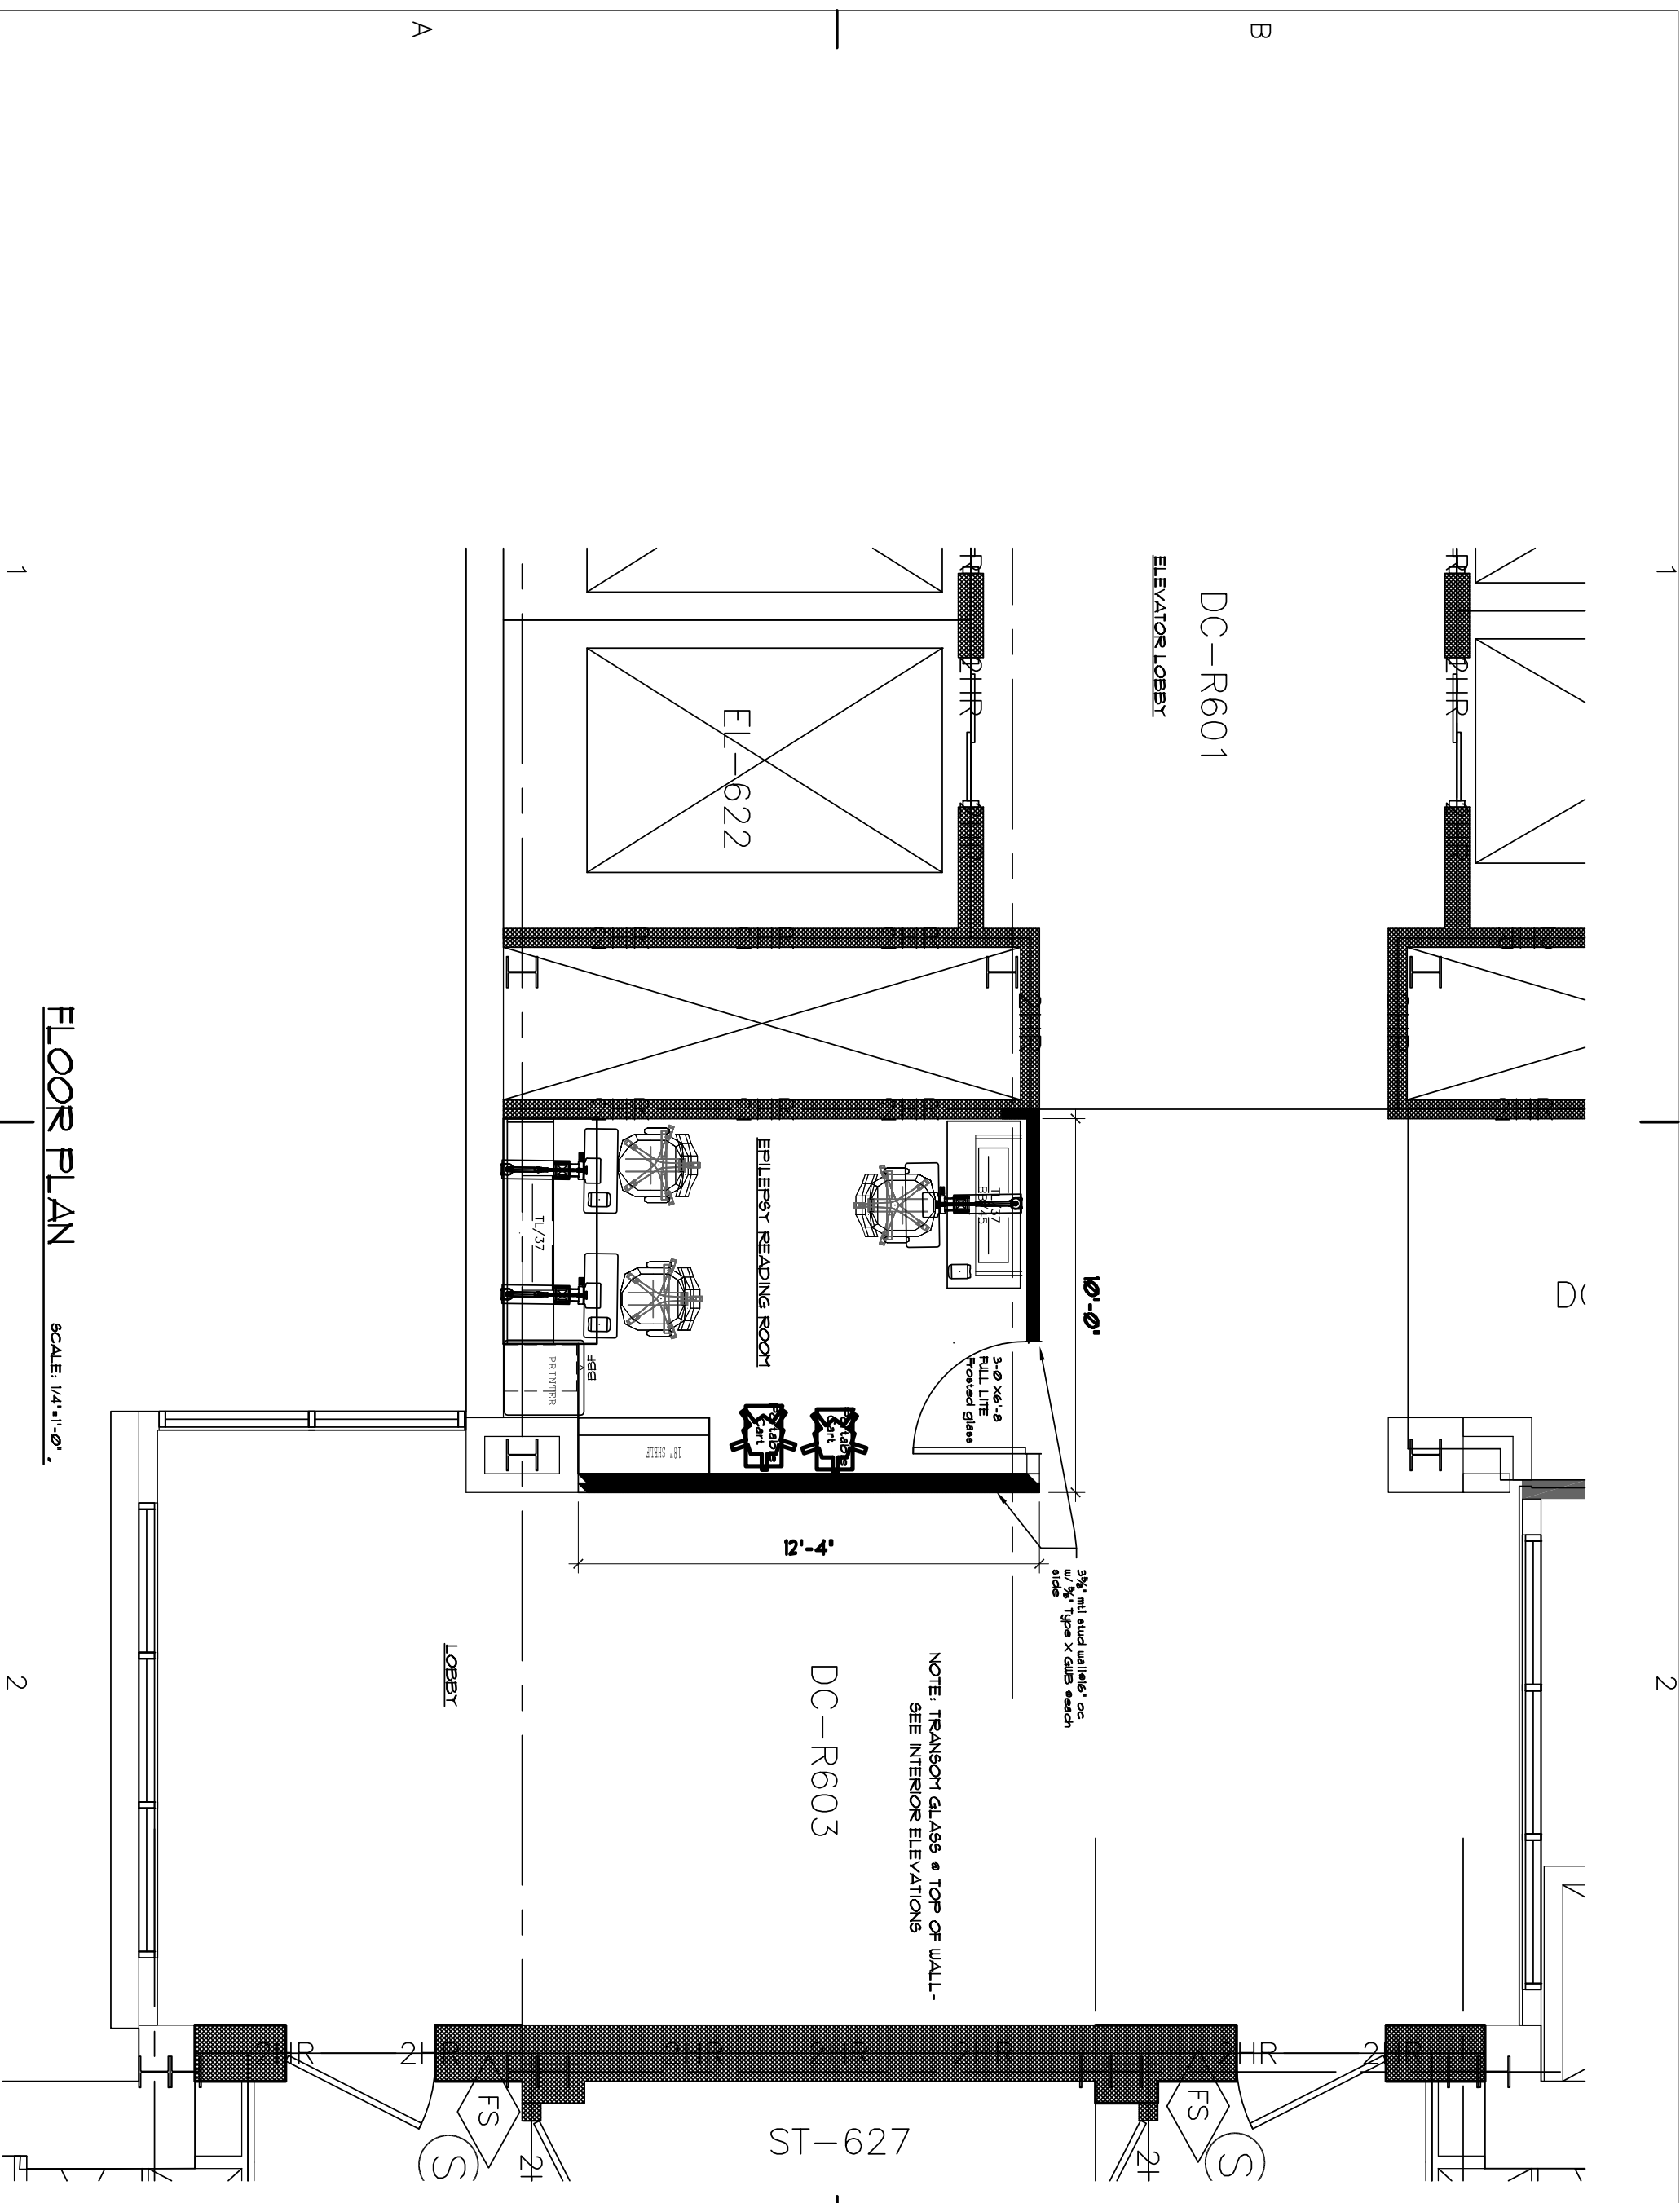

FLOOR PLAN

SCALE: 1/4"=1'-0"