



2 BASEMENT REFLECTED CEILING PLAN  
1/4" = 1'-0"

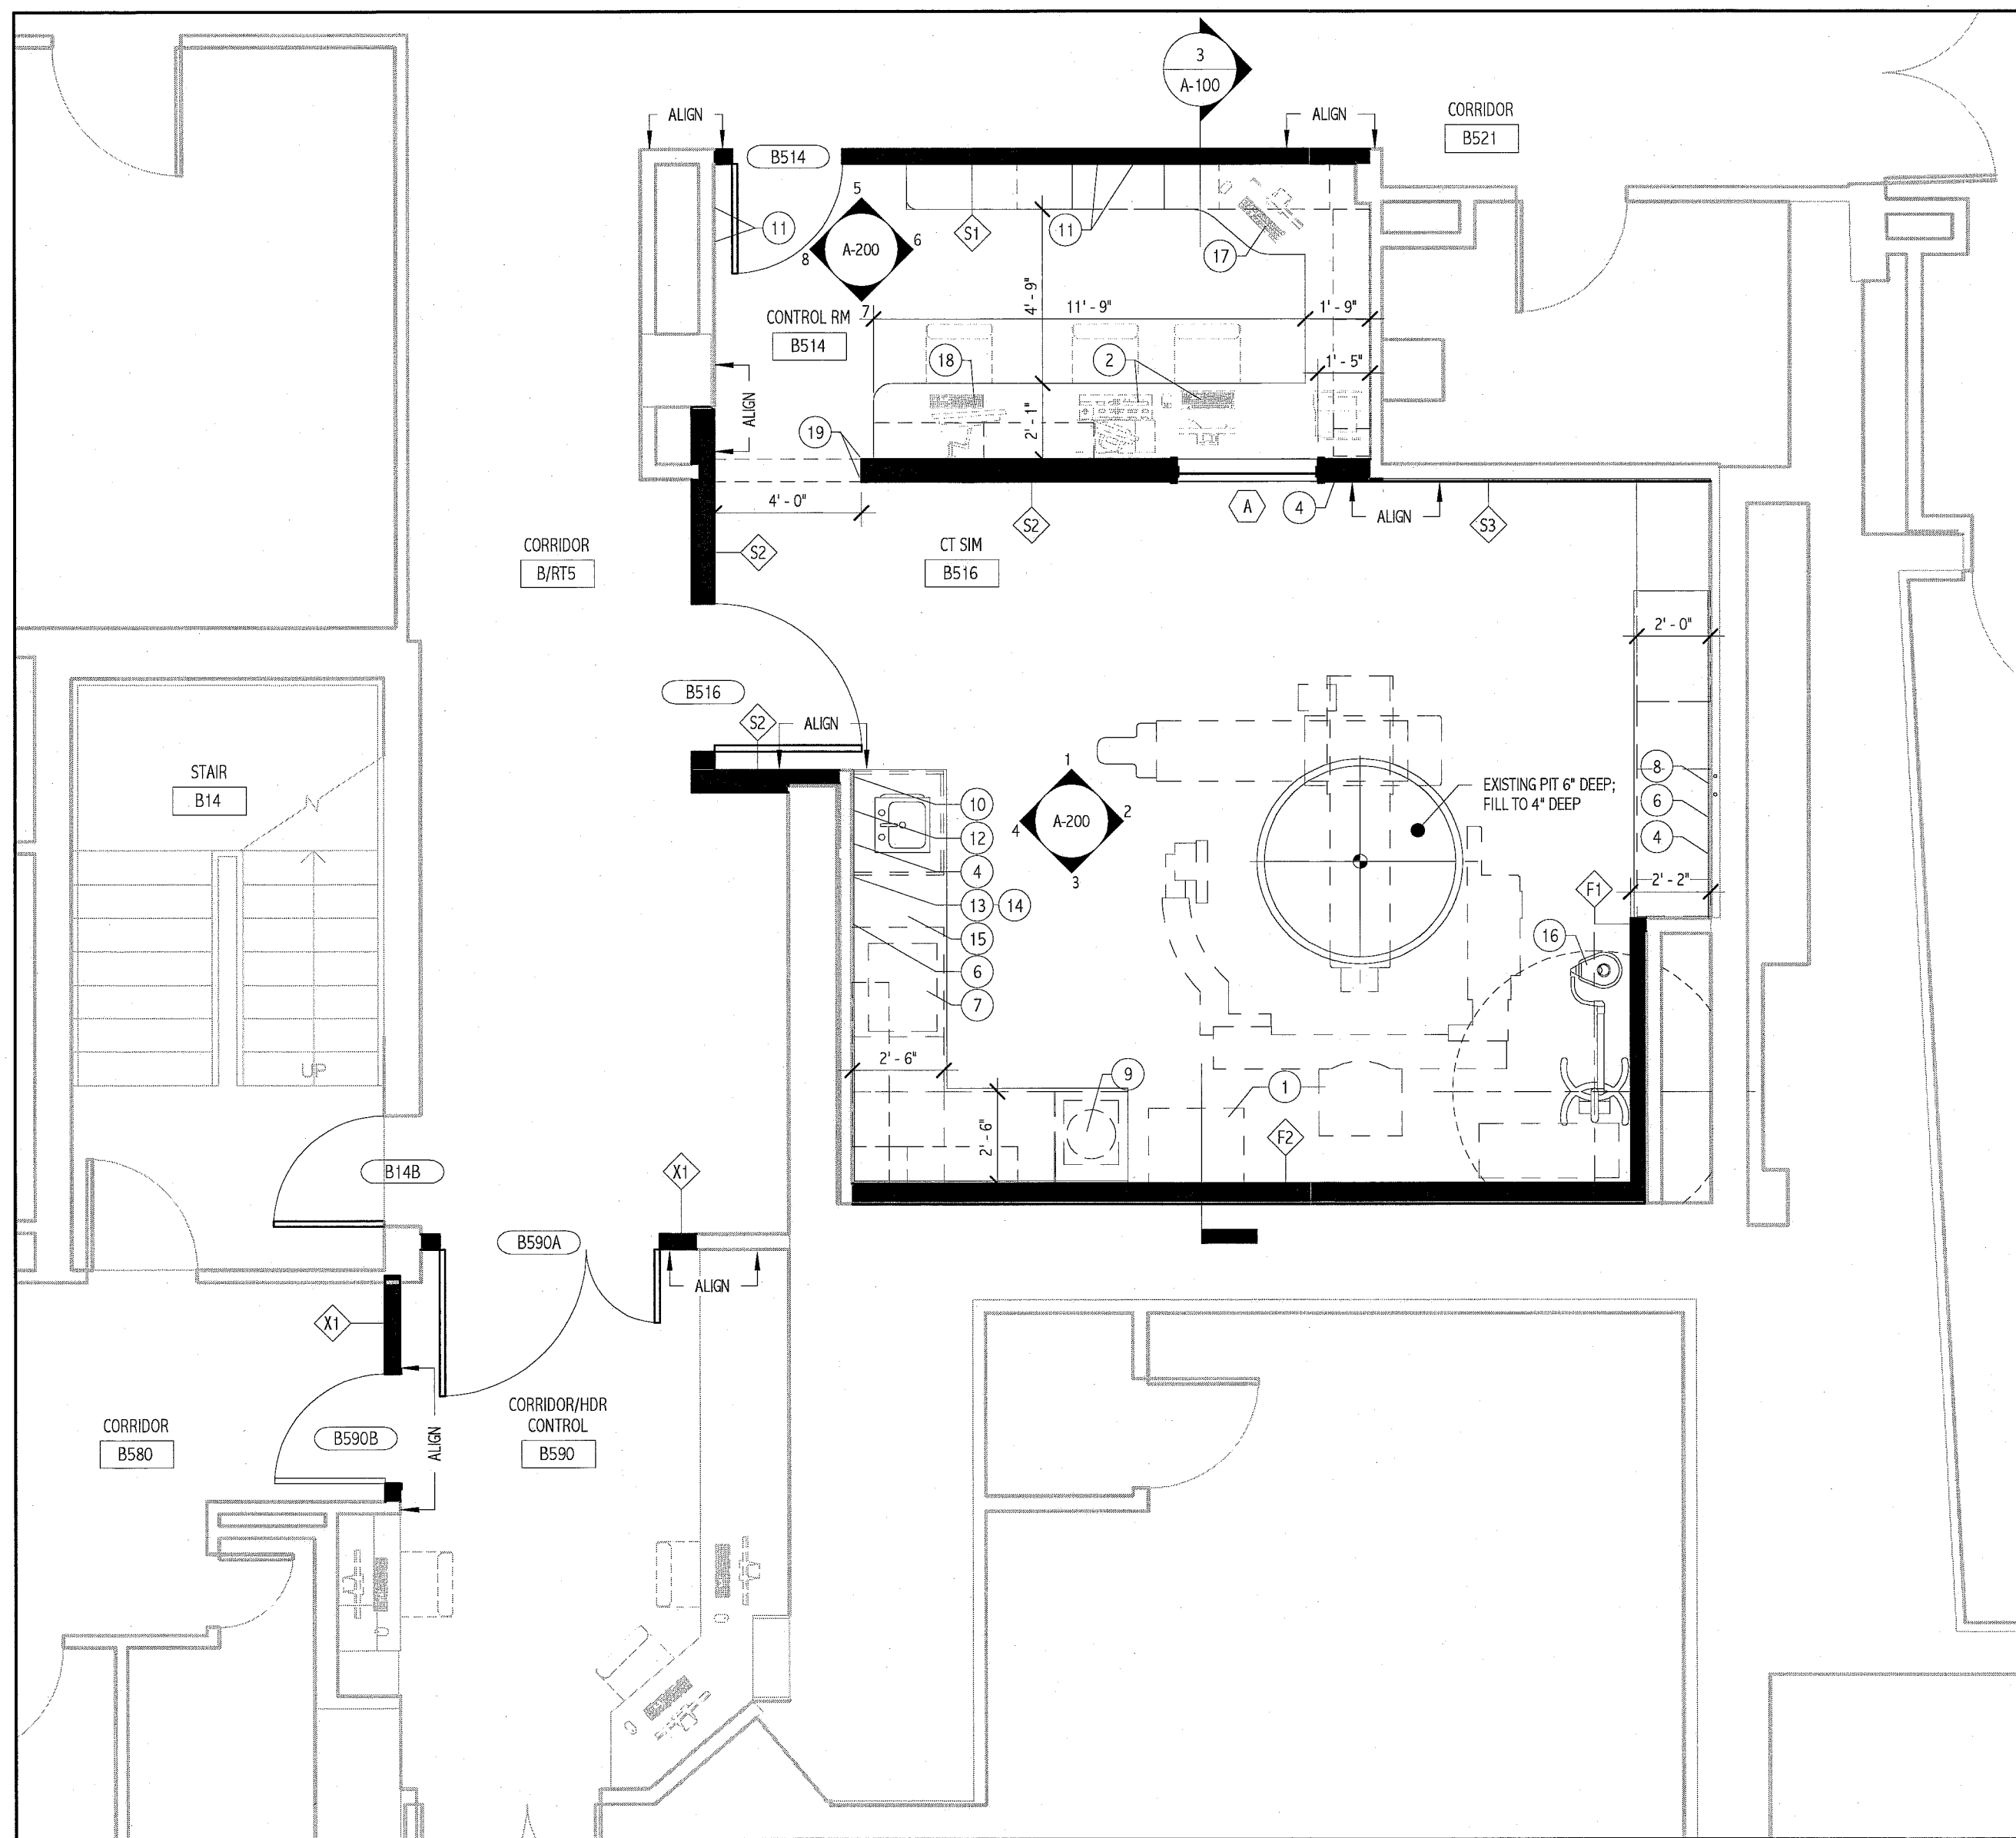

1 BASEMENT FLOOR PLAN  
1/4" = 1'-0"

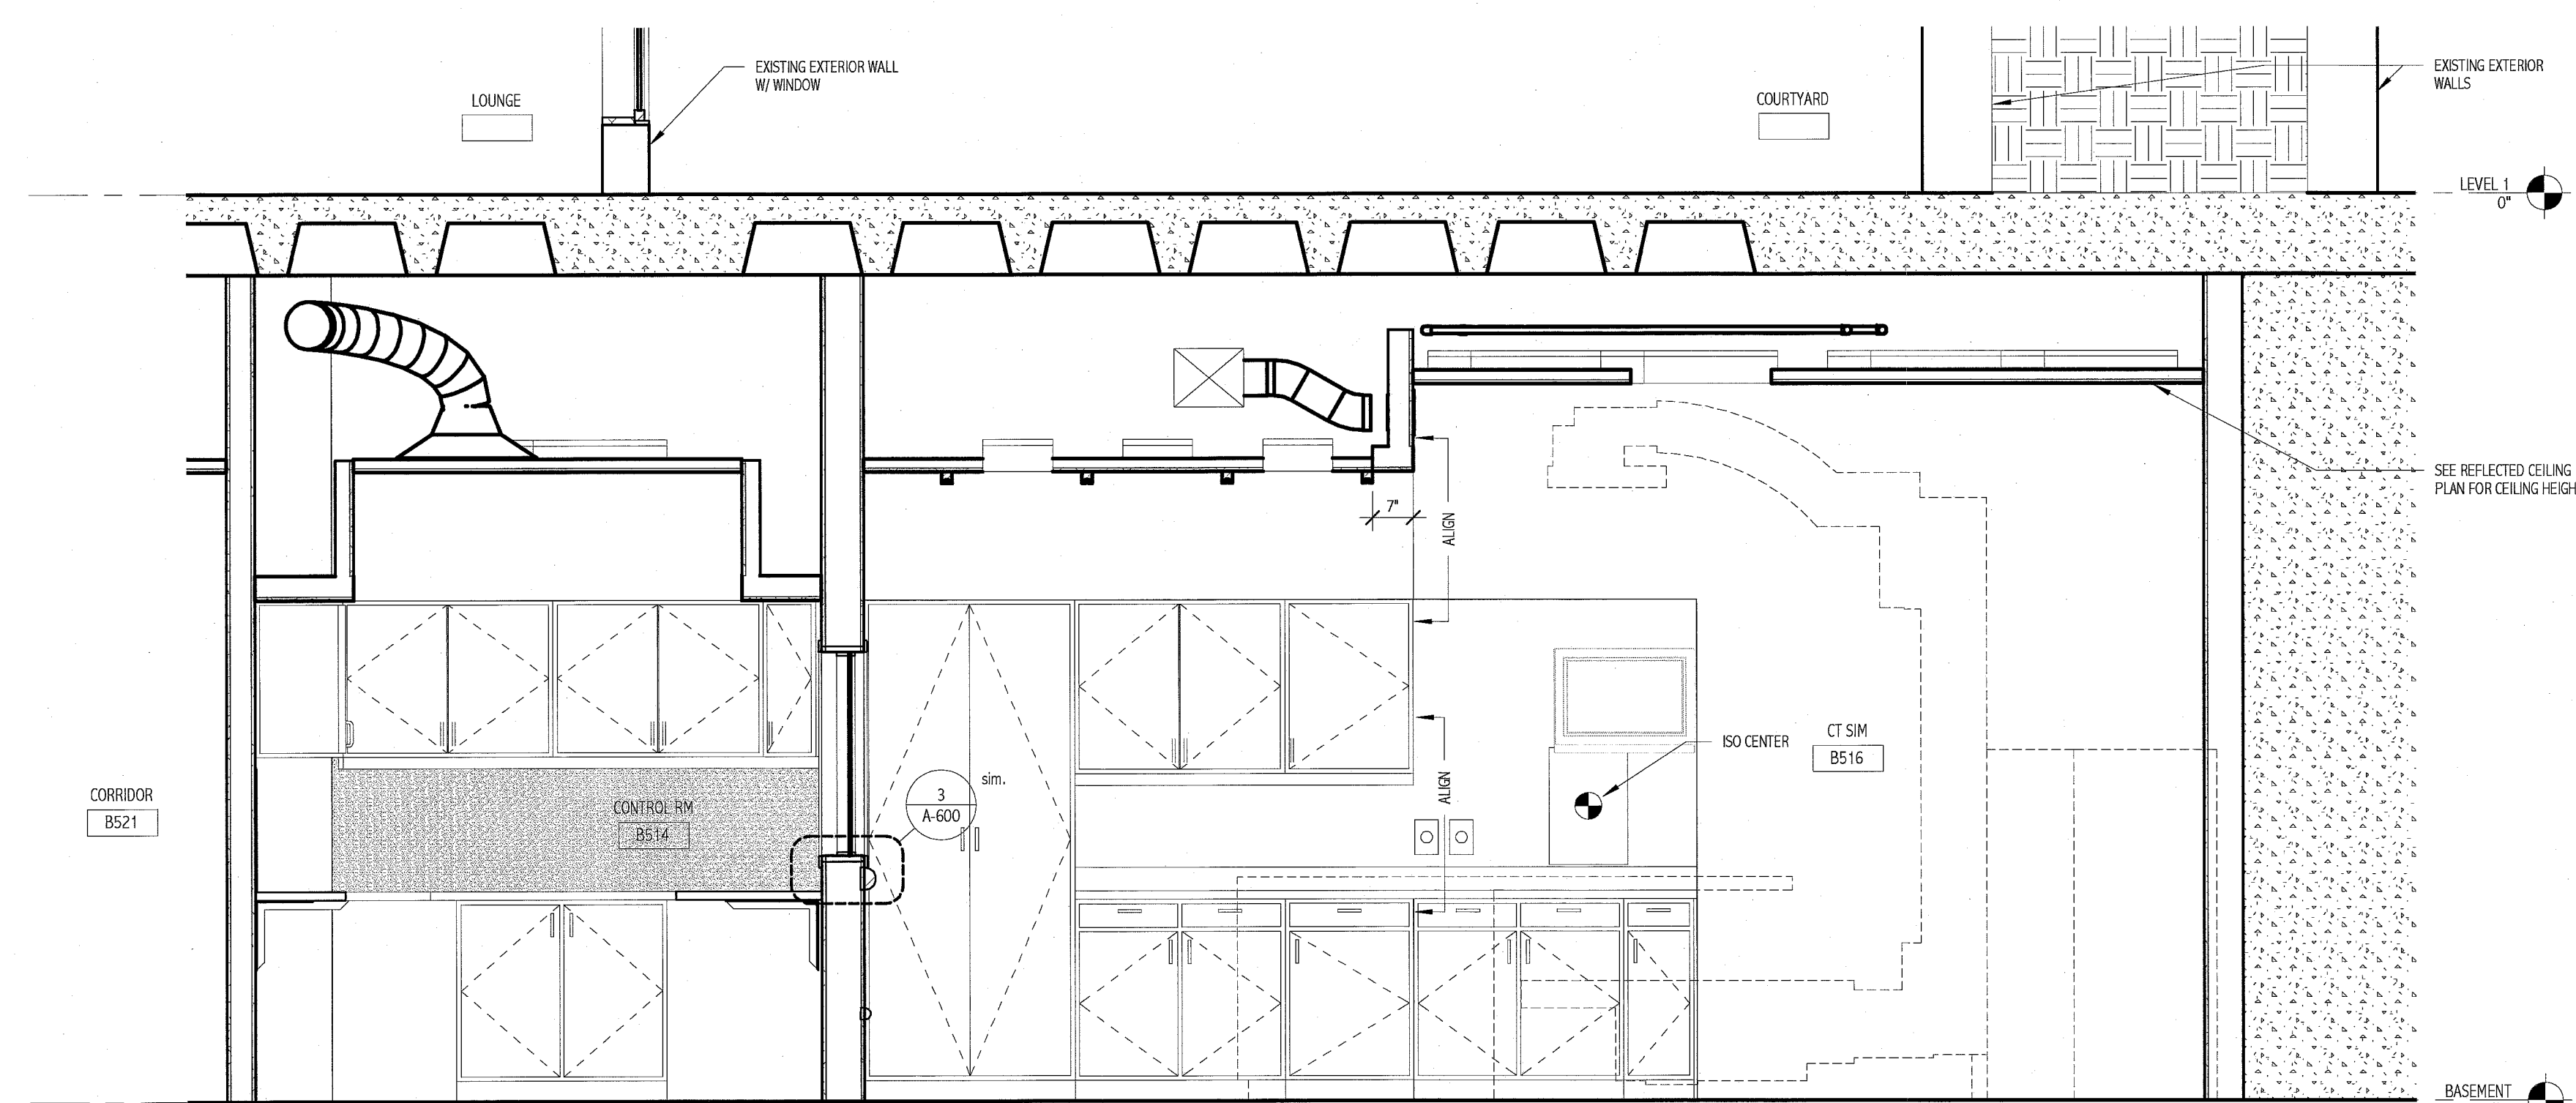

3 SECTION CT SIM  
1/2" = 1'-0"

**PLAN NOTES:**

- REFER TO G-001 FOR PROJECT GENERAL NOTES, ABBREVIATIONS AND SYMBOLS LEGEND.
- EXISTING INTERIOR PARTITIONS TO REMAIN EXCEPT WHERE WORK REQUIRES CUTTING, PATCHING, AND FINISHING OF WALL TO ACCOMMODATE UTILITY LOCATION.

**REFLECTED CEILING NOTES:**

- FIRE SPRINKLERS SHALL BE LOCATED IN ALIGNMENT WITH OTHER CEILING ITEMS, TYPICALLY.
- FIRE SPRINKLERS SHALL BE CENTERED IN CEILING TILE.
- FIRE SPRINKLERS SHALL BE PLACED TO COORDINATE WITH LIGHT FIXTURE POSITIONS INDICATED.
- ALIGN CEILING ITEMS AS SHOWN, WITH COMMON CENTERLINES TYPICALLY. CENTER ITEMS IN CEILINGS, OR IN AREAS UNLESS INDICATED OTHERWISE.
- REFER TO ROOM FINISH SCHEDULE FOR CEILING HEIGHTS AND CEILING FINISHES TO BE PROVIDED.
- EXCEPT WHERE INDICATED, CENTER CEILING GRIDS IN ROOMS.
- PROVIDE ACCESS PANELS AS REQUIRED IN GWB CEILINGS FOR ACCESS TO MECHANICAL VALVES/CONTROLS. REFERENCE MECHANICAL DRAWINGS.

**SYMBOLS LEGEND:**

- CEILING GRID ONLY (SDG-1)
- 2x2 SUSPENDED CEILING PANEL AND GRID ASSEMBLY
- GWB CEILING
- 2x2 LAY-IN LIGHT FIXTURE
- 2x4 LAY-IN LIGHT FIXTURE
- 1x4 LIGHT FIXTURE
- FLUORESCENT STRIP FIXTURE
- DOWN LIGHT
- CEILING MOUNTED EXIT LIGHT
- RADIANT PANEL
- RETURN AIR GRILLE
- SUPPLY AIR GRILLE
- EXHAUST AIR GRILLE
- SPRINKLER HEAD
- CEILING MOUNTED SPEAKER
- CEILING MOUNTED SMOKE DETECTOR
- CUBICLE CURTAIN AND TRACK
- PENDANT LIGHT FIXTURE
- LINEAR DIFFUSER
- CLOSED CIRCUIT CAMERA
- CONTROL JOINT

144 Lee Street, Box 618  
Portland, Maine 04104  
Tel: (207) 772-9846  
Fax: (207) 772-1079  
www.smrtinc.com

ARCHITECTURE  
ENGINEERING  
PLANNING  
INTERIOR DESIGN  
COMMISSIONING

**SMRT**

LICENSED ARCHITECT  
DEREK J. VEILLEUX  
No. 3492  
STATE OF MAINE  
2-9-10

PROJECT NORTH

CT SIMULATOR REPLACEMENT  
RE-ISSUED FOR CONSTRUCTION  
02.09.10

NO.	DATE	DESCRIPTION
1	02.09.10	RE-ISSUED FOR CONSTRUCTION
0	01.20.10	ISSUED FOR CONSTRUCTION
0		
0		

GRAPHIC SCALE:  
0" 1"

SCALE: As Indicated

PROJECT MANAGER: DIV  
DRAWN BY: CS  
A/E OF RECORD: DIV  
PROJECT NO.: 09122  
DATE: 01.20.10

SHEET TITLE:  
**BASEMENT FLOOR PLAN, REFLECTED CEILING PLAN, & SECTION**

SHEET No. A-100