


NOTES:

- SEE SHEET E-001 FOR LEGEND AND GENERAL NOTES.
- SEE SHEET EP101 FOR LOCATION OF PANELBOARD SP1.

KEYED NOTES:

- NEW LIGHTS TO BE REFEED FROM THE EXISTING BRANCH CIRCUIT THAT FED LIGHTS SHOWN TO BE REMOVED ON ED101. PROVIDE NEW SWITCHING AS INDICATED.
- RELOCATED LIGHT SWITCHES FOR CORRIDOR B/R/T'S. SEE SHEET ED101 FOR CURRENT SWITCH LOCATIONS. EXTEND EXISTING WIRING AS REQUIRED TO ACCOMMODATE NEW SWITCH LOCATIONS.
- SECOND THREE-WAY SWITCH IS INTEGRAL WITH SIMULATOR ELECTRONICS CABINET. COORDINATE WIRING REQUIREMENTS WITH NUCLETRON EQUIPMENT INSTALLER.
- NEW EXIT SIGN TO BE CONNECTED TO EXISTING UNSWITCHED EMERGENCY LIGHTING CIRCUIT FOR CORRIDOR B/R/T'S.



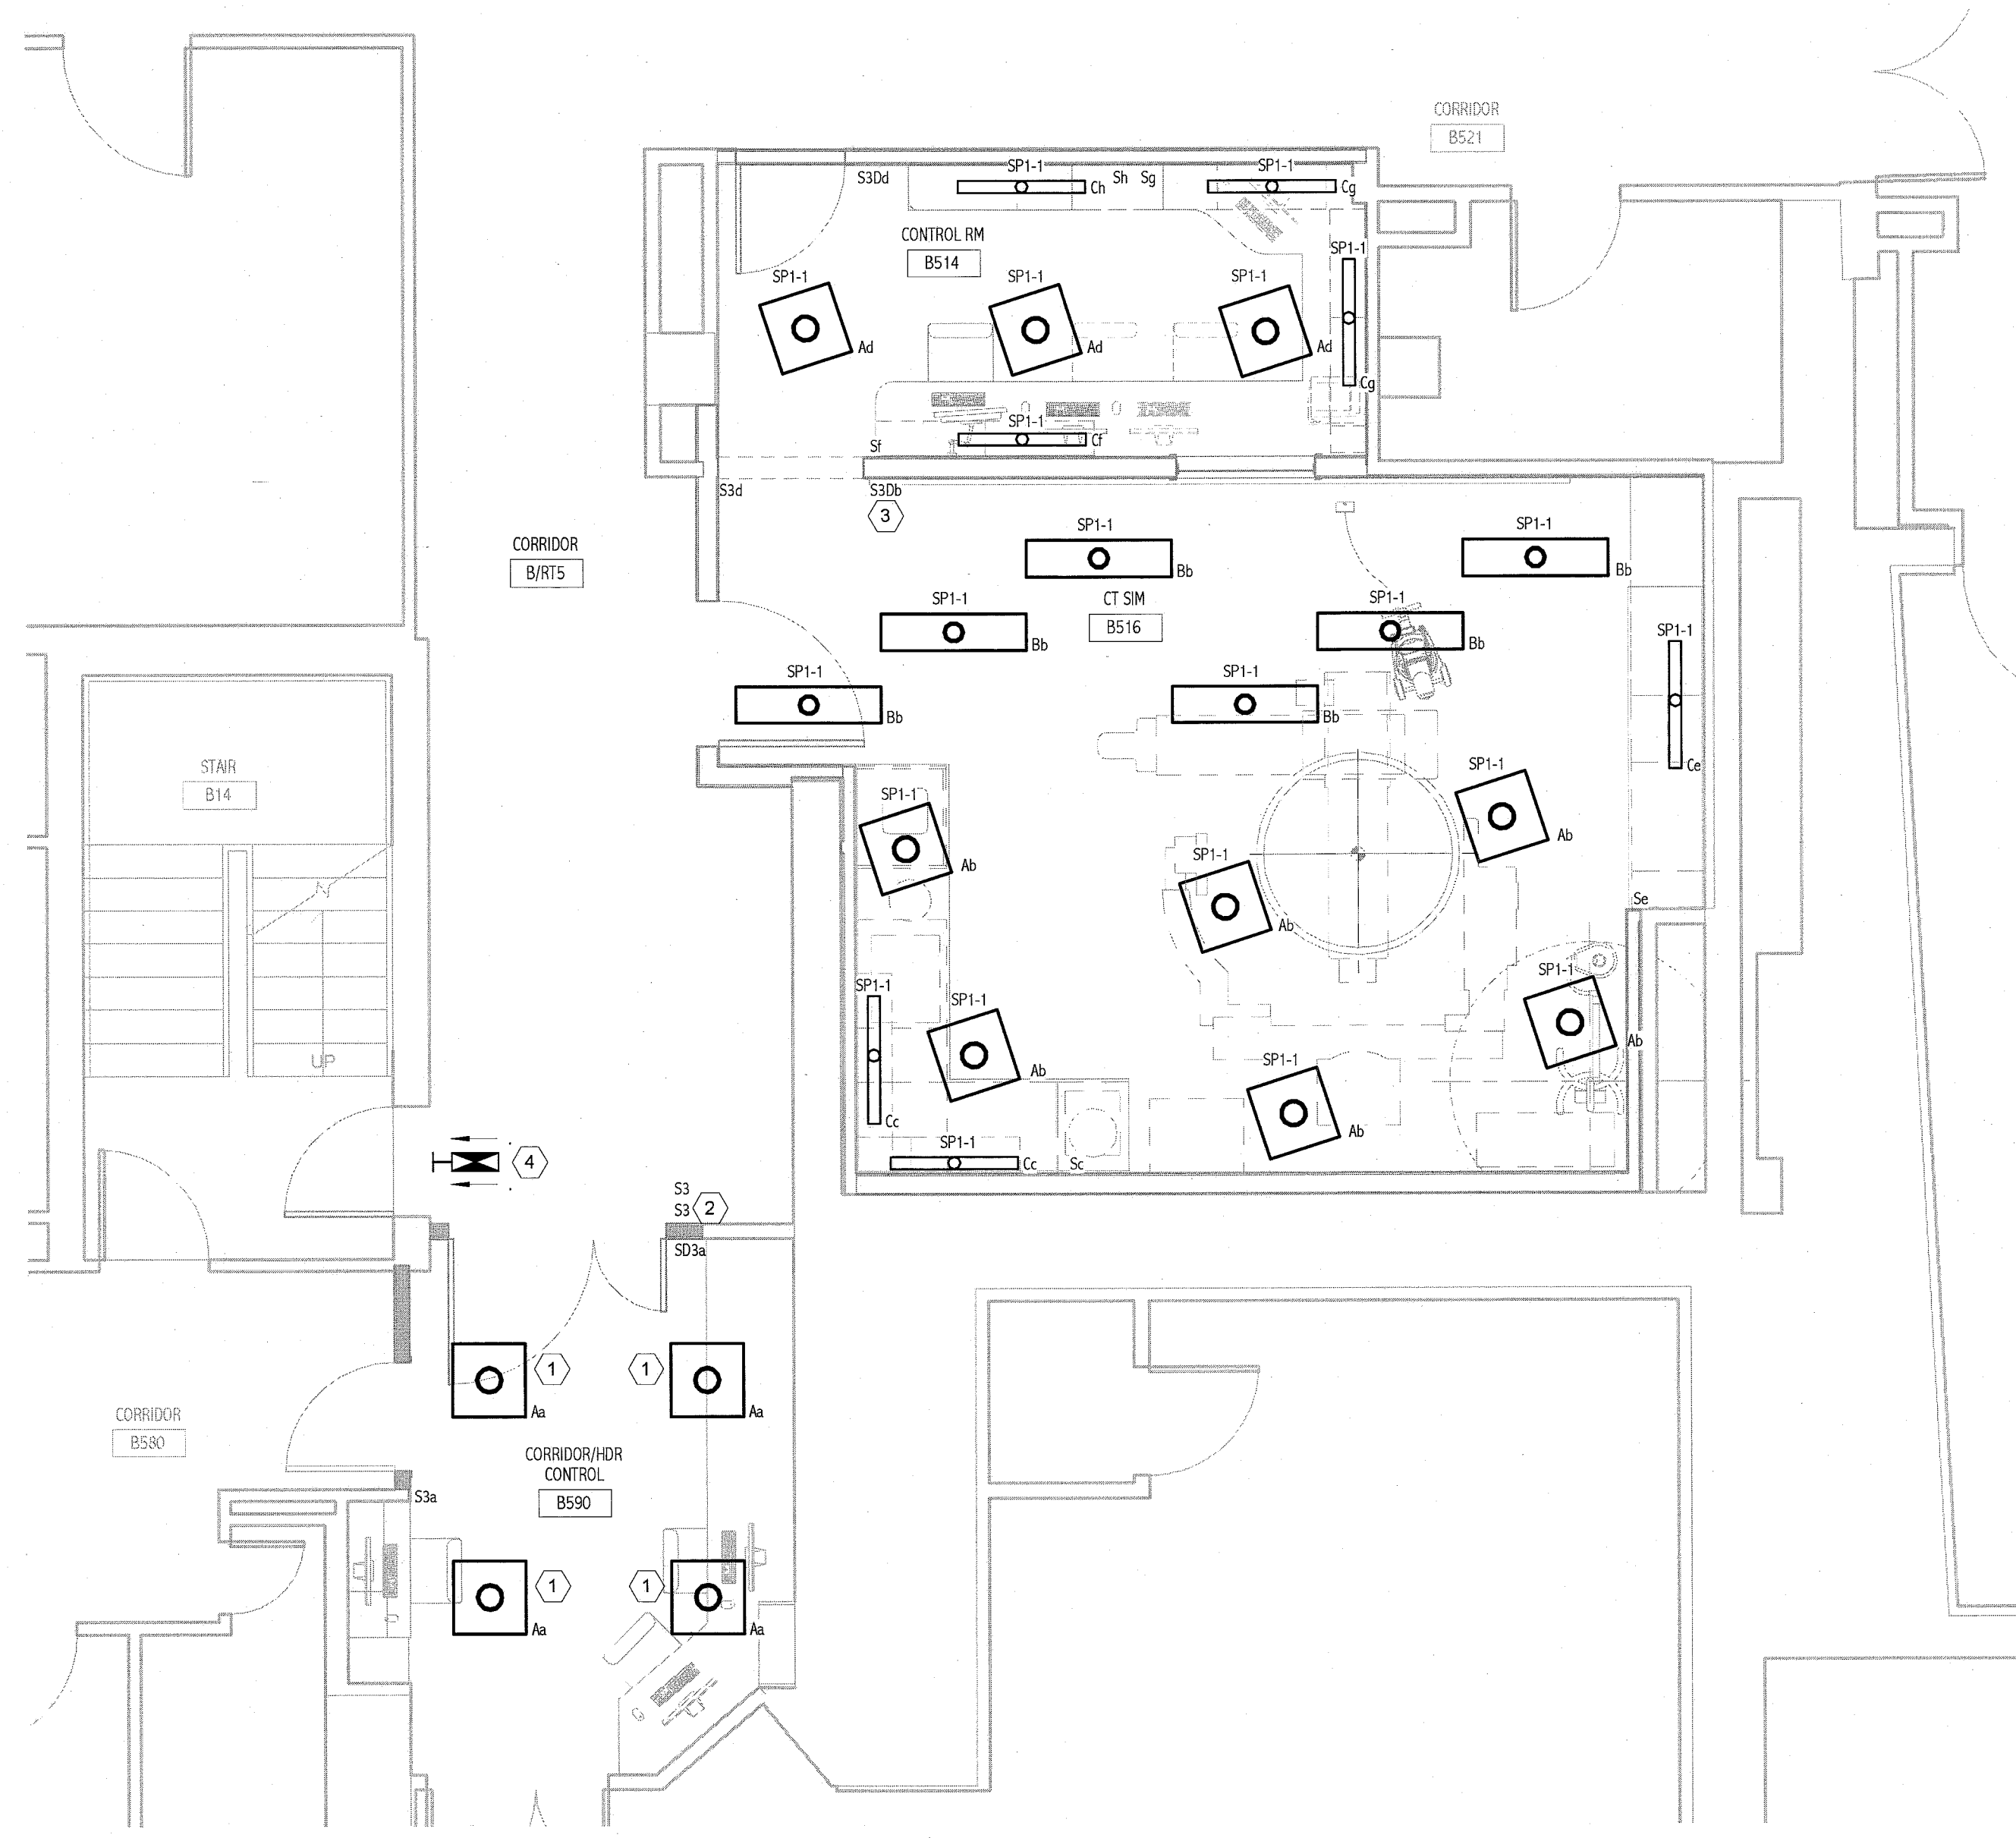


1 LIGHTING BASEMENT FLOOR PLAN
1/4" = 1'-0"

LIGHT FIXTURE SCHEDULE					
TYPE	DESCRIPTION	MFR.	LAMPS	MOUNTING	NOTES
A	2x2 DIRECT/INDIRECT W/ WHITE REFLECTOR WITH METAL PERFORATED OVERLAY. 120/277V	COLUMBIA STR22 SERIES OR EQUAL	3-F1 T78 3500K	CEILING RECESSED	PROVIDE WITH DIMMING BALLASTS CAPABLE OF DIMMING TO 2% OF RATED OUTPUT.
B	3" NARROW SLOT LINEAR FIXTURE W/ FLUSH FROSTED LENS. 120/277V	FOCAL POINT FA90-FL SERIES OR EQUAL	1-F54T5HD 3500K	CEILING RECESSED	PROVIDE WITH DIMMING BALLASTS CAPABLE OF DIMMING TO 2% OF RATED OUTPUT.
C	42" LOW PROFILE UNDER CABINET LIGHT. 120V	COLUMBIA UCS SERIES OR EQUAL	1-F1 3T5 3500K	UNDER CABINET	
IN USE	"IN USE" INDICATING LIGHT WITH RED LETTERS ON WHITE FACE. 120V	ALCO EG SERIES OR EQUAL	2-25W INCANDESCENT	SURFACE WALL	
EXIT SIGN	EXIT SIGN WITH WHITE THERMOPLASTIC HOUSING AND RED LETTERS.	DUAL LITE LX SERIES	LED	SURFACE WALL	PROVIDE WITH BATTERY BACK-UP.

144 For Sheet P.O. Box 618
Portland, Maine 04104
Tel: (207) 772-8846
Fax: (207) 772-1070
www.smartinc.com

ARCHITECTURE
ENGINEERING
PLANNING
INTERIOR DESIGN
COMMISSIONING

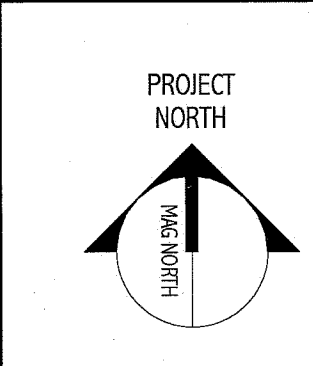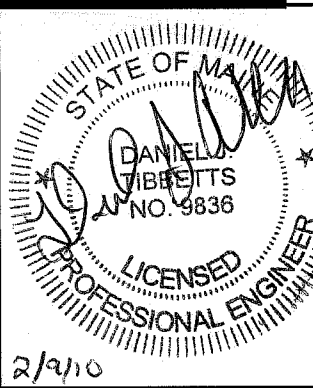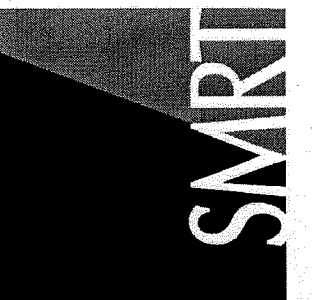

CT SIMULATOR REPLACEMENT
RE-ISSUED FOR CONSTRUCTION
02.09.10

NO.	DATE	DESCRIPTION
1	02/09/10	RE-ISSUED FOR CONSTRUCTION
0	01/20/10	ISSUED FOR CONSTRUCTION
0	REV	

GRAPHIC SCALE:
0" 1"

SCALE: 1/4" = 1'-0"
PROJECT MANAGER: DW
DRAWN BY: CDS
A/E OF RECORD: DT
PROJECT NO: 09122
DATE: 1-20-10

SHEET TITLE:
LIGHTING BASEMENT FLOOR PLAN

SHEET No. EL101