





GROUND FLOOR UPS ROOM PIPING PLAN
 ② 1/8" = 1'-0"

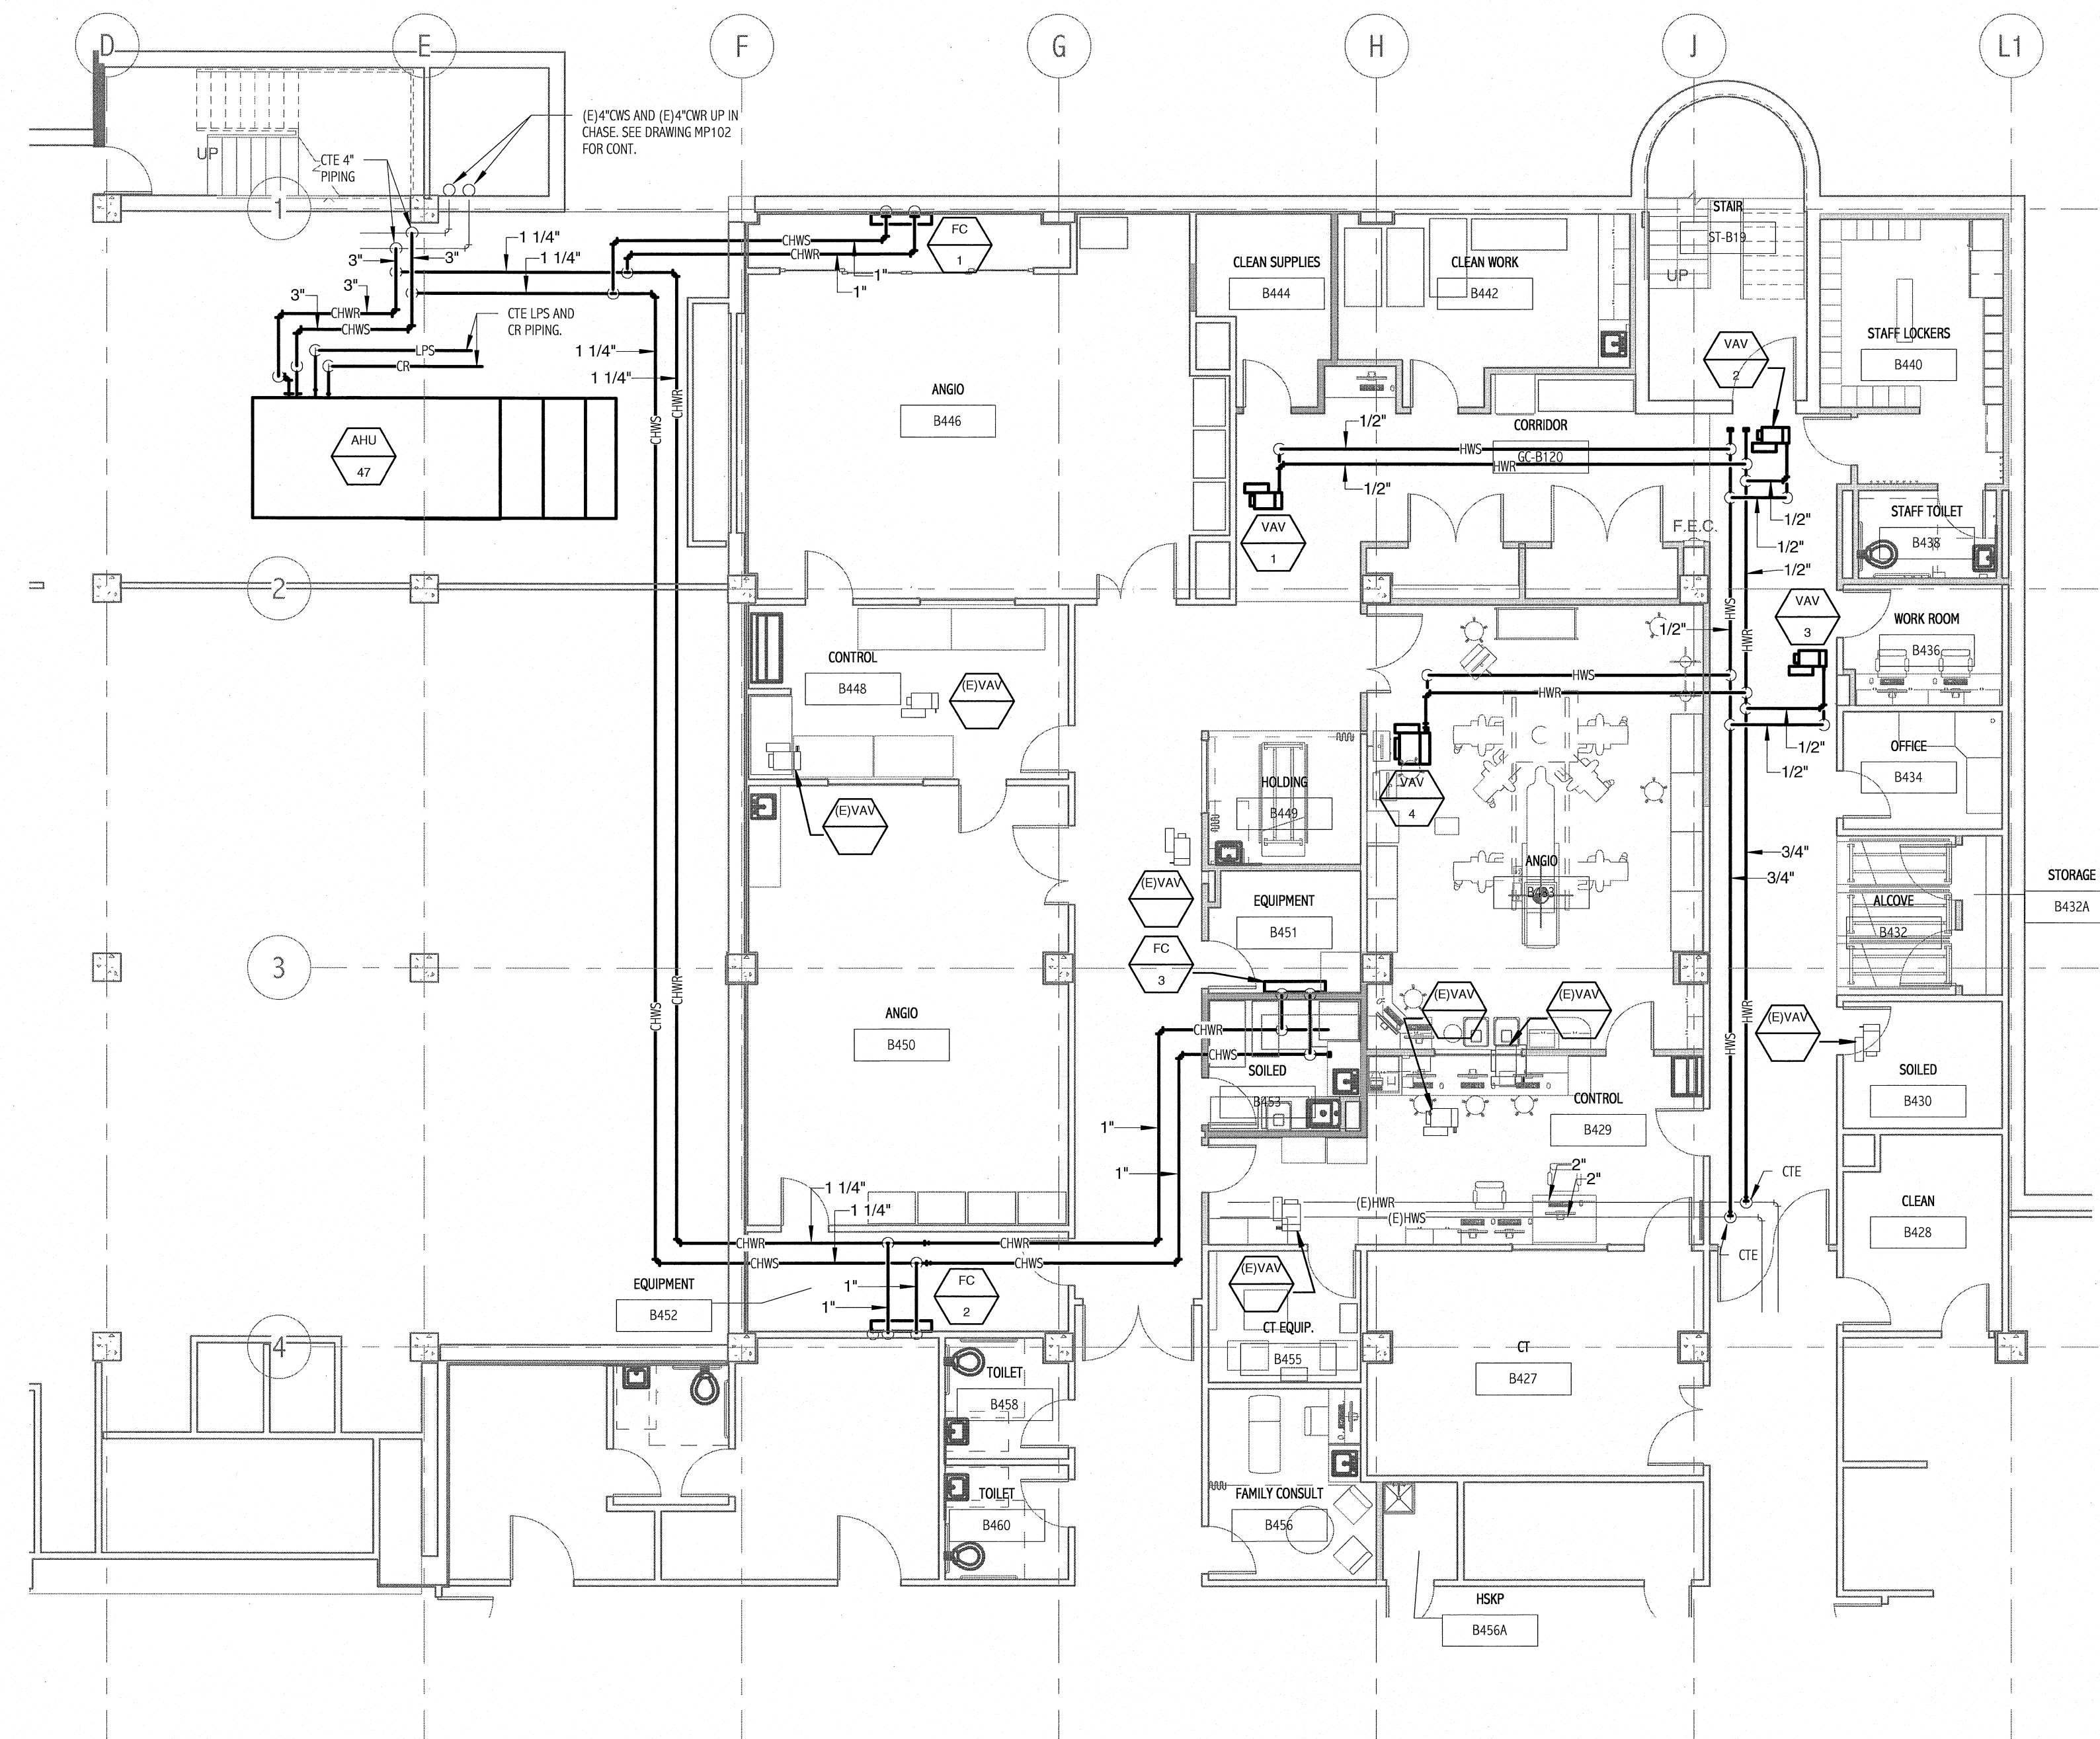

① ANGIO HVAC PIPING PLAN
 1/8" = 1'-0"

1441 Eric Street, P.O. Box 618
 Portland, Maine 04104
 Tel: (207) 772-3846
 Fax: (207) 772-1070
 www.smrtinc.com

ARCHITECTURE
 ENGINEERING
 PLANNING
 INTERIOR DESIGN
 COMMISSIONING

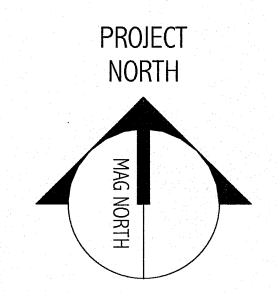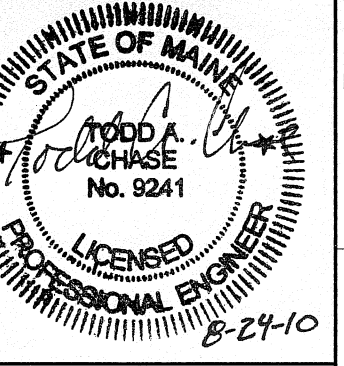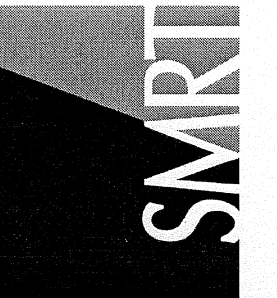

Bramhall Radiology
ANGIO RENOVATIONS
 PORTLAND, ME
 ISSUED FOR CONSTRUCTION
 08.24.10
 CURRENT ISSUE STATUS:

NO.	DESCRIPTION	DATE
0	ISSUED FOR CONSTRUCTION	8-24-10
1	REV	

GRAPHIC SCALE:
 0" 1"

SCALE: 1/8" = 1'-0"
 PROJECT MANAGER: DM
 DRAWN BY: KPB
 A/E OF RECORD: TAC
 PROJECT NO: 09022-01
 DATE: 08.24.10

SHEET TITLE:
ANGIO MECHANICAL PIPING PLAN

SHEET No.
MP101