
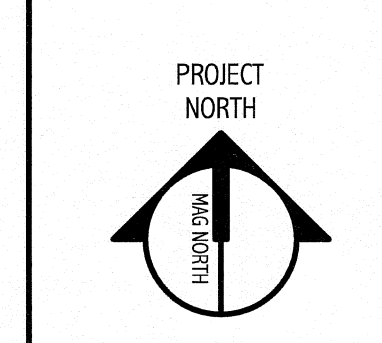


144 Fore Street, P.O. Box 618
 Portland, Maine 04104
 Tel: (207) 775-3846
 Fax: (207) 775-1070
 www.smartrc.com

ARCHITECTURE
 ENGINEERING
 PLANNING
 INTERIOR DESIGN
 COMMISSIONING

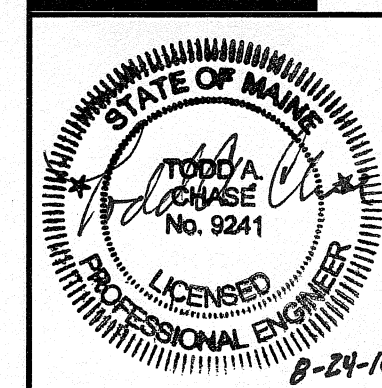

Bramhall Radiology
 ANGIO RENOVATIONS
 PORTLAND, ME

ISSUED FOR CONSTRUCTION
 8.24.10

CURRENT ISSUE STATUS:


REV	DESCRIPTION	DATE
0	ISSUED FOR CONSTRUCTION	8.24.10

GRAPHIC SCALE:
 0" 1"

SCALE: 1/8"=1'-0"
 PROJECT MANAGER: DIV
 JC/DRAWN BY: KPB
 A/E OF RECORD: TAC
 PROJECT NO: 09022-01
 DATE: 8.24.10

SHEET TITLE:
 ANGIO MECHANICAL
 PIPING PLAN ROOF

SHEET No.
 MP102

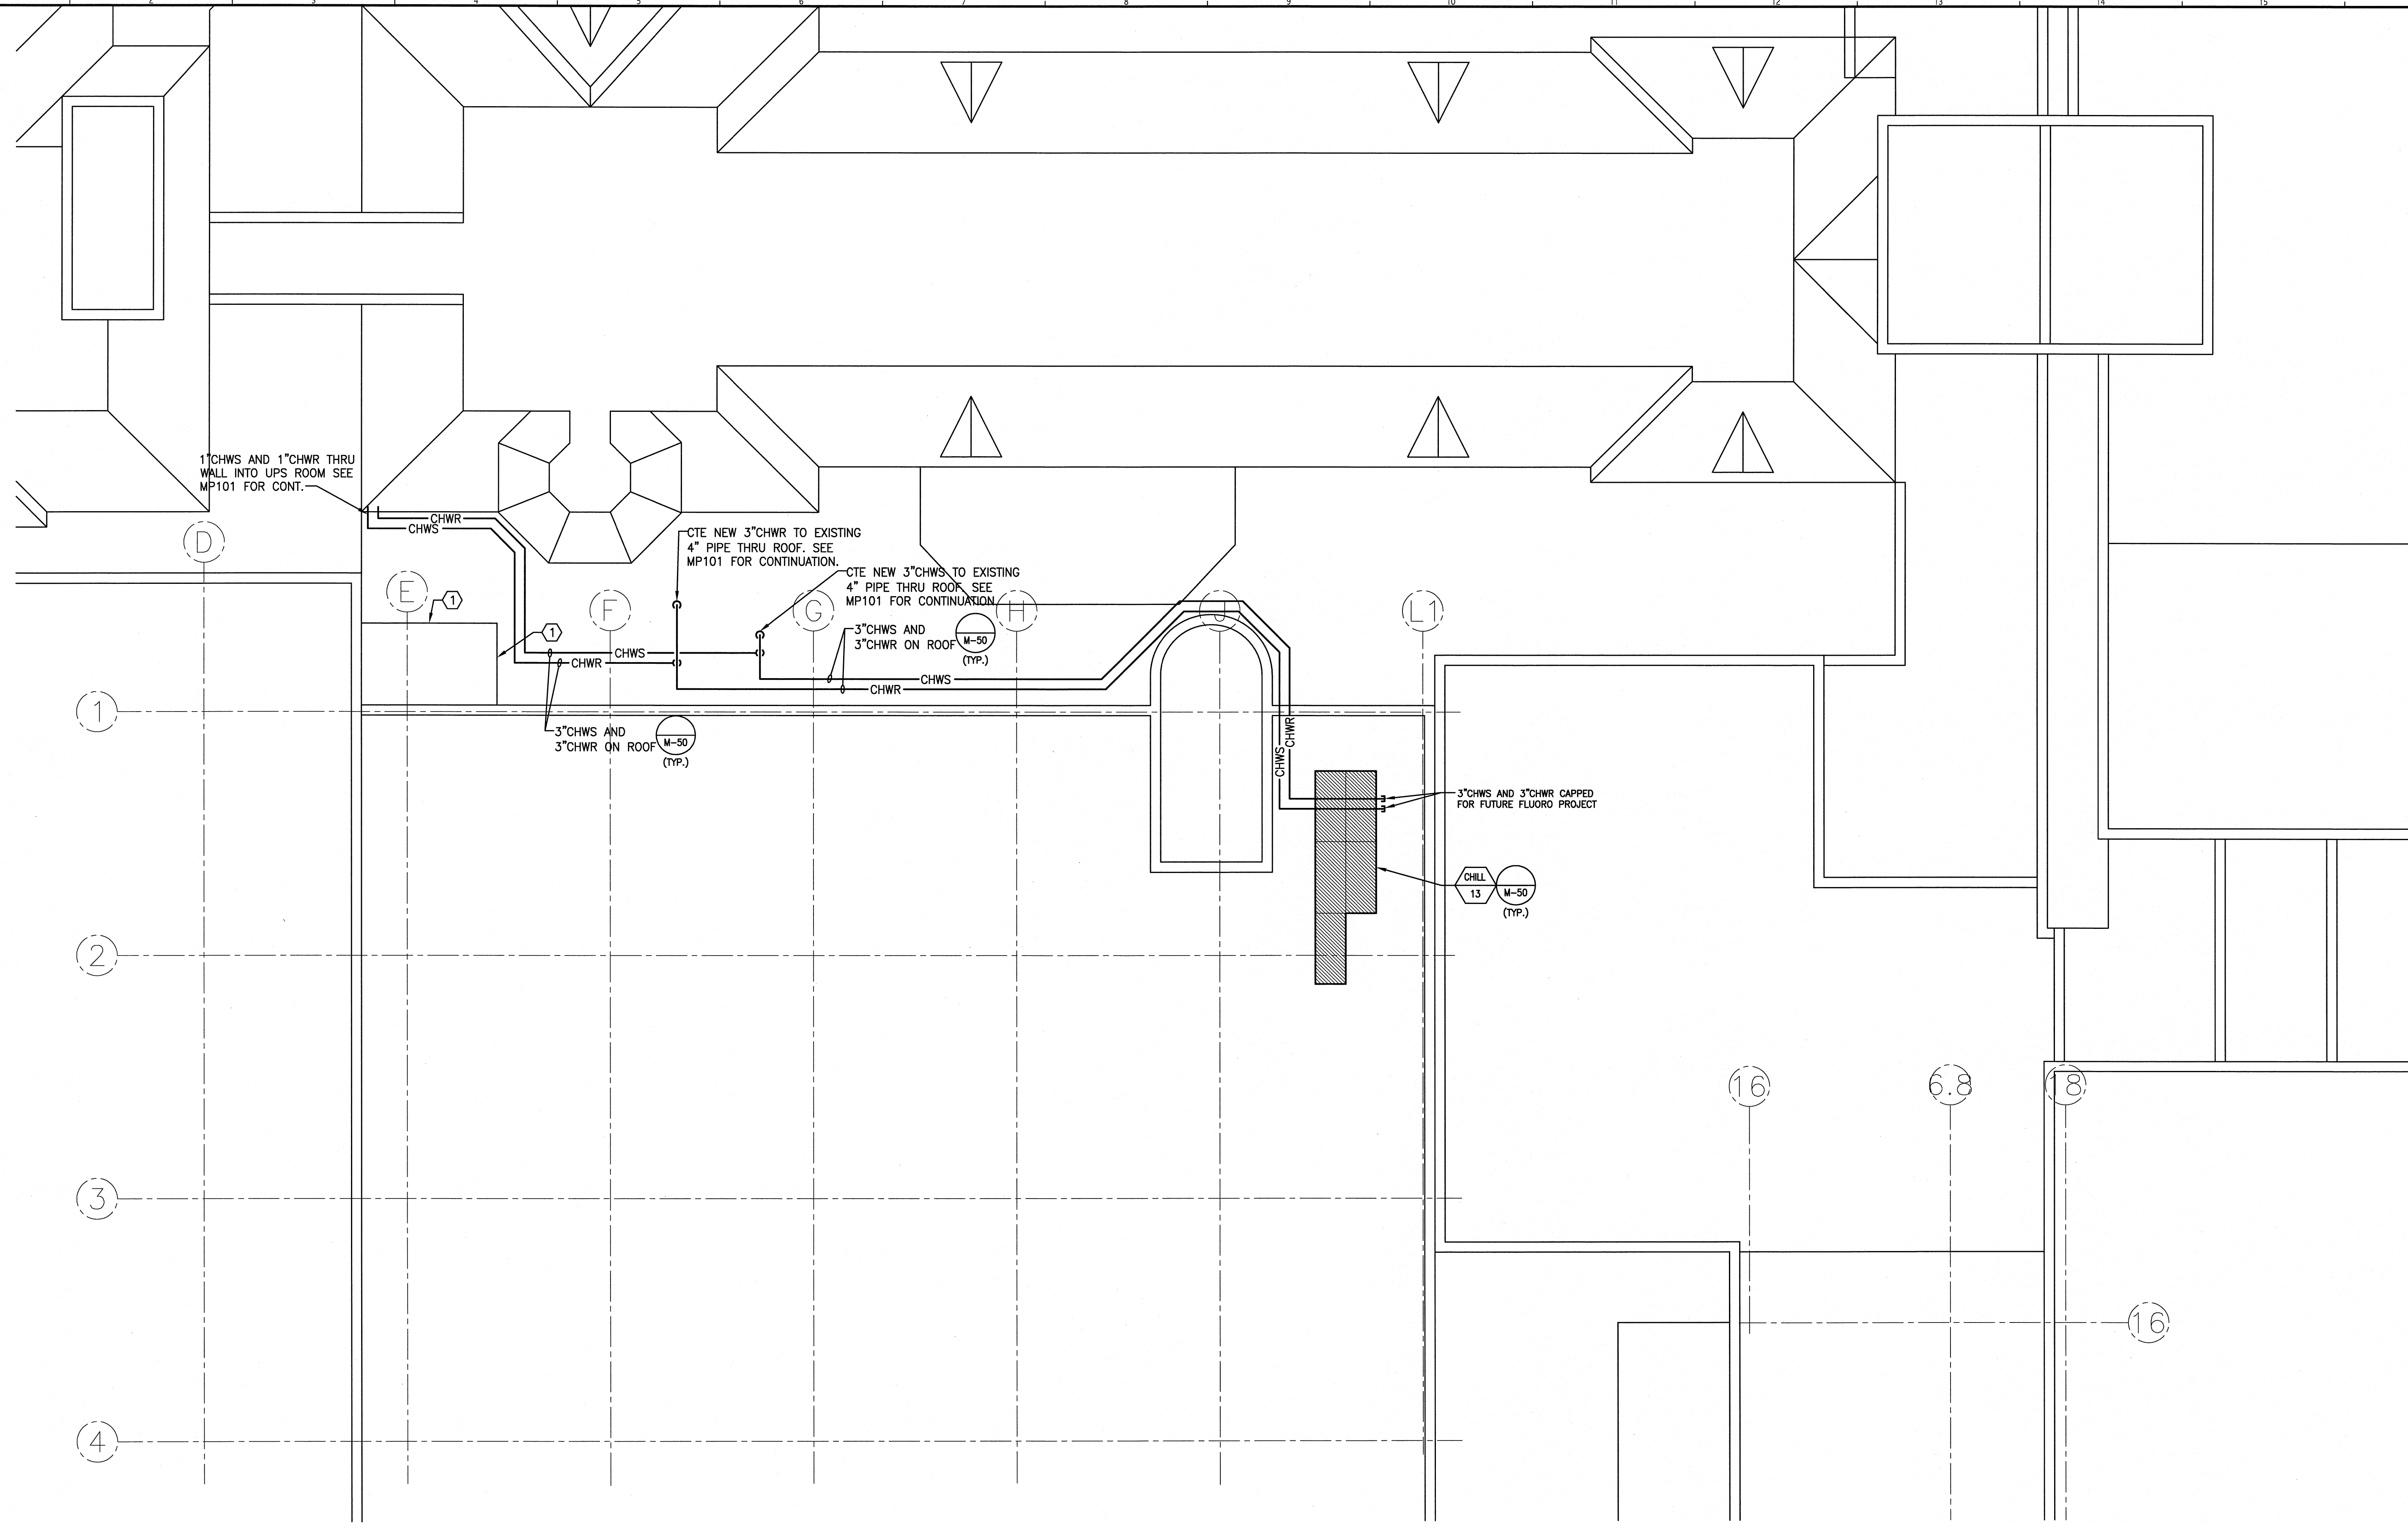

1"CHWS AND 1"CHWR THRU WALL INTO UPS ROOM SEE MP101 FOR CONT.

CTE NEW 3"CHWR TO EXISTING 4" PIPE THRU ROOF. SEE MP101 FOR CONTINUATION.

CTE NEW 3"CHWS TO EXISTING 4" PIPE THRU ROOF. SEE MP101 FOR CONTINUATION.

3"CHWS AND 3"CHWR CAPPED FOR FUTURE FLUORO PROJECT

NOTE:
 1. SEE SHEET M-001 FOR LEGEND AND ABBREVIATIONS.

KEYED NOTE:
 PROVIDE NEW LOUVER TO REPLACE EXISTING AND ALSO INSTALL NEW LOUVER DIRECTLY BELOW. BASIS OF DESIGN: RUSKIN ELF6375DX.