





3 AHU-047 DETAIL  
NOT TO SCALE

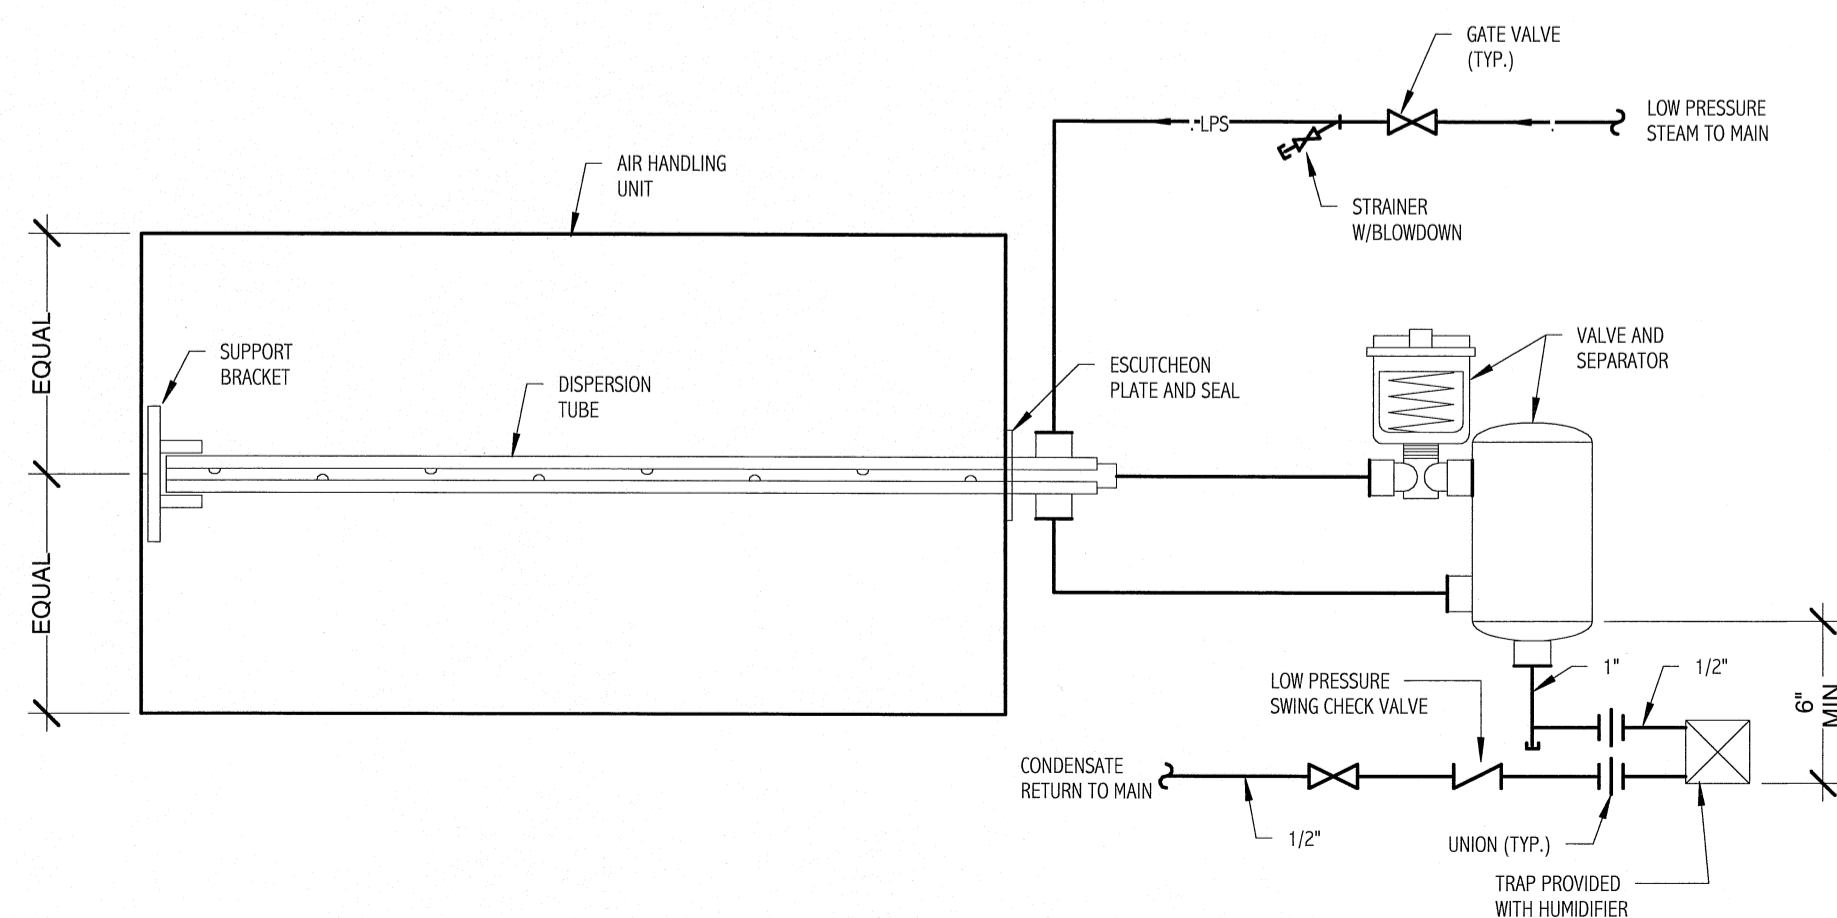



1 STEAM HUMIDIFIER DETAIL  
NOT TO SCALE

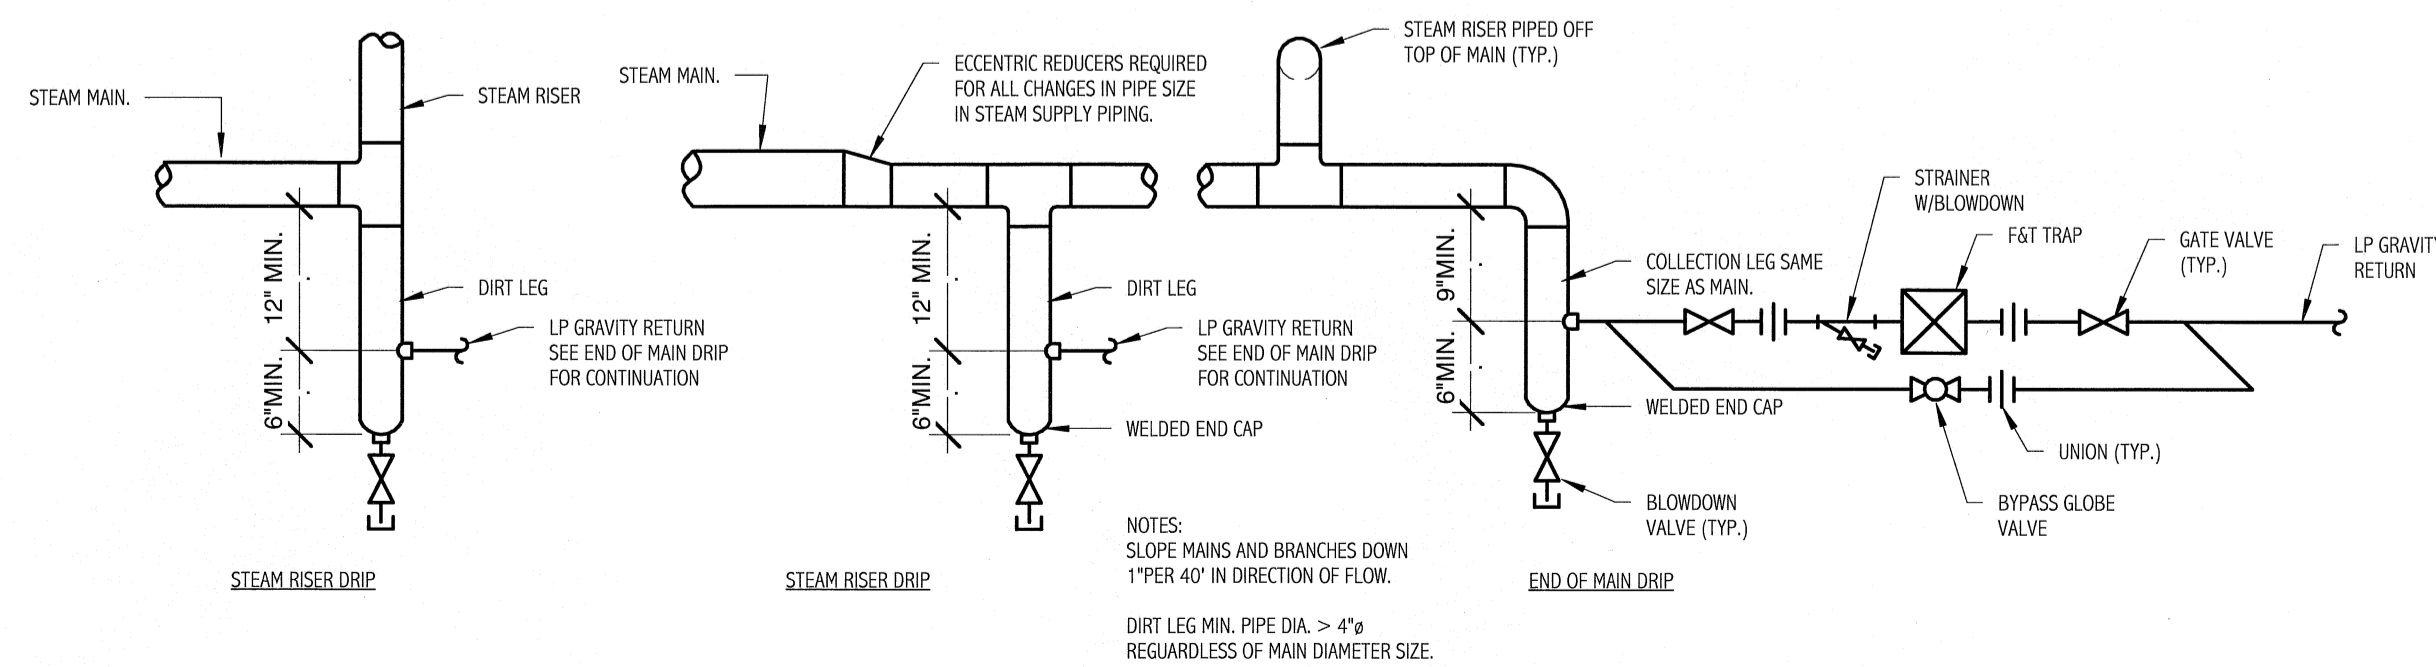

2 STEAM TRAP DETAILS  
NOT TO SCALE

144 First Street P.O. Box 618  
Portland, Maine 04104  
Tel: (207) 776-3846  
Fax: (207) 776-1070  
www.smartinc.com

ARCHITECTURE  
ENGINEERING  
PLANNING  
INTERIOR DESIGN  
COMMISSIONING

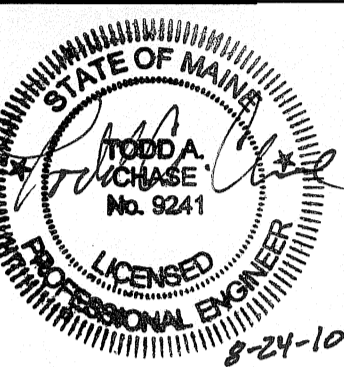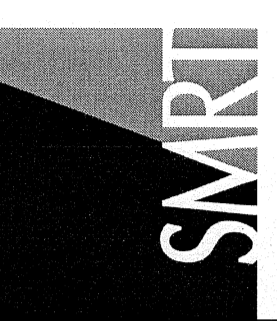

Bramhall Radiology  
ANGIO RENOVATIONS  
PORTLAND, ME  
ISSUED FOR CONSTRUCTION  
08.24.10  
CURRENT ISSUE STATUS:

NO.	DATE	DESCRIPTION
0	8.24.10	ISSUED FOR CONSTRUCTION
1		
2		
3		
4		
5		
6		
7		
8		
9		
10		
11		
12		
13		
14		
15		
16		

GRAPHIC SCALE:  
0" 1"

SCALE: NOT TO SCALE  
PROJECT MANAGER: DM  
JC/DRAWN BY: KPB  
A/E OF RECORD: TAC  
PROJECT NO: 09022-01  
DATE: 08.24.10

SHEET TITLE:  
MECHANICAL DETAILS

SHEET No.  
M-502