


MAINE MEDICAL CENTER

22 Bramhall Street
Portland, ME 04102

ARTIS ZEE CEILING

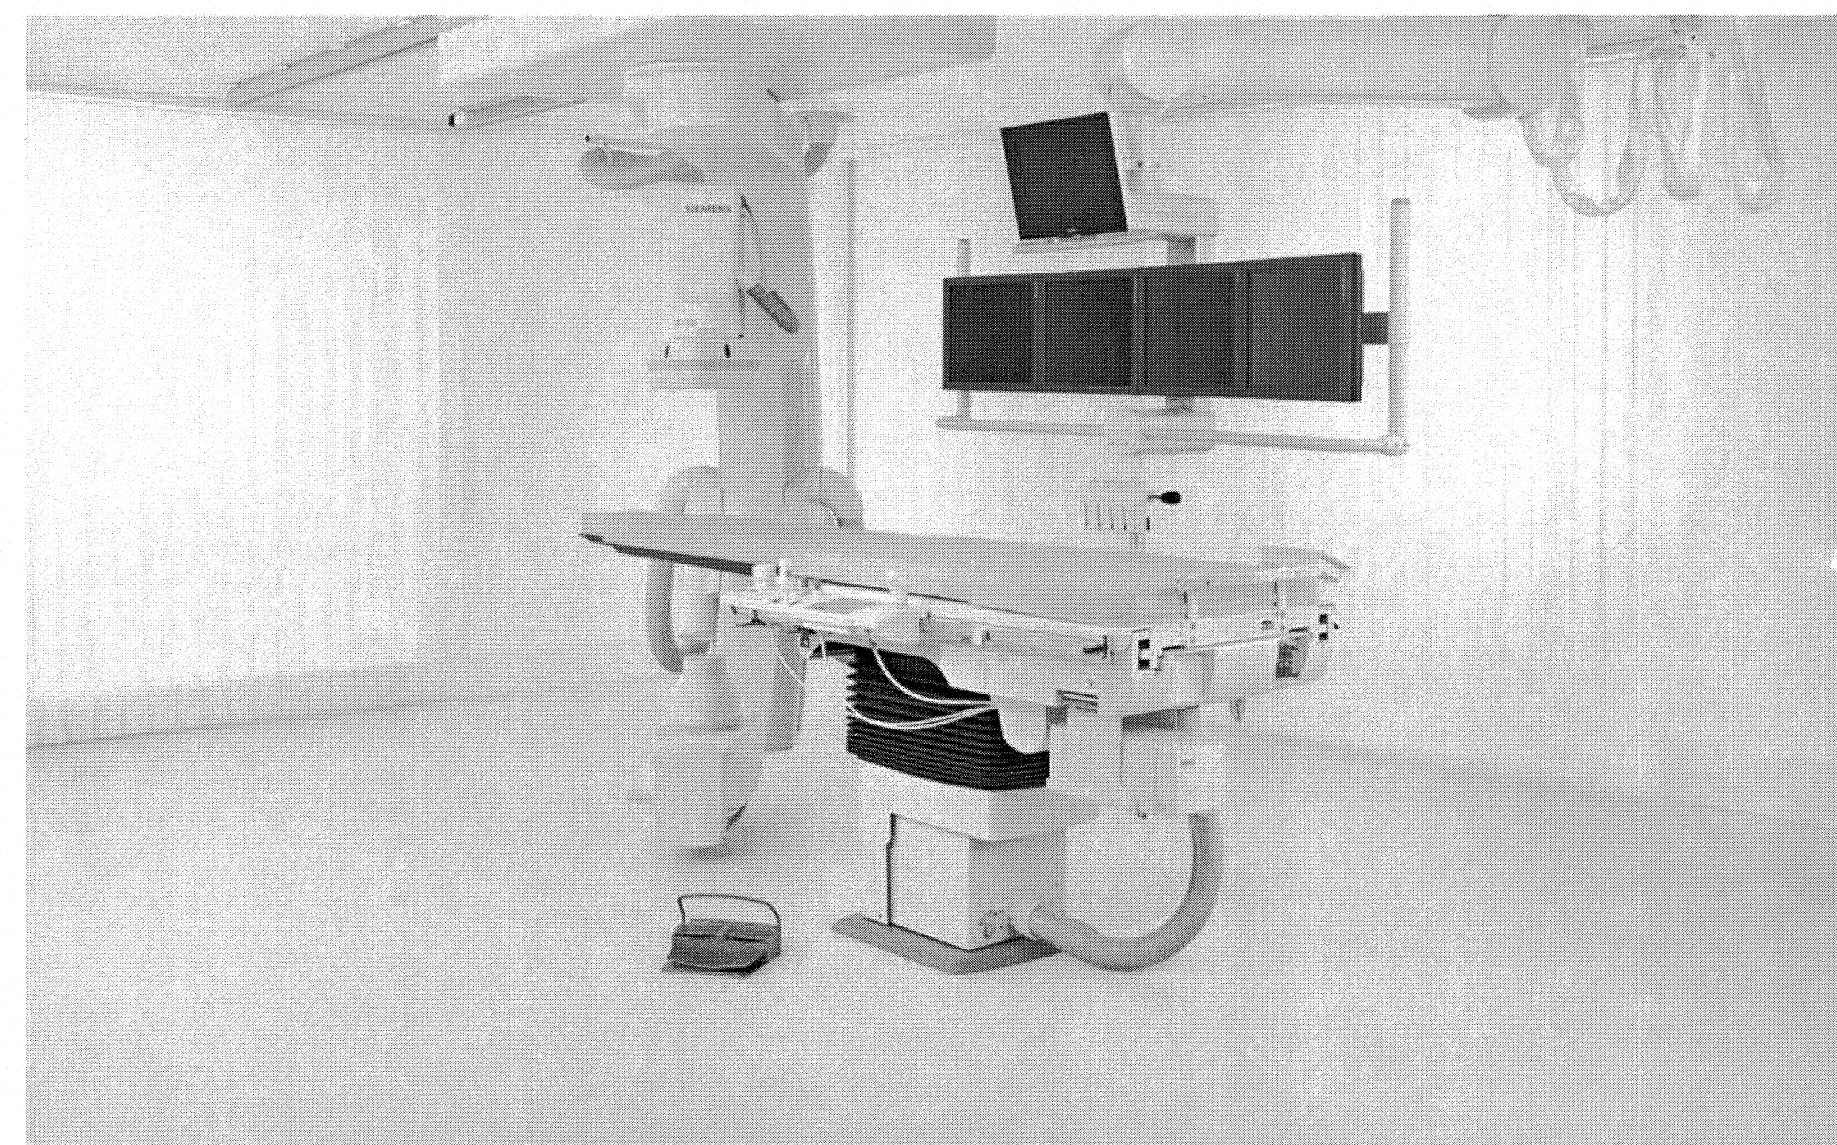

Contents:

Sheet No.	Description
A-101	EQUIPMENT LAYOUT-DETAILS, LEGEND, AND NOTES
A-102	REFLECTED CEILING, SAFETY/SERVICE CLEARANCE PLAN
S-101	STRUCTURAL FLOOR PLAN-DETAILS AND NOTES
S-102	STRUCTURAL CEILING PLAN-DETAILS AND NOTES
E-101	ELECTRICAL PLAN(S)-LEGEND AND NOTES
E-102	ELECTRICAL PLAN-LEGEND AND NOTES
E-501	ELECTRICAL DETAILS AND NOTES
M-101	MECHANICAL PLAN-DETAILS AND NOTES

Project Contacts:

Siemens Project Manager Rich Deister Phone: (207) 929-3556 Voice Mail: () - rich.deister@siemens.com	Maine Medical Center Customer Contact Phone: Voice Mail: E-mail:	Ext: Ext.:
--	---	-------------------

Planner
Susi Douglas

Project #: 1001341

SIEMENS

SIEMENS MEDICAL SOLUTIONS

51 Valley Stream Parkway
Malvern, PA 19355
www.usa.siemens.com/medical

MAINE MEDICAL CENTER


ARTIS ZEE CEILING
ANGIO EXAM ROOM #3 B 429

Issue #: 1
Date: 08/19/10

SIEMENS

144 Free Street P.O. Box 618
Portland, Maine 04104
Tel: (207) 772-3846
Fax: (207) 772-1070
www.smrt.com

ARCHITECTURE
ENGINEERING
PLANNING
INTERIOR DESIGN
COMMISSIONING

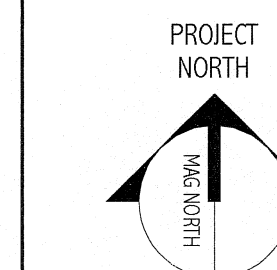

Bramhall Radiology
ANGIO RENOVATIONS
PORTLAND, ME
ISSUED FOR CONSTRUCTION
8.24.10
CURRENT ISSUE STATUS:

REV	DESCRIPTION	DATE
0	ISSUED FOR CONSTRUCTION	8.24.10

GRAPHIC SCALE:
0" 1"

SCALE:
PROJECT MANAGER: DIV
E.DRAWN BY: DIV
AGE OF RECORD: DIV
PROJECT NO: 09022-01
DATE: 8.24.10

SHEET TITLE:
VENDOR EQUIPMENT
DRAWINGS SHEET 1

SHEET No.
Q-001

NOTE: THIS DRAWING WAS NOT PREPARED BY SMRT. IT IS PROVIDED FOR COORDINATION AND REFERENCE PURPOSES ONLY.