





K1 MECHANICAL DEMOLITION ROOF PLAN

1/8"=1'-0"

NOTE:
1. SEE SHEET M-001 FOR LEGEND AND ABBREVIATIONS.

KEYED NOTES:
INSTALL CH-09 ON STRUCTURAL PLATFORM. SEE DRAWING - FOR LOCATION.

144 First Street, P.O. Box 918
Portland, Maine 04104
Tel: (207) 775-3846
Fax: (207) 775-1070
www.smartinc.com

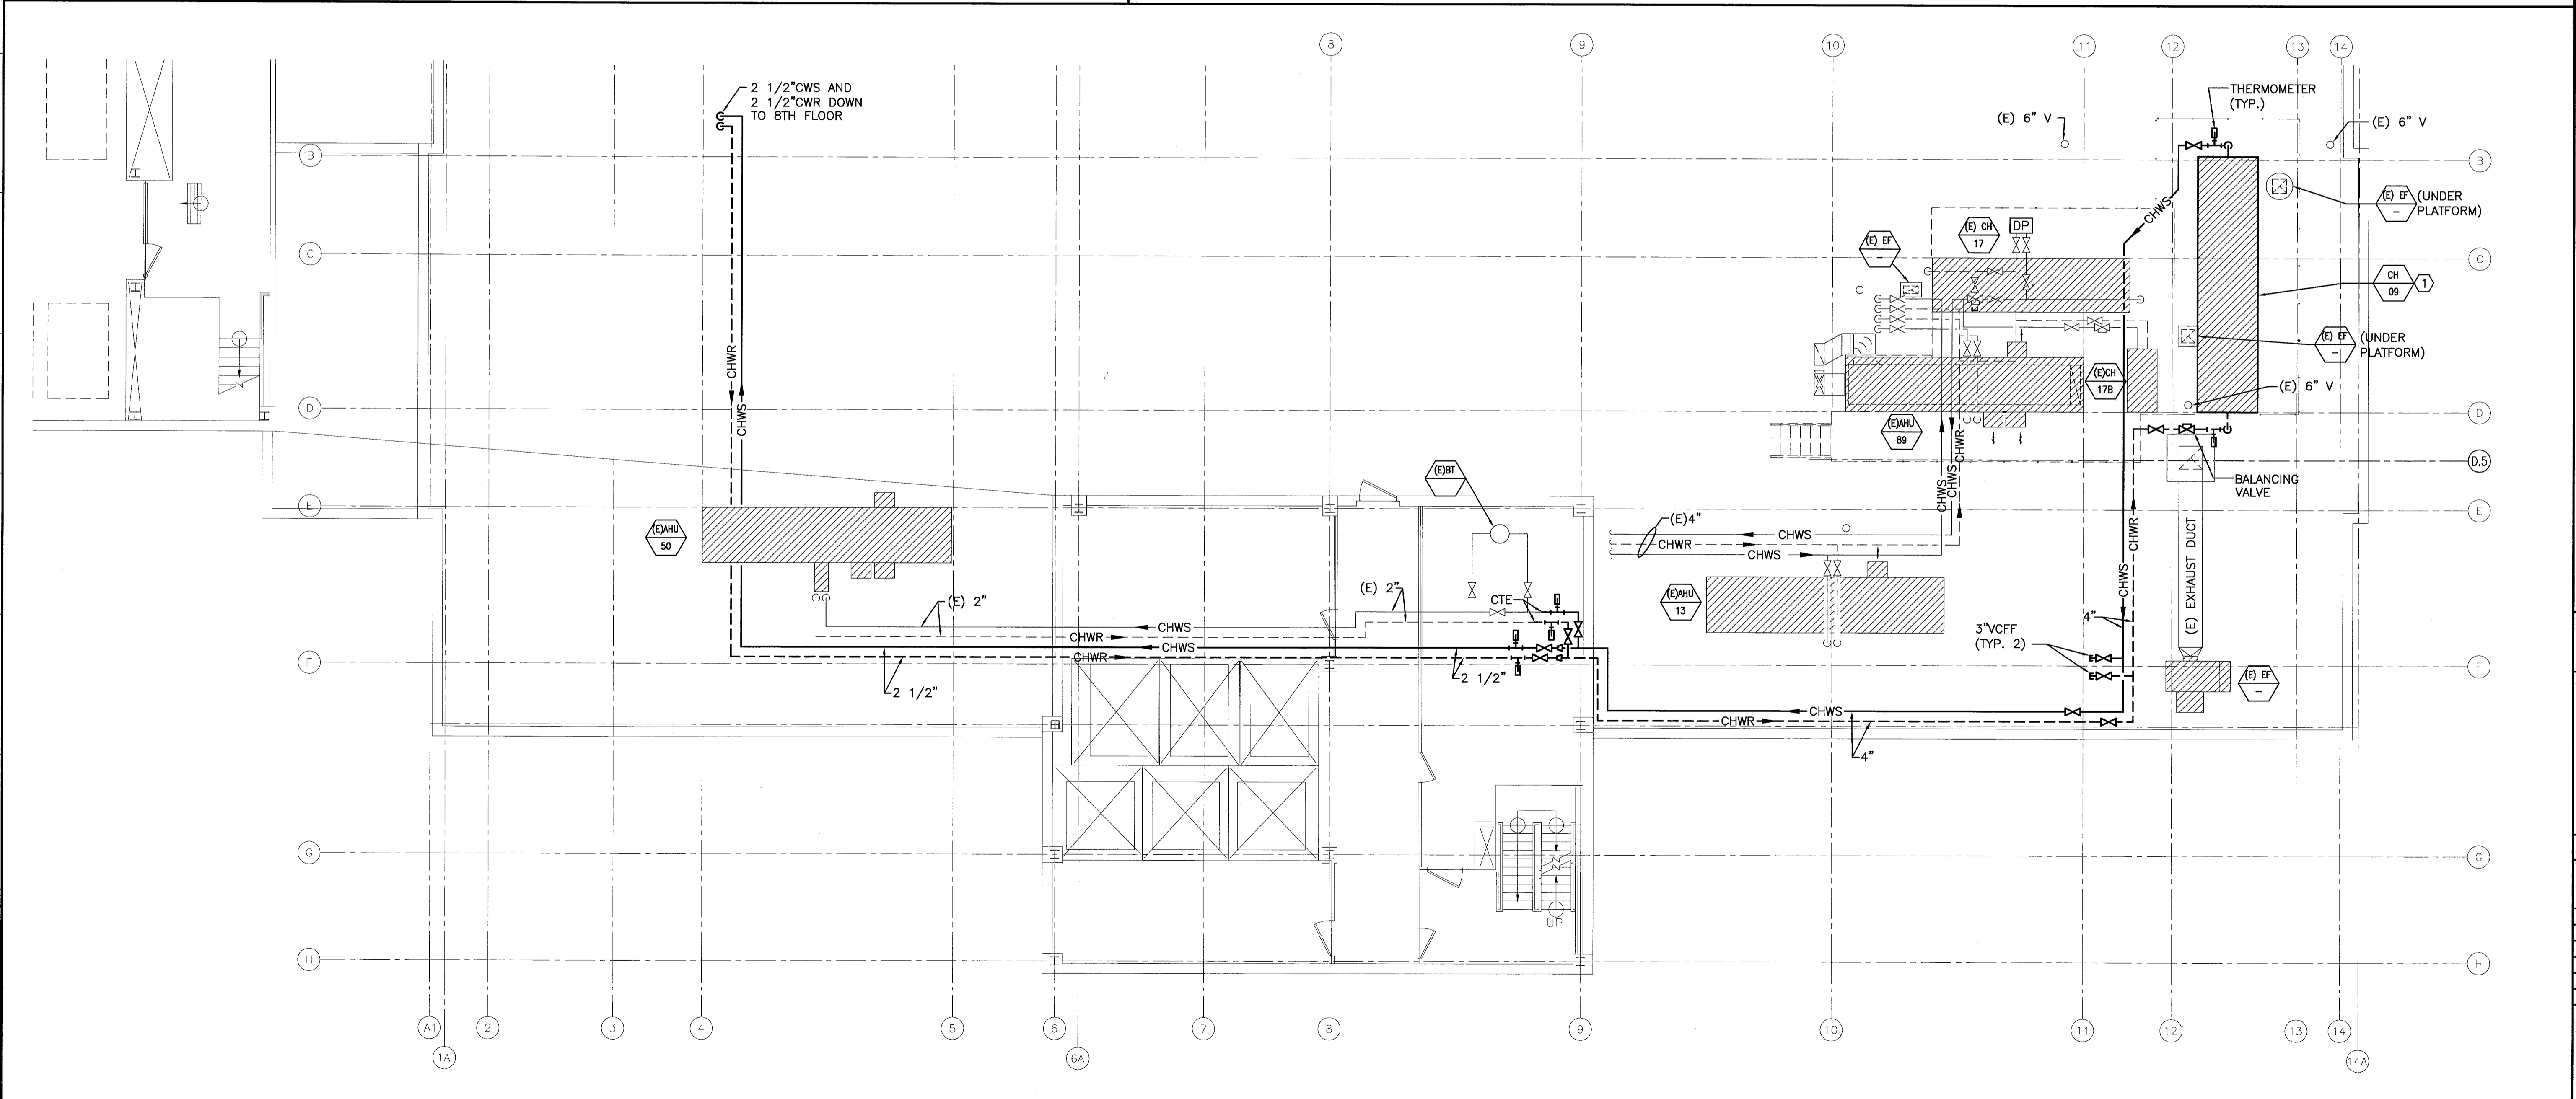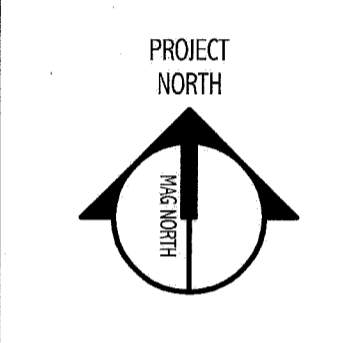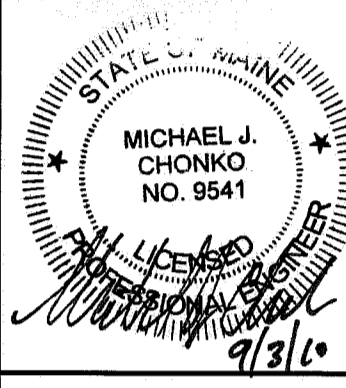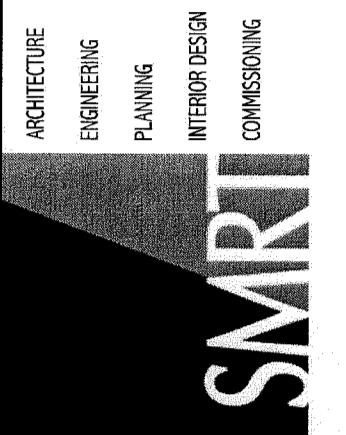

A1 MECHANICAL ROOF PLAN

1/8"=1'-0"

ISSUED FOR CONSTRUCTION
9.3.10

Maine Medical Center Cath Lab 5

NO.	DATE	DESCRIPTION
0	9.3.10	ISSUED FOR CONSTRUCTION

PROJECT MANAGER:	KD
DESIGNED BY:	BAL
DATE OF RECORD:	PMB
PROJECT NO.:	10006
DATE:	9.3.10

SHEET TITLE:
MECHANICAL NEW AND DEMO ROOF PLAN

SHEET No. **M-103**