


NOTES: ① INSULATE EXPOSED PIPING - TRUBRO #1026.

TAG	DESCRIPTION	FIXTURE	FAUCET/DRAIN	TRIM	SUPPORT	NOTES
SK-A	STAFF LOUNGE SINK STAFF ADA	ELKAY #LRAD-2219-5-1/2" 4 18 GAUGE, 304 SS SELF-RIMMING SINK - 4 HOLES	CHICAGO #1102-CP FAUCET WITH 317 HANDLES & #13 APARTOR, ELKAY #LKA018B SS GRID DRAIN & OFFSET TAIL	MCGUIRE LOOSE KEY ANGLE STOPS, ESCUTCHEONS AND RISERS-CHROME PLATED	-	①

PLUMBING FIXTURE SCHEDULE

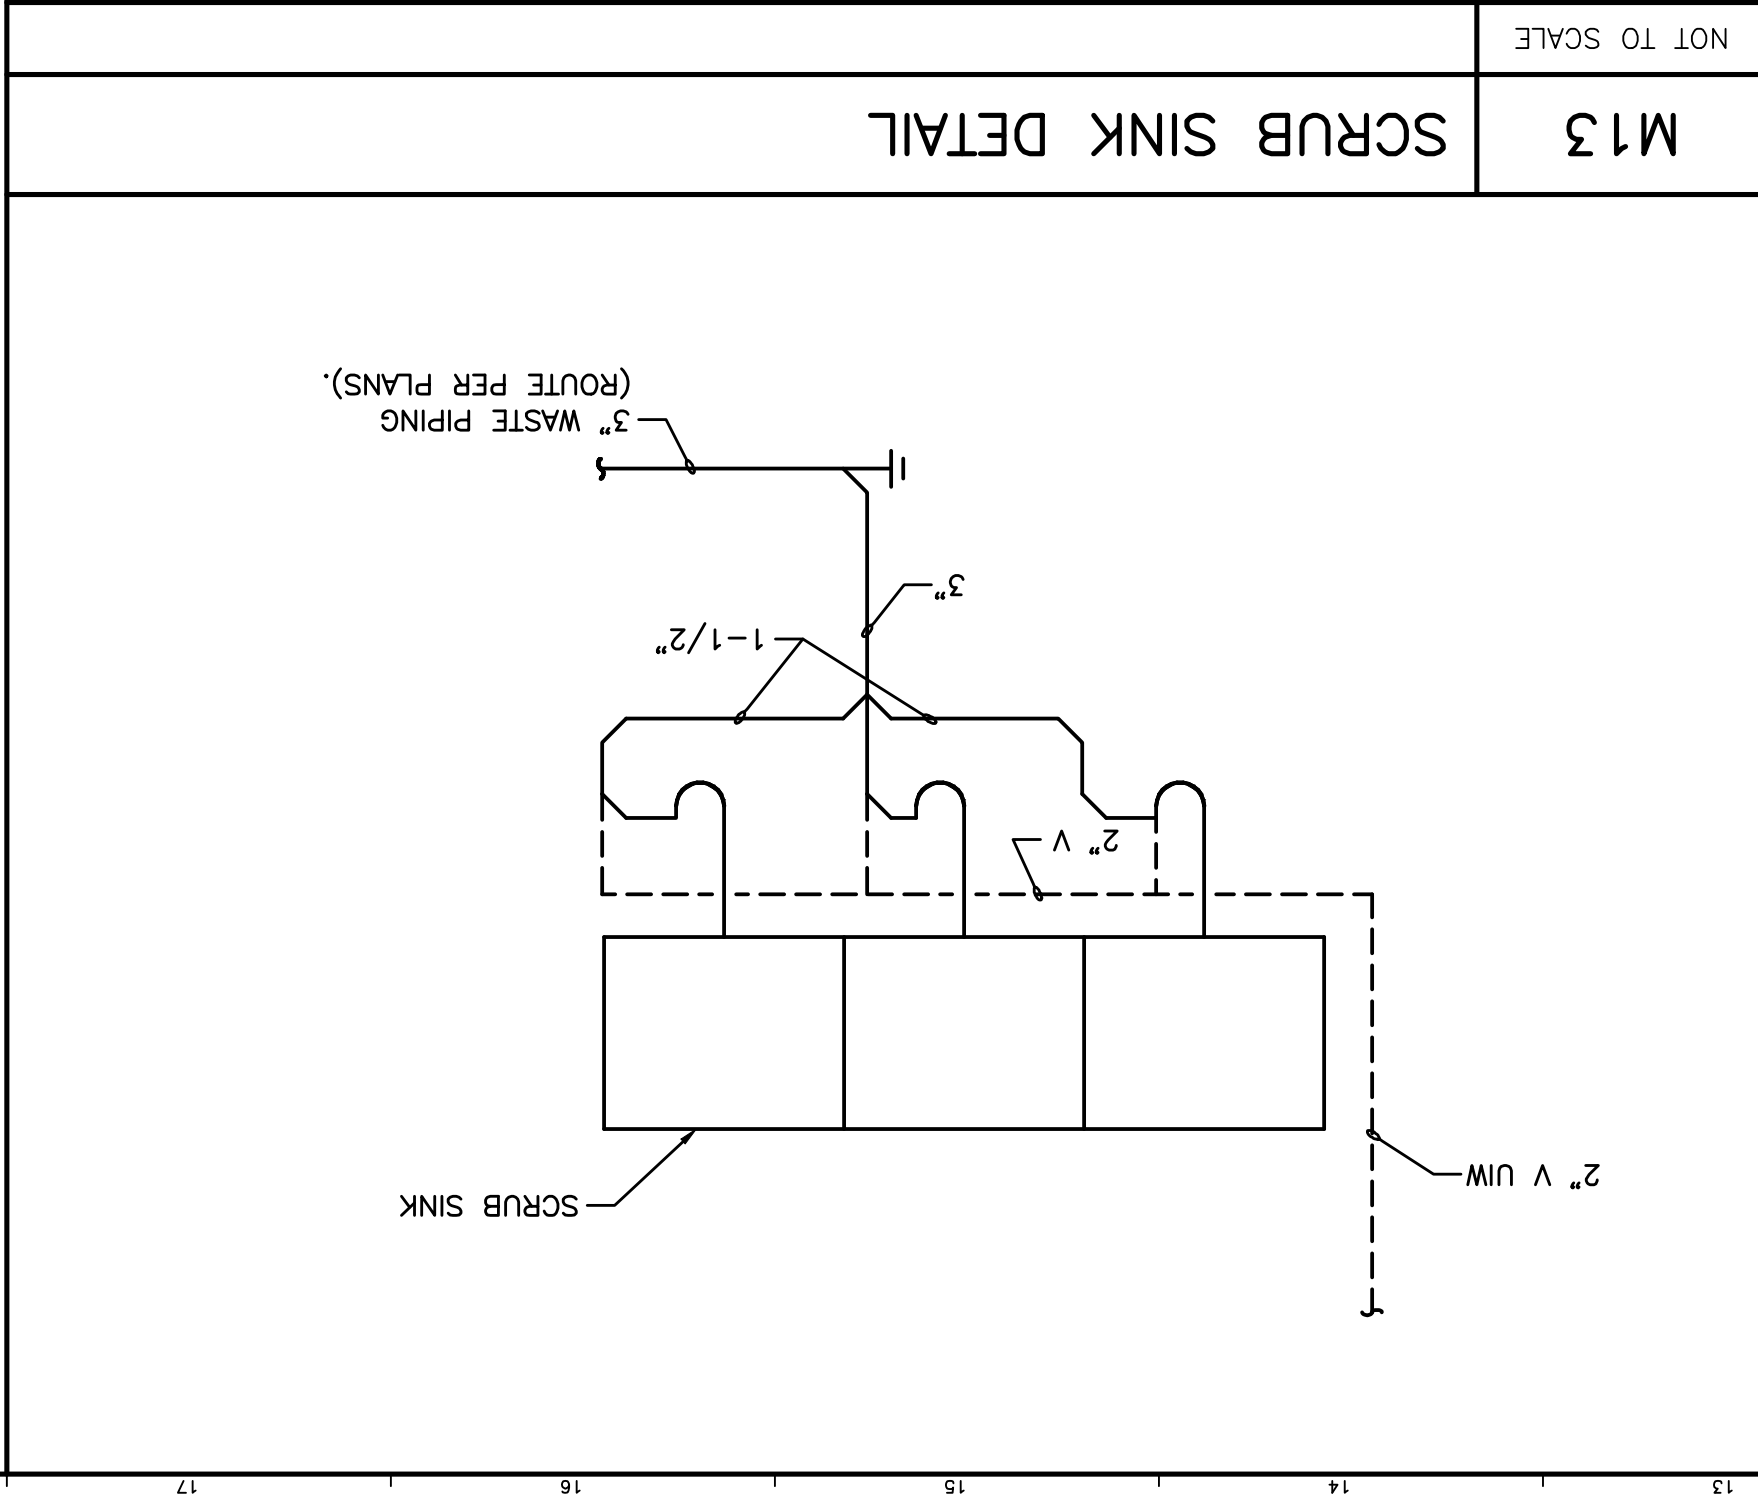

PROJECT: MAINE MEDICAL CENTER  
O.R. RENOVATION  
Portland, Maine

ARCHITECTURE ENGINEERING PLANNING  
SMART  
144 Fore Street, P.O. Box 618  
Portland, Maine 04104  
Tel. (207) 772-3846  
Fax. (207) 772-1070

PROJECT MANAGER: CFC  
JOB CAP/DRAWN: SOL/BGG  
A/E OF RECORD: LPA  
SMART CAD FILE: P-001-03122  
PROJECT No. 03122

DATE: 7-29-04  
SCALE: AS NOTED

SHEET TITLE:  
SCHEDULES, DETAILS  
AND PART PLAN

GRAPHIC SCALE: 0' 1"

SHEET No. P-501

ISSUED FOR CONSTRUCTION  
7-29-04

CURRENT ISSUE STATUS:

REV.	DESCRIPTION	DATE
0	ISSUED FOR CONSTRUCTION	7-29-04

NOTE:  
1. SEE SHEET M-001 FOR LEGEND AND ABBREVIATIONS.