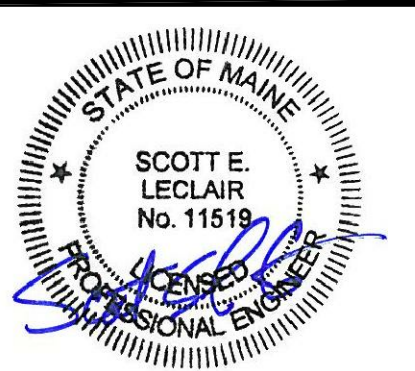


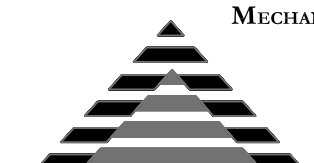
FIRE PROTECTION WORK NOTES:
 1 REMOVE EXISTING SPRINKLERS AND REPLACE WITH INSTITUTIONAL TYPE SPRINKLERS.

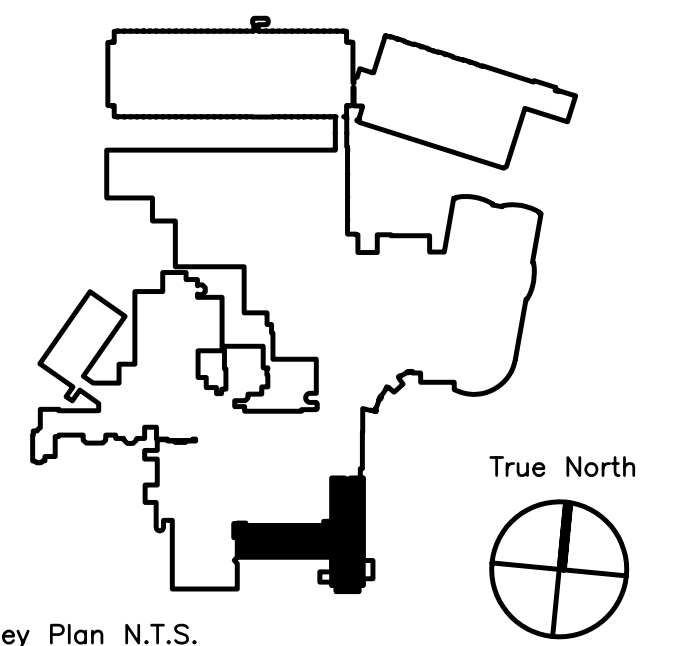
PAVILION "C" AND "D"

MorrisSwitzer
 Environments for Health
 Williston, Vermont One Dana Street Portland, ME 04101
 Boston, Massachusetts Portland, ME 04101
 Portland, Maine t 207.773.8841 f 207.773.8840
 © 2009 MorrisSwitzer morriswitzer.com



BECKER
 structural engineers, inc.
 75 York Street Portland, ME 04101-4701 info@beckerstructural.com
 Tel: 207-879-1838 Fax: 207-879-1822 www.beckerstructural.com

Consultant
 MECHANICAL / ELECTRICAL ENGINEERS

 FITZEMEYER & TOCCI ASSOCIATES, INC.
 92 Montvale Ave, Suite 4100 Stonham, MA 02180
 Tel: 781-481-0210 Fax: 781-481-0203
 email: info@f-t.com www.f-t.com
 Project No.: 09018.00



Key Plan N.T.S.

ADDENDUM#	Date	No
1	12/4/09	1
Revision		



MAINE MEDICAL CENTER
 PAVILION 6 RENOVATIONS
 MorrisSwitzer Project Number 28034
 Date 11/19/09
 Scale 1/8" = 1'-0"
 Sheet Title and Number
SECOND FLOOR
PAVILION "C" & "D"
INTERIM OCCUPANCY
FIRE PROTECTION PLAN
2FP1.0

