


Seals


**BECKER**  
structural engineers, inc.

75 York Street Tel 207-879-1838  
Portland, ME 04101-4701 Fax 207-879-1822  
info@beckerstructural.com www.beckerstructural.com

Consultant

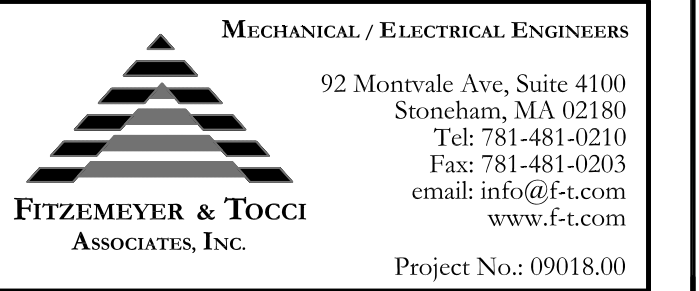

Consultant

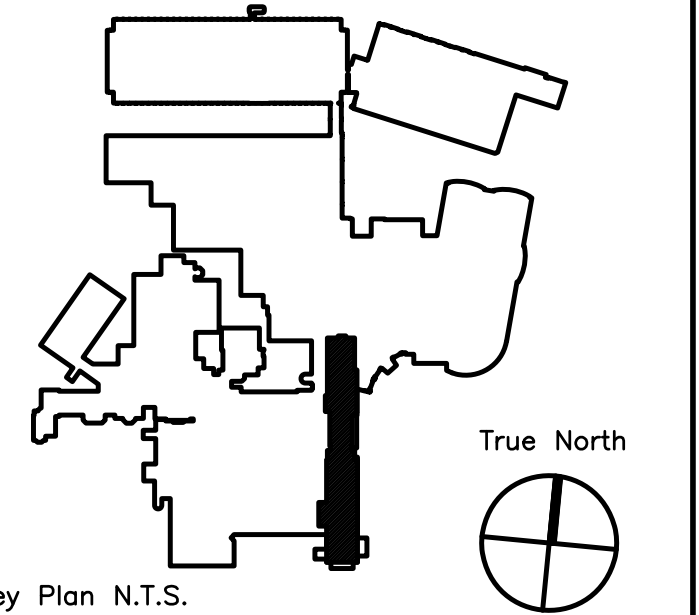

Key Plan N.T.S.

ADDENDUM#	Date	No
1	12/4/09	1
Revision	Date	No




**Maine Medical Center**  
Portland, Maine

**MAINE MEDICAL CENTER**  
PAVILION 6 RENOVATIONS

MorrisSwitzer Project Number 28034  
Date 11/19/09  
Scale 1/8" = 1'-0"  
Sheet Title and Number


**SIXTH FLOOR PAVILIONS "A" & "C" ELECTRICAL LOW TENSION PLAN**

**3E2.2**

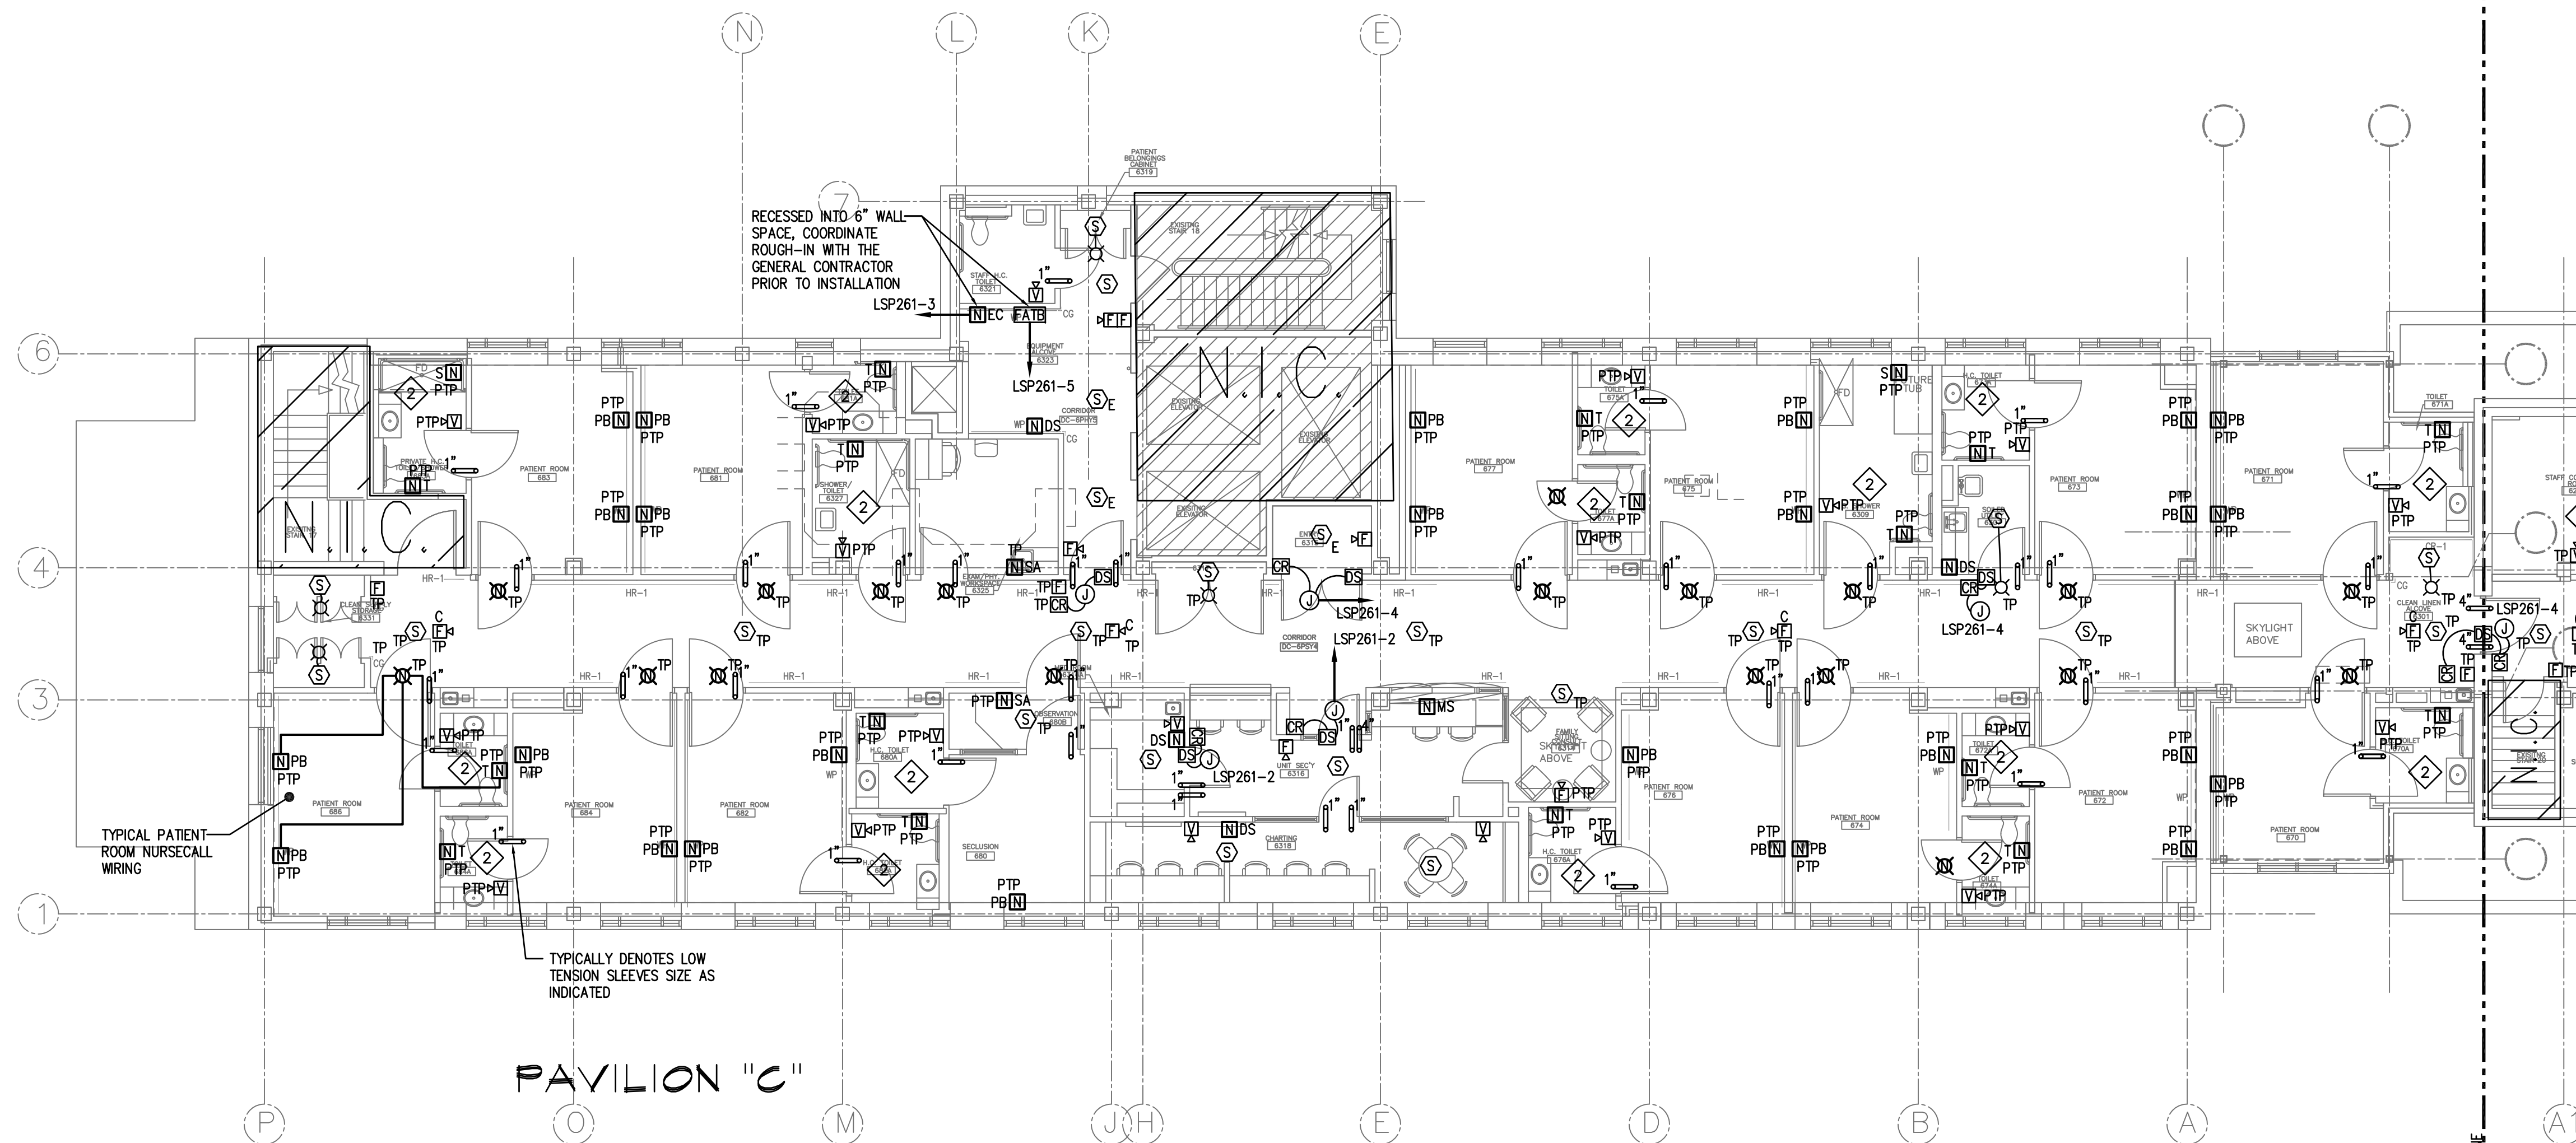

**PAVILION "C"**

- DRAWING NOTES:**
- 1 REFER ARCHITECTURAL FLOOR PLAN AND ELEVATIONS FOR EXACT LOCATION, QUANTITIES AND MOUNTING HEIGHTS
  - 2 ALL TOILET ROOM, CONFERENCE ROOMS, ETC. FIRE ALARM STROBE ONLY DEVICES SHALL BE ENCASED IN A PROTECTIVE COVER SIMILAR TO SAFETY TECHNOLOGY INTERNATIONAL CATALOG #ST-1221E OR APPROVED EQUAL.

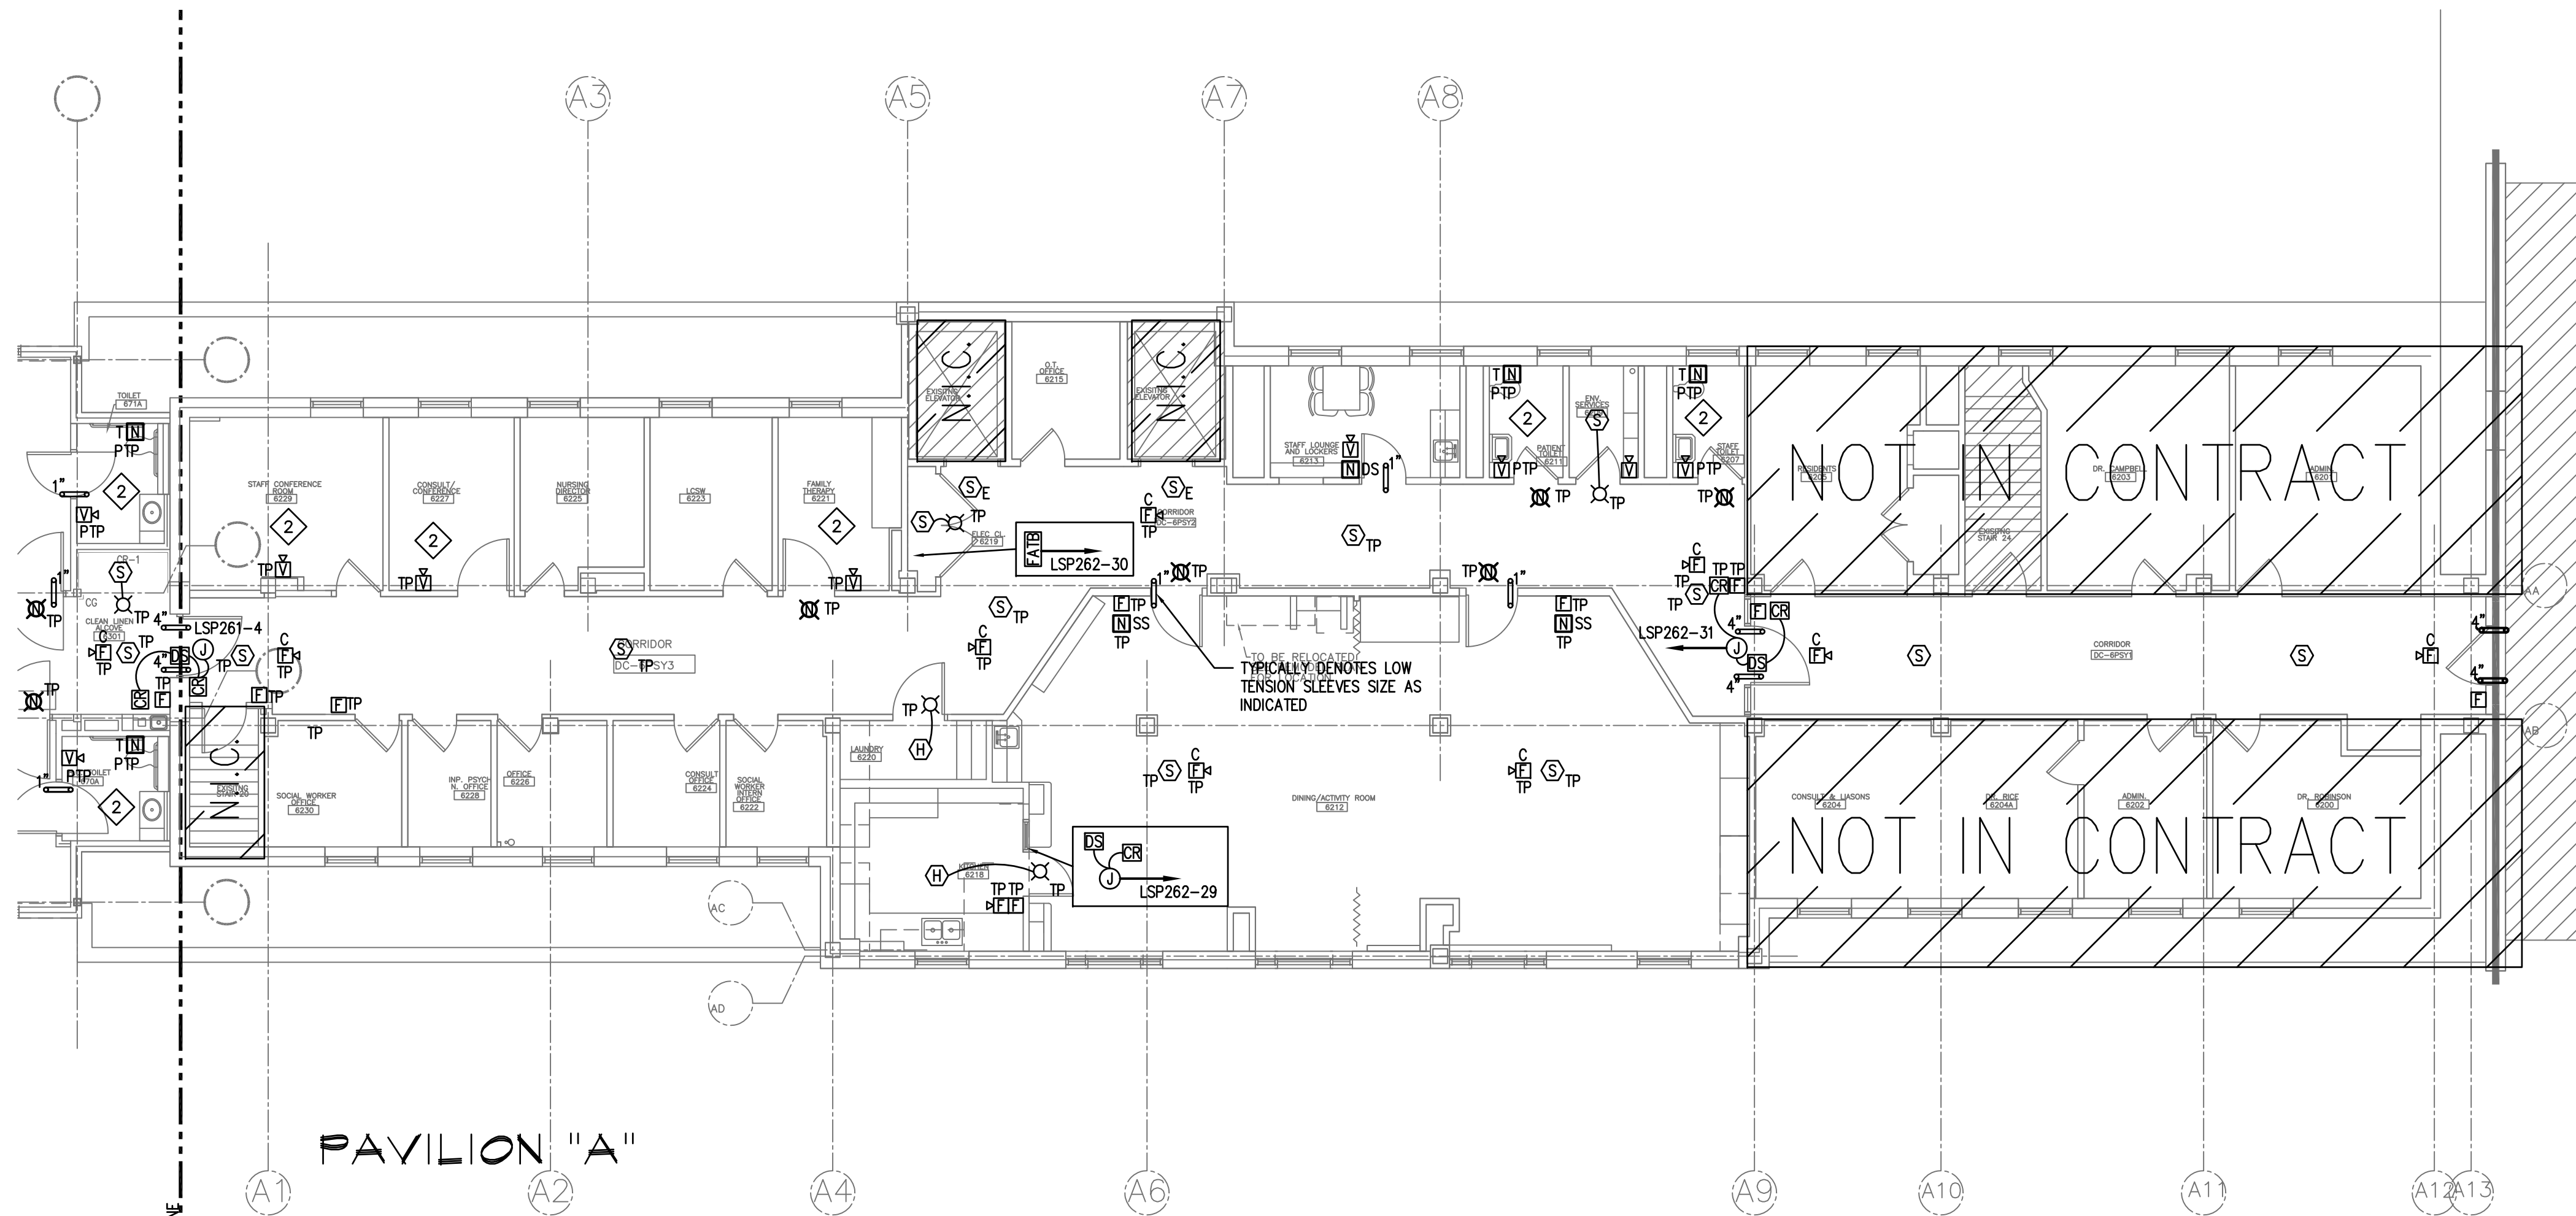

**PAVILION "A"**

True North

