


BECKER
structural engineers, inc.
75 York Street Portland, ME 04101-4701
info@beckerstructural.com
Tel 207-879-1838 Fax 207-879-1822
www.beckerstructural.com

Consultant

MECHANICAL / ELECTRICAL ENGINEERS
92 Montvale Ave, Suite 4100
Snohomish, MA 02180
Tel: 781-481-0210
Fax: 781-481-0203
email: info@f-t.com
www.f-t.com
Project No.: 09018.00

Consultant

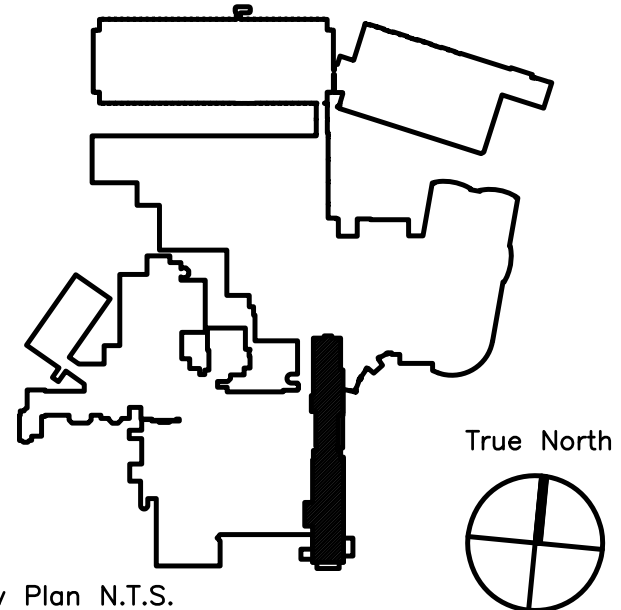

Key Plan N.T.S.

ADDENDUM#1	12/4/09	1
Revision	Date	No




Maine Medical Center
Portland, Maine


MAINE MEDICAL CENTER
PAVILION 6 RENOVATIONS

MorrisSwitzer Project Number 28034
Date 11/19/09
Scale 1/8" = 1'-0"
Sheet Title and Number

SIXTH FLOOR PAVILIONS
"A" & "C" ELECTRICAL
ROOF PLAN
3E2.3

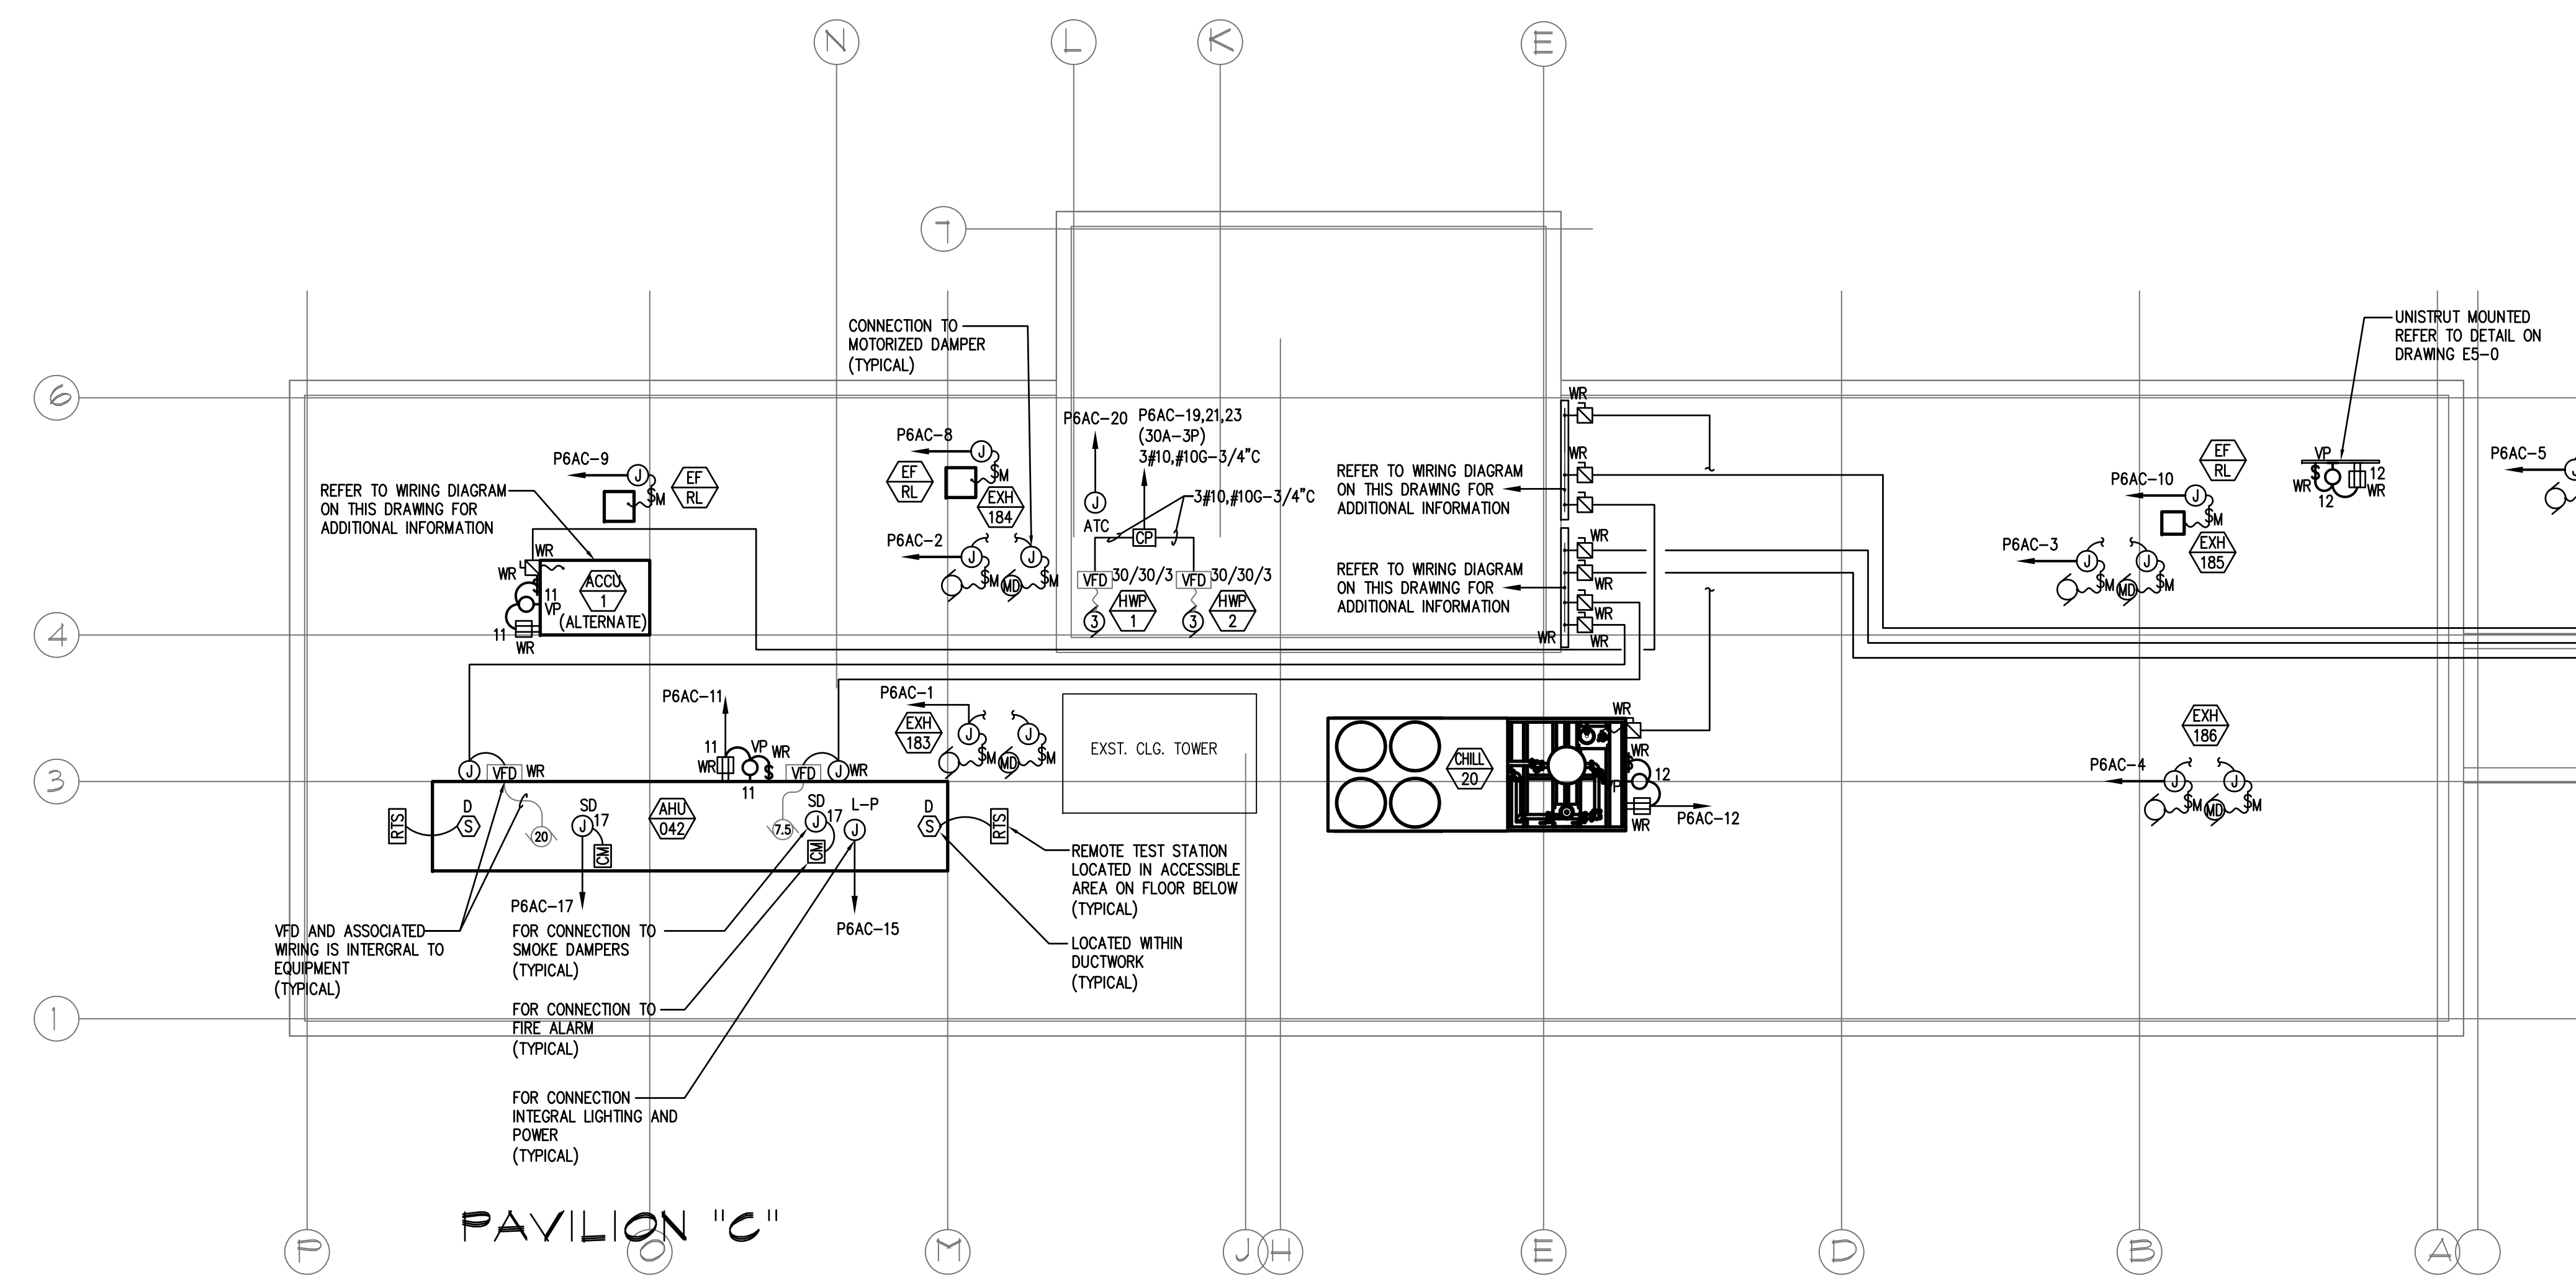

PAVILION "C"

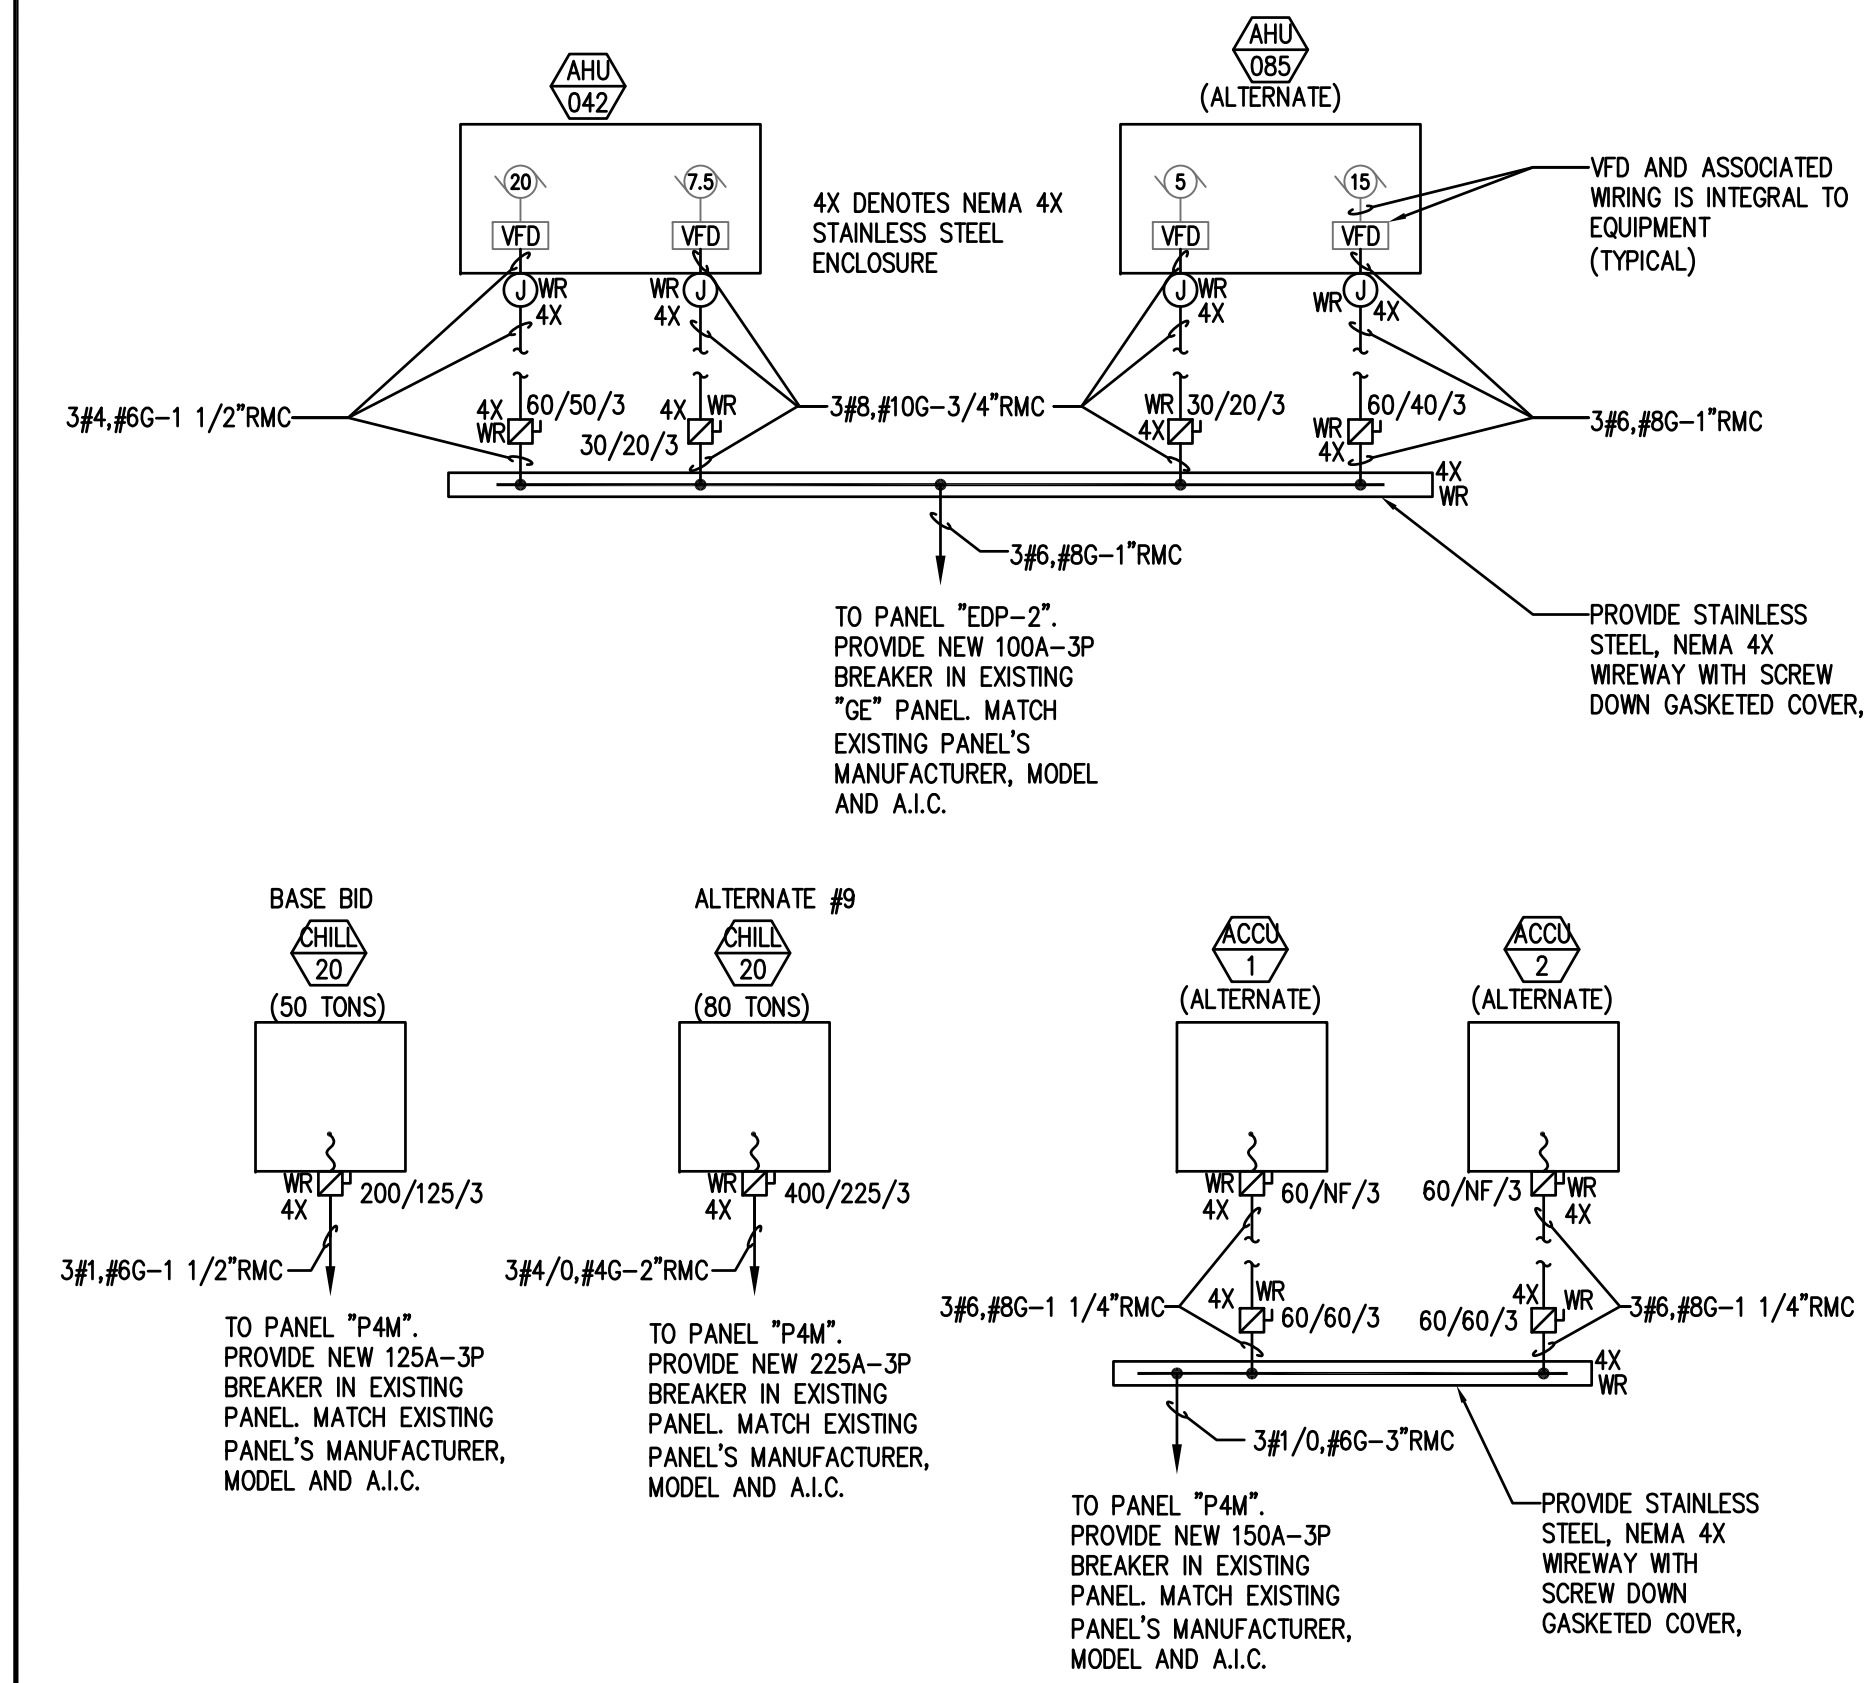

1 ROOF TOP WIRING DIAGRAMS
SCALE: NOT TO SCALE

PAVILION "A"

