


Seals

BECKER
structural engineers, inc.

75 York Street
Portland, ME 04101-4701
info@beckerstructural.com


Tel 207-879-1838
Fax 207-879-1822
www.beckerstructural.com

Consultant

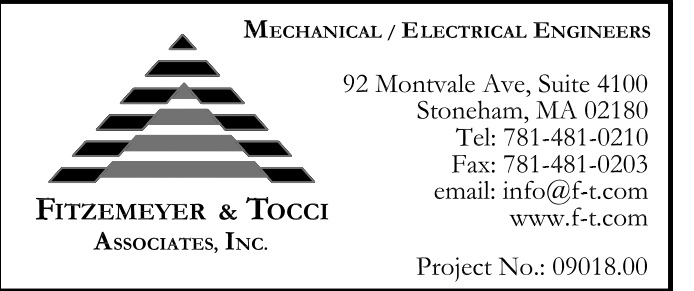

MECHANICAL / ELECTRICAL ENGINEERS
92 Montvale Ave, Suite 4100
Saco, ME 04158
Tel: 781-481-0210
Fax: 781-481-0203
email: info@f-t.com
www.f-t.com
Project No.: 09018.00

Consultant

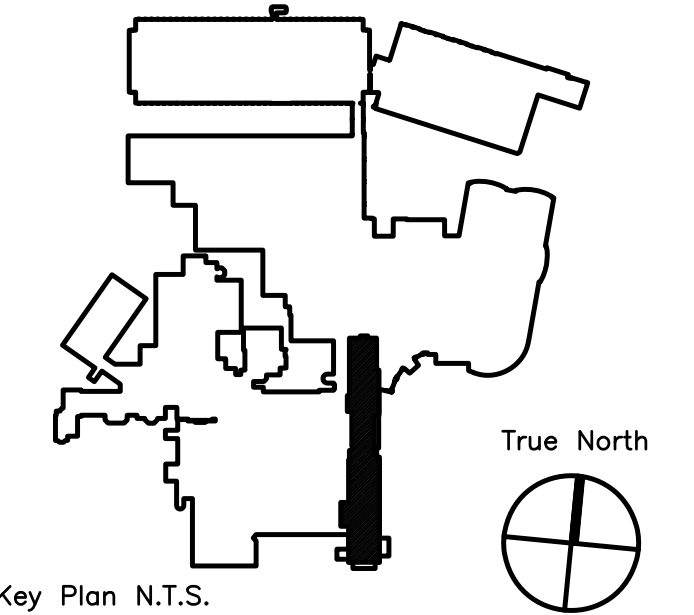

Key Plan N.T.S.

ADDENDUM#	Date	No
ADDENDUM# 1	12/4/09	1
Revision	Date	No




Maine Medical Center
Portland, Maine

MAINE MEDICAL CENTER
PAVILION 6 RENOVATIONS

MorrisSwitzer Project Number 28034
Date 11/19/09
Scale 1/8" = 1'-0"
Sheet Title and Number

SIXTH FLOOR PAVILIONS "A" & "C" MECHANICAL DEMOLITION ROOF PLAN


3M1.1

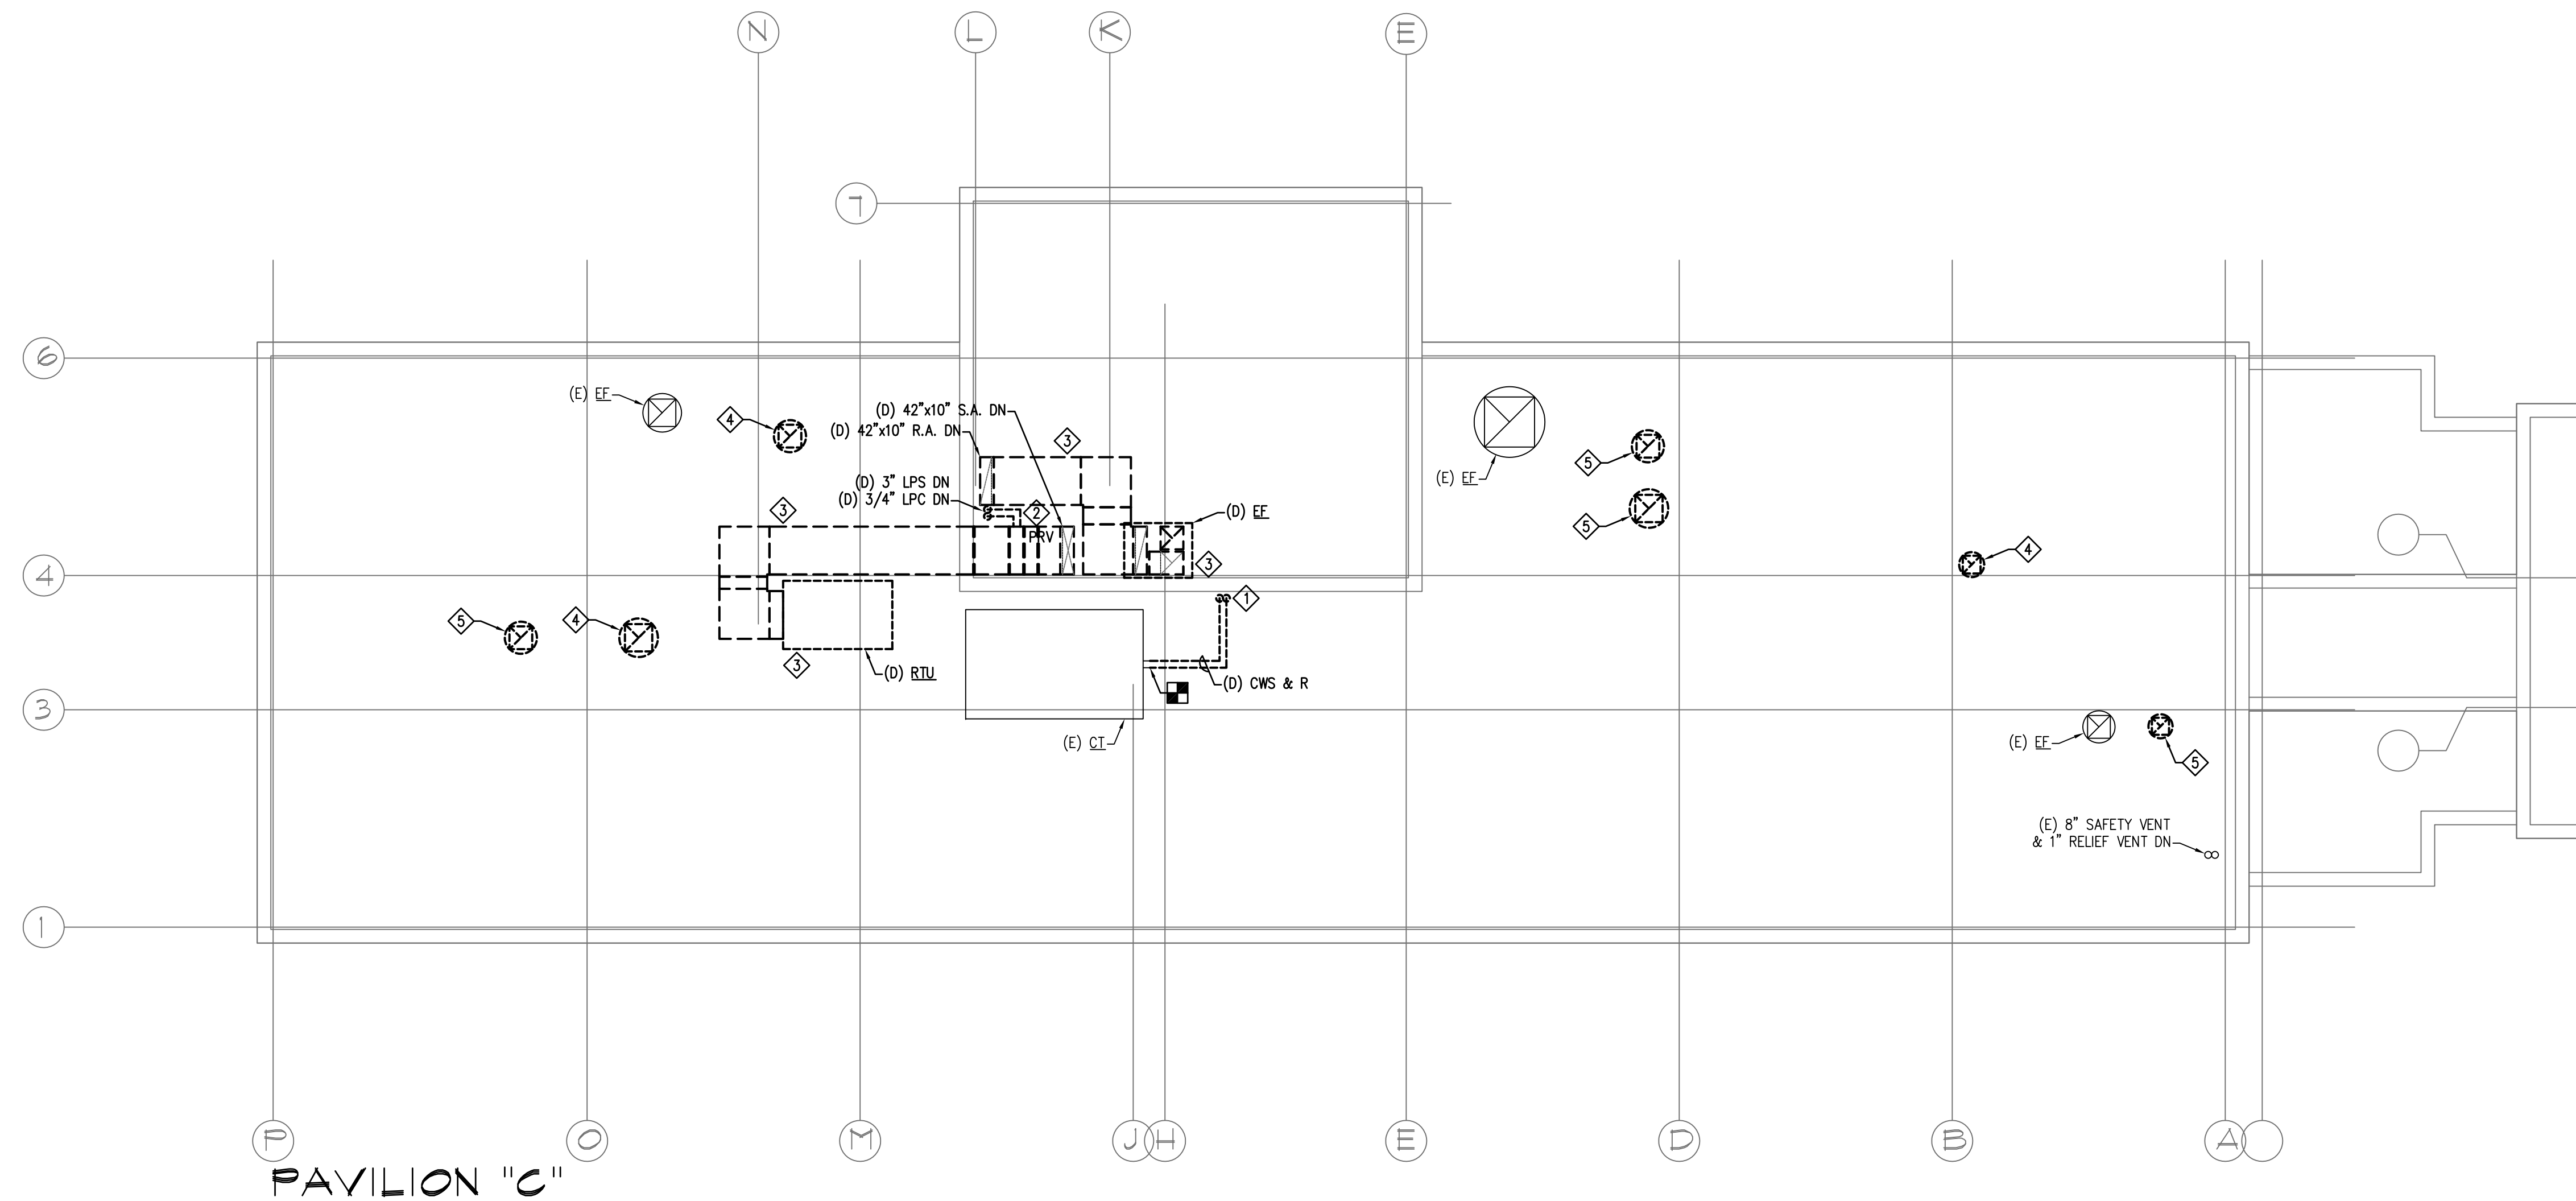

PAVILION "C"

MECHANICAL DEMOLITION KEYNOTES

- ① REMOVE EXISTING CONDENSER WATER PIPING AS INDICATED. EXISTING COOLING TOWER TO REMAIN. PIPING TO BE RE-ROUTED AS INDICATED IN NEW WORK PHASE. REFER TO DWGS 3M2.1 & 3M2.2 FOR NEW PIPING WORK.
- ② REMOVE EXISTING LOW-PRESSURE STEAM & CONDENSATE PIPING AS INDICATED AND CAP WITHIN INTERMEDIATE MECHANICAL SPACE BELOW 5TH FLOOR.
- ③ REMOVE EXISTING HVAC SYSTEM AS INDICATED, INCLUDING ROOF-TOP UNIT, EXHAUST FAN, STEAM HEATING COIL AND ALL ASSOCIATED DUCTWORK AND ACCESSORIES. RTU TO BE TURNED OVER TO OWNER AFTER REMOVAL.
- ④ REMOVE EXISTING EXHAUST FAN AND CURB AND PATCH ROOF. RETAIN EQUIPMENT FOR RE-LOCATION IN NEW WORK PHASE. REFER TO DWG. 3M2.2 FOR NEW LOCATION.
- ⑤ REMOVE EXISTING EXHAUST FAN AND CURB AND PATCH ROOF.
- ⑥ REMOVE EXISTING CONDENSING UNIT AND ASSOCIATED PIPING & ACCESSORIES. PATCH ROOF.

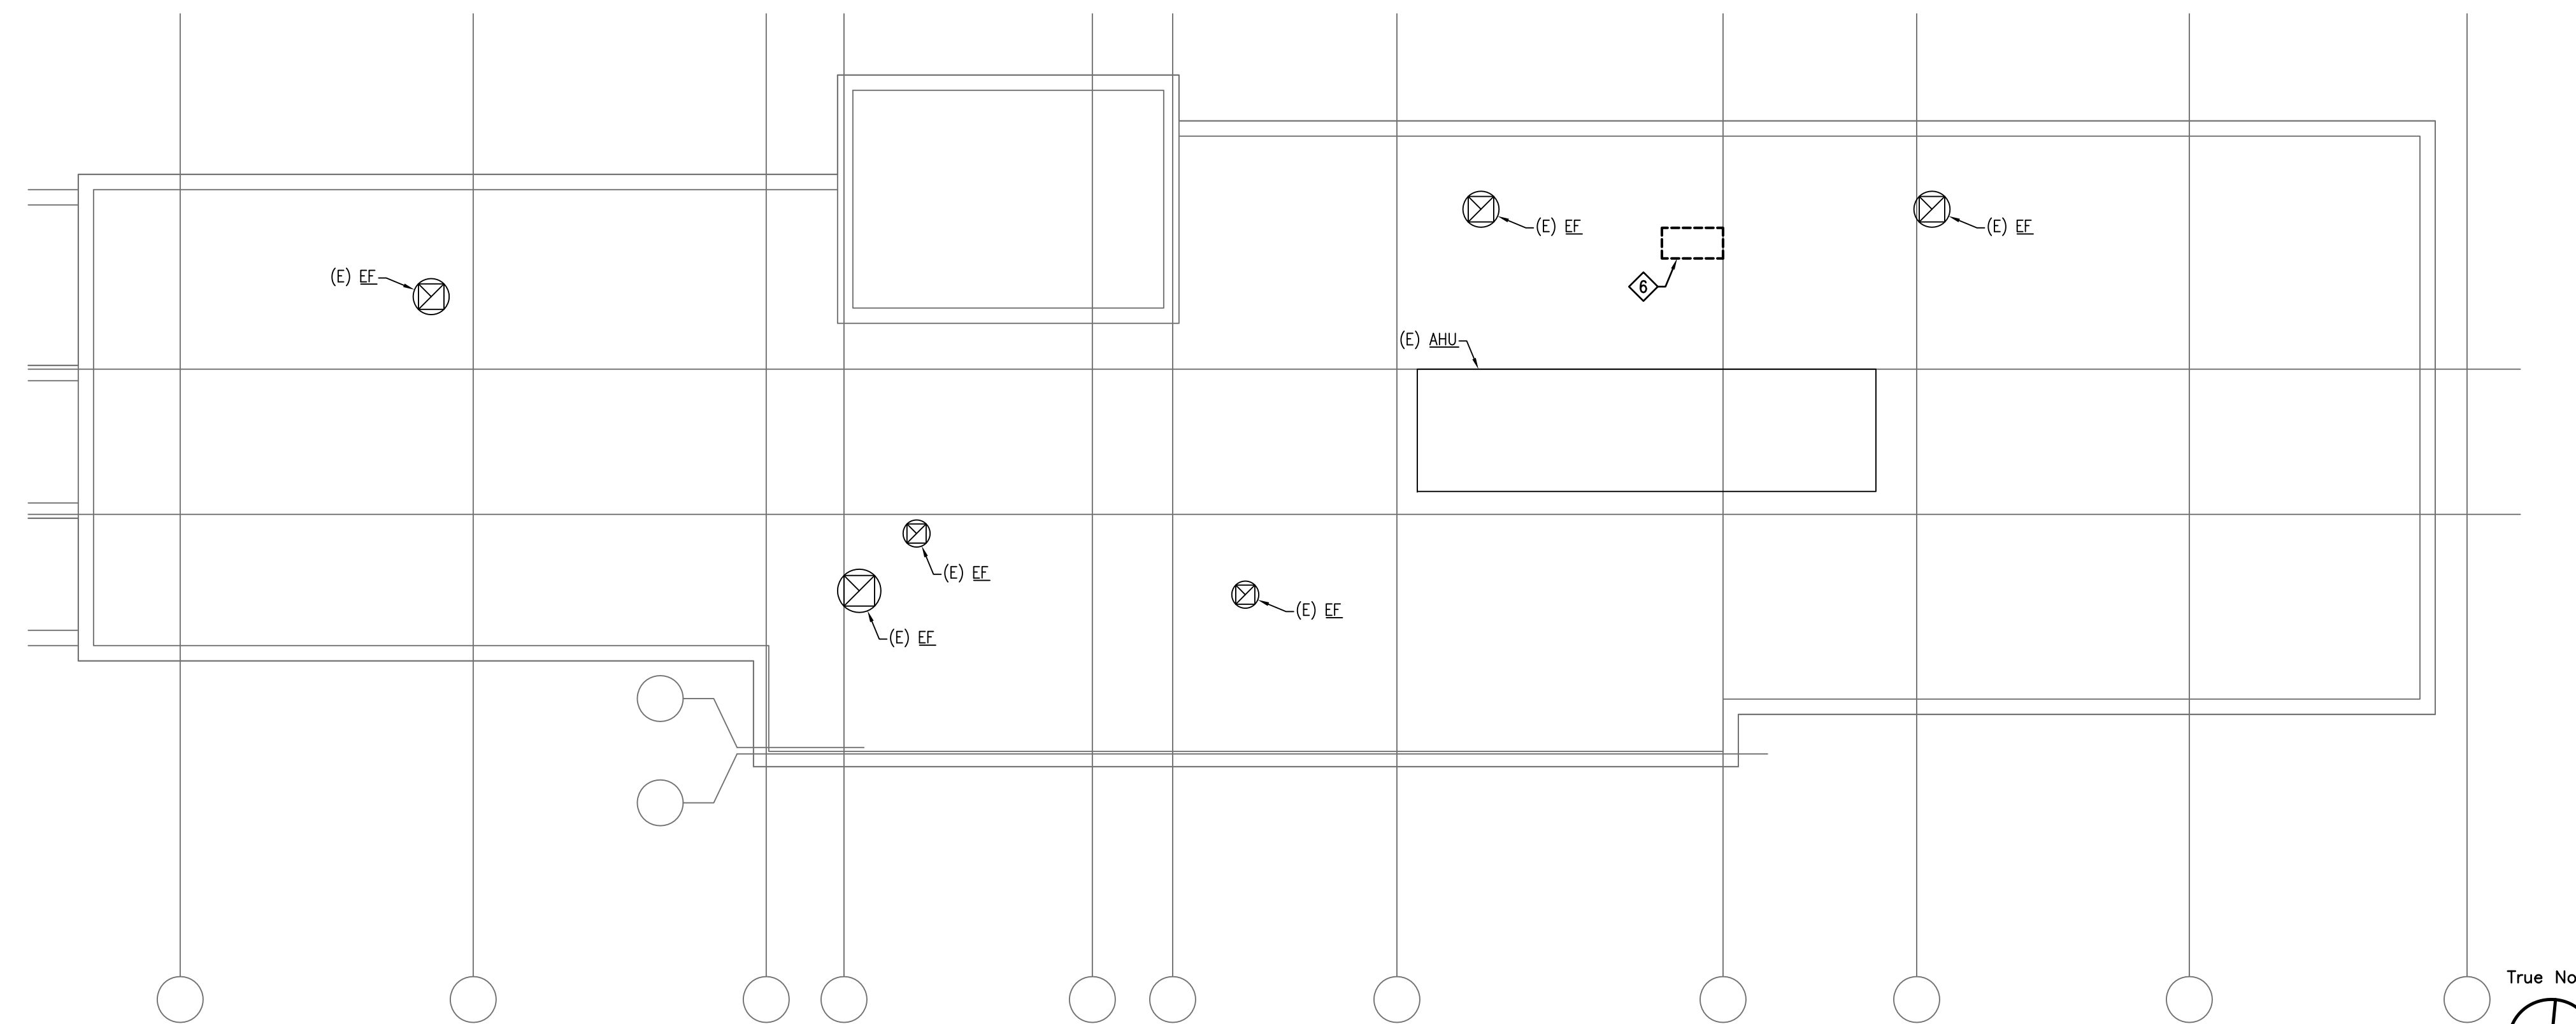

PAVILION "A"

