


Seals


BECKER
structural engineers, inc.

75 York Street Portland, ME 04101-4701
Tel 207-879-1838 Fax 207-879-1822
info@beckerstructural.com www.beckerstructural.com

Consultant

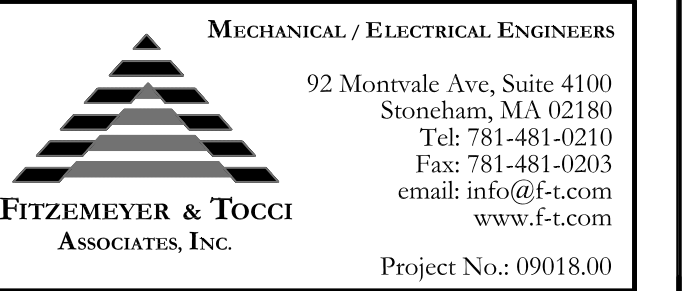

Consultant

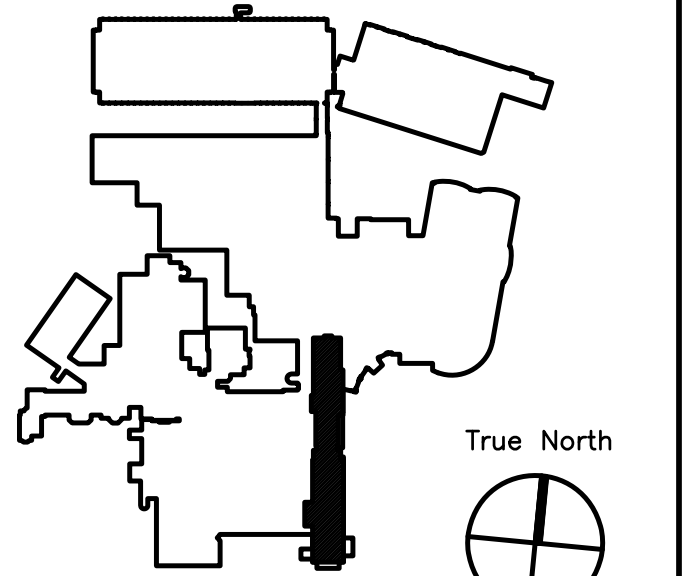

Key Plan N.T.S.

ADDENDUM#	Date	No
ADDENDUM#1	12/4/09	1
Revision		




Maine Medical Center
Portland, Maine

MAINE MEDICAL CENTER
PAVILION 6 RENOVATIONS

MorrisSwitzer Project Number 28034
Date 11/19/09
Scale 1/8" = 1'-0"
Sheet Title and Number

SIXTH FLOOR PAVILIONS "A" & "C" MECHANICAL NEW DUCTWORK PLAN


3M2.0

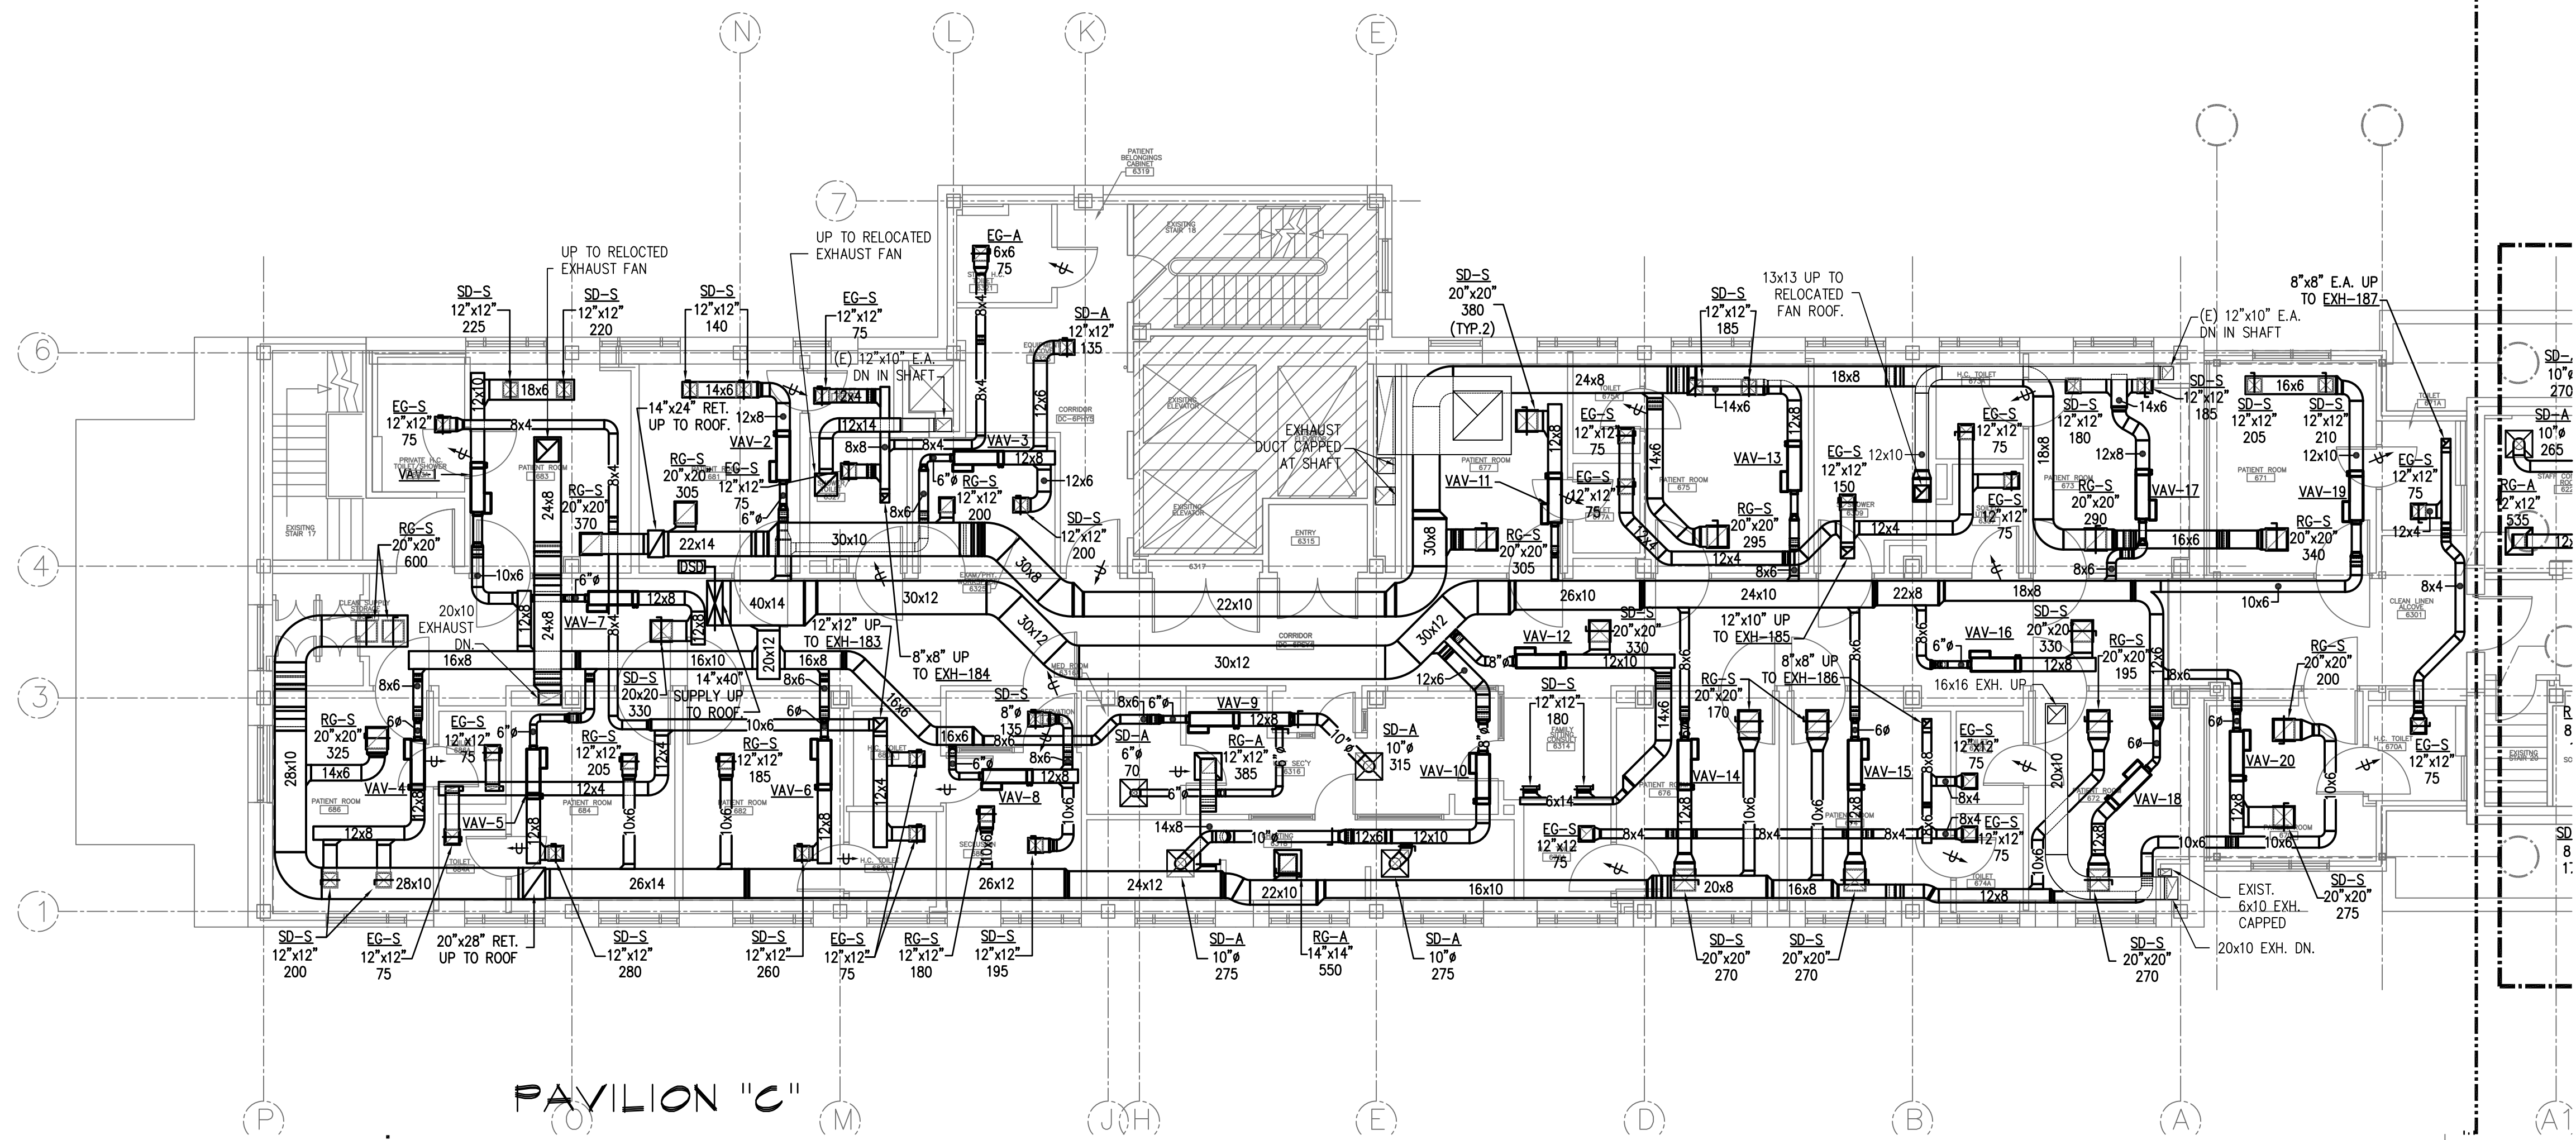

PAVILION "C"

MECHANICAL KEYNOTES

- 1 PROVIDE BID ALTERNATE (ALTERNATE #4) FOR ALL PAVILION "A" DUCTWORK, EQUIPMENT AND ACCESSORIES.
- 2 AREA OUT OF SCOPE. FUTURE WORK/EXPANSION.
- 3 CAP DUCTWORK FOR FUTURE EXPANSION.

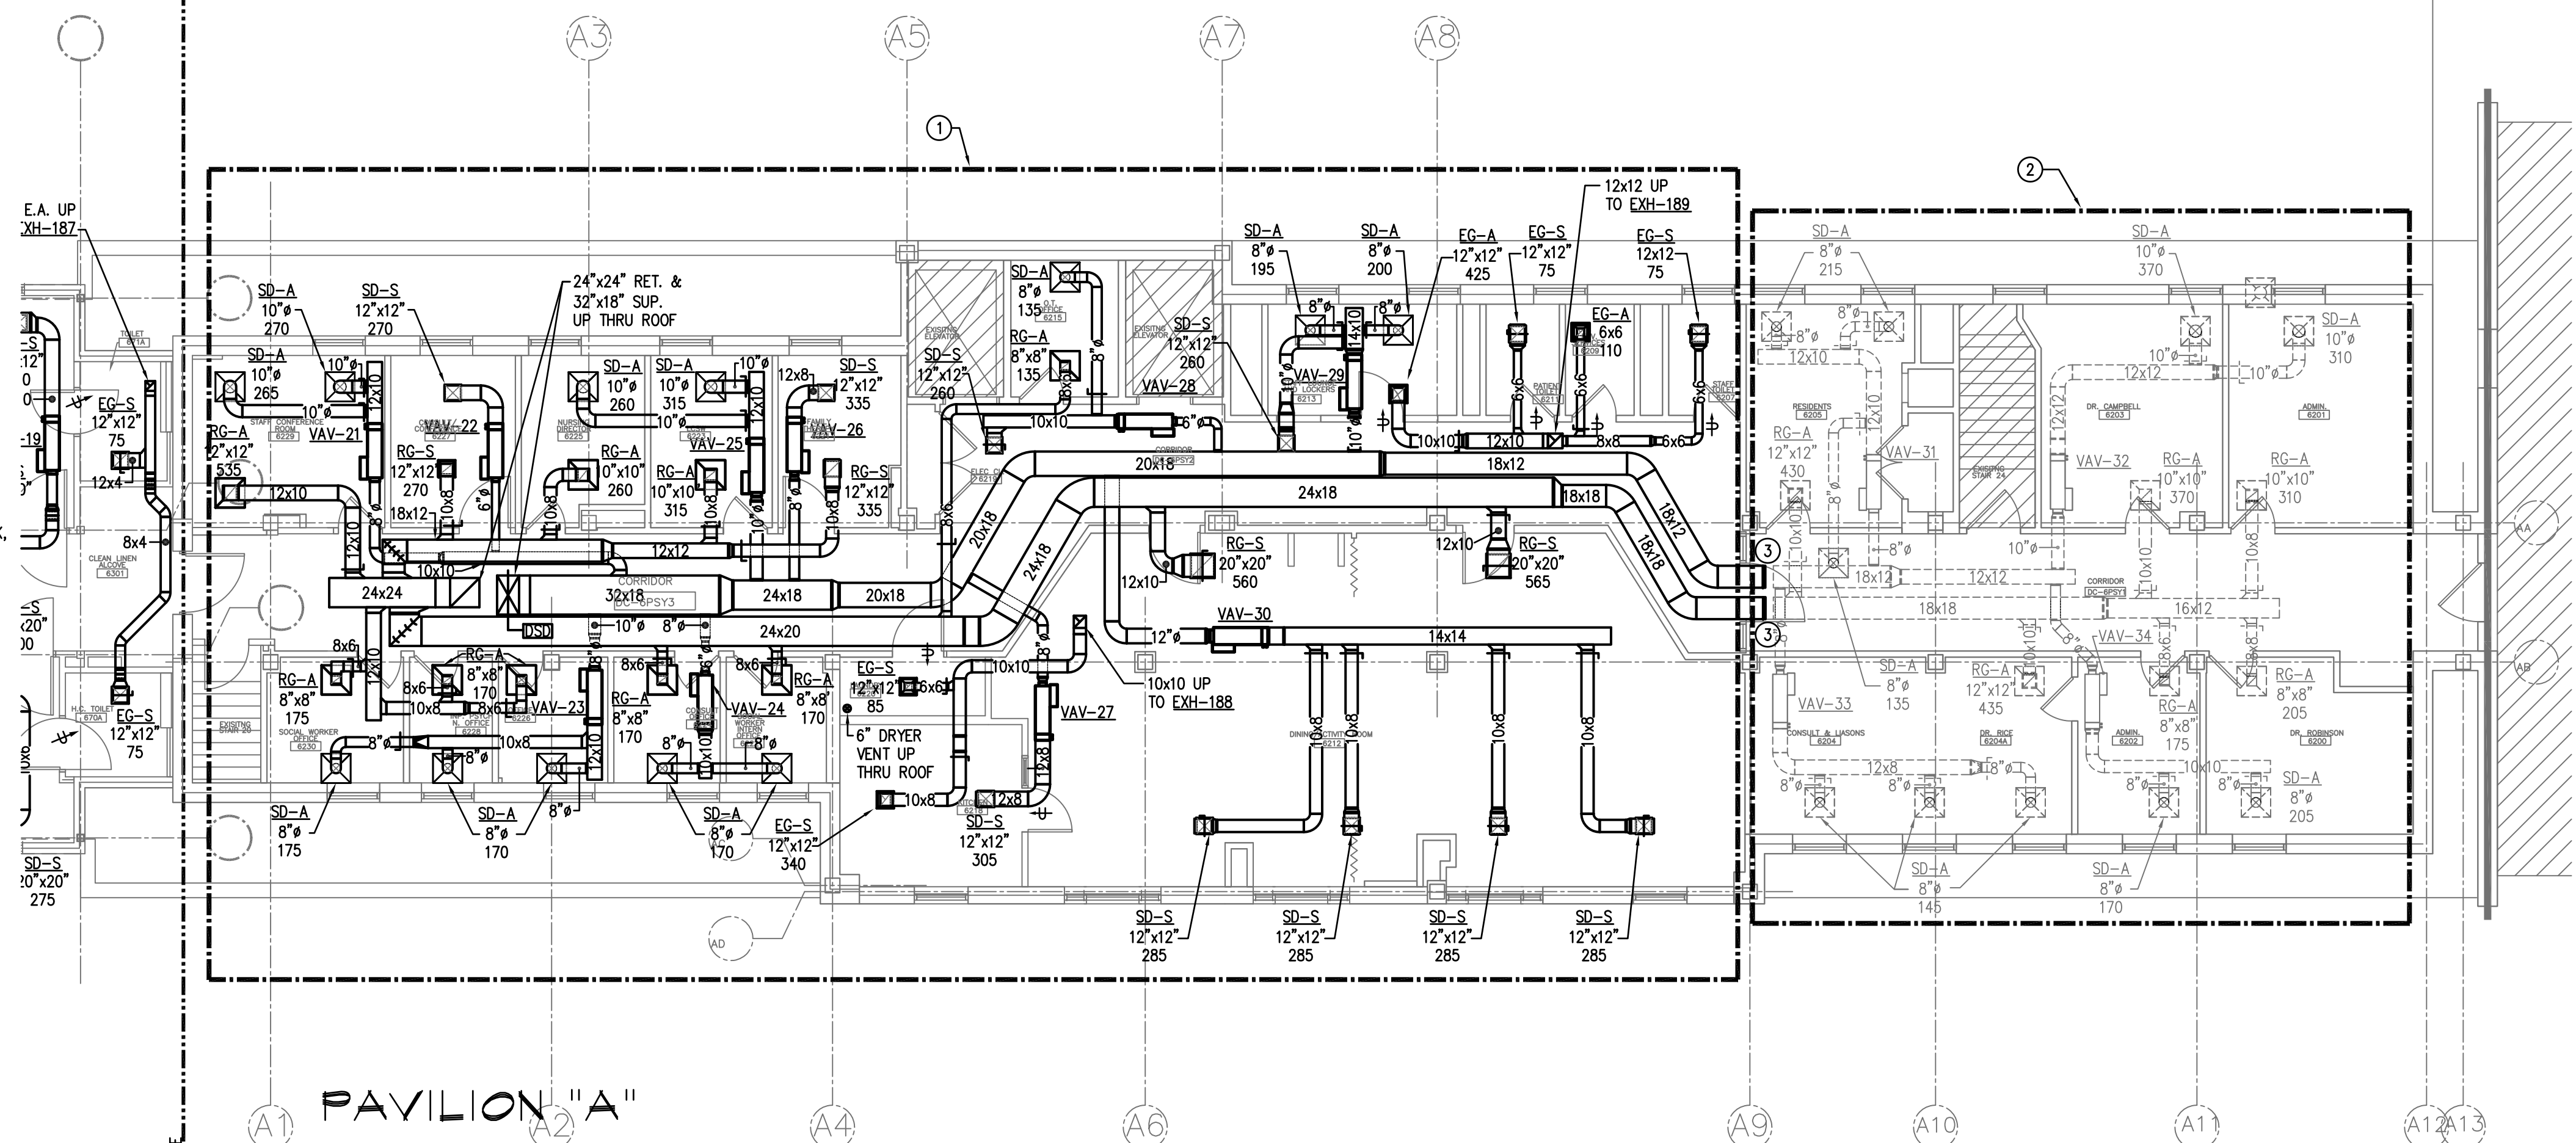

PAVILION "A"

True North

