



PAVILION "C"

- MECHANICAL KEYNOTES**
- ① PROVIDE BID ALTERNATE (ALTERNATE #4) FOR ALL PAVILION "A" PIPING, EQUIPMENT AND ACCESSORIES.
 - ② AREA OUT OF SCOPE. FUTURE WORK/EXPANSION.
 - ③ CAP PIPING FOR FUTURE EXPANSION.

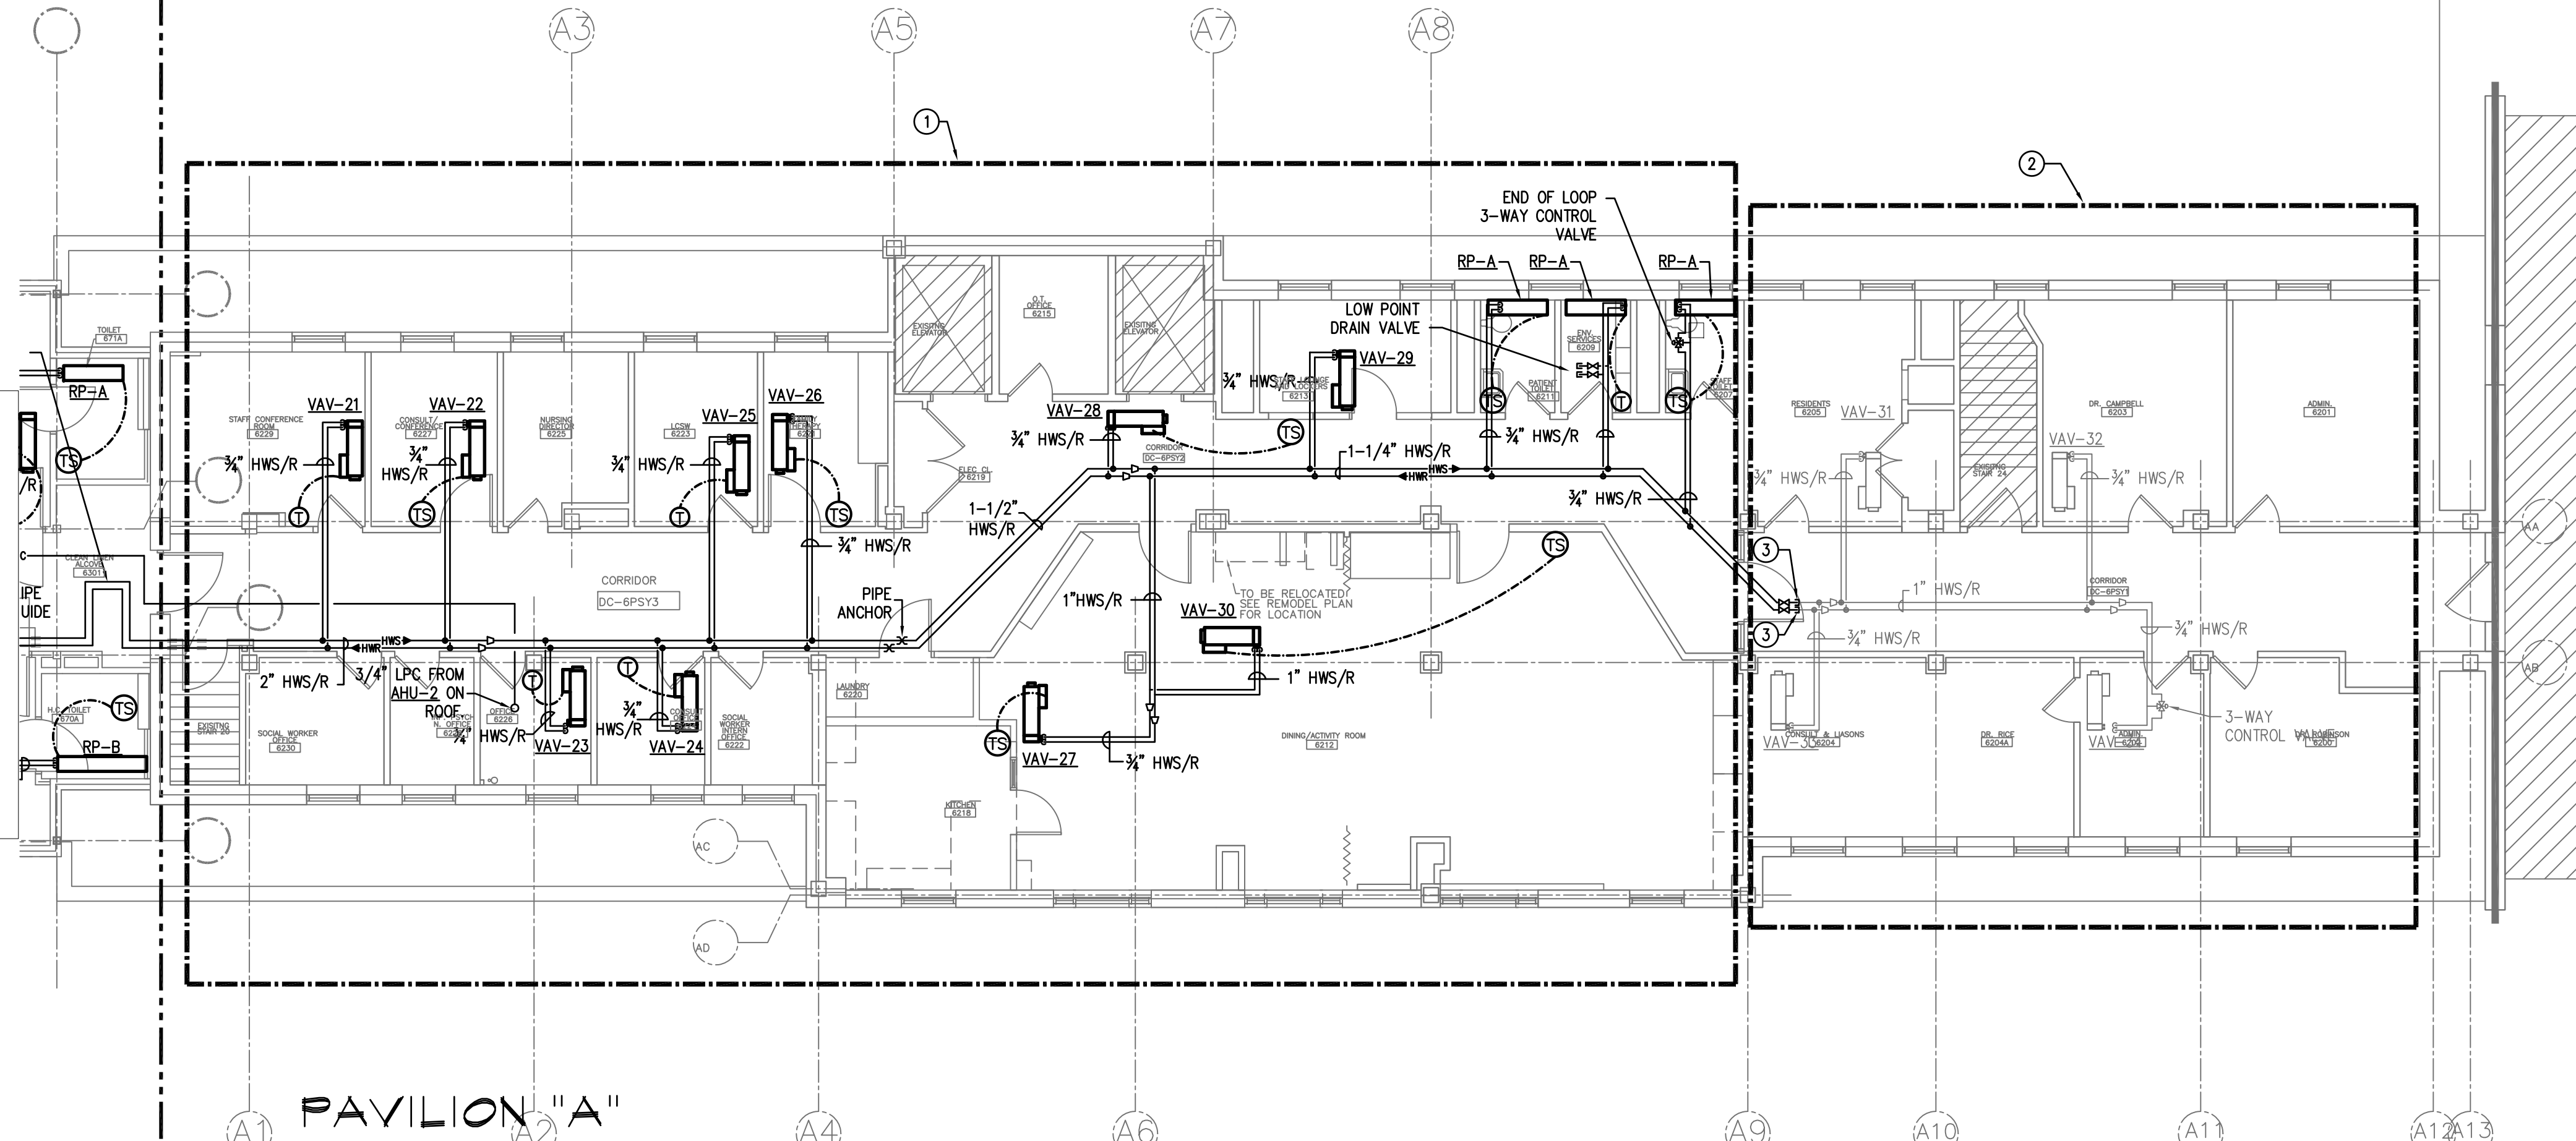

PAVILION "A"

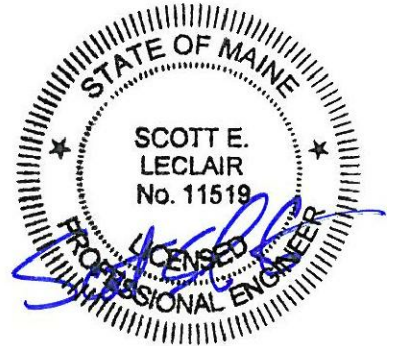

Seals

BECKER
structural engineers, inc.

75 York Street
Portland, ME 04101-4701
info@beckerstructural.com

Tel 207-879-1838
Fax 207-879-1822
www.beckerstructural.com

Consultant


MECHANICAL / ELECTRICAL ENGINEERS

92 Montvale Ave, Suite 4100
Snohomish, WA 98290
Tel: 781-481-0210
Fax: 781-481-0203
email: info@f-t.com
www.f-t.com

FITZMEYER & TOCCI
ASSOCIATES, INC.

Project No.: 09018.00

Consultant

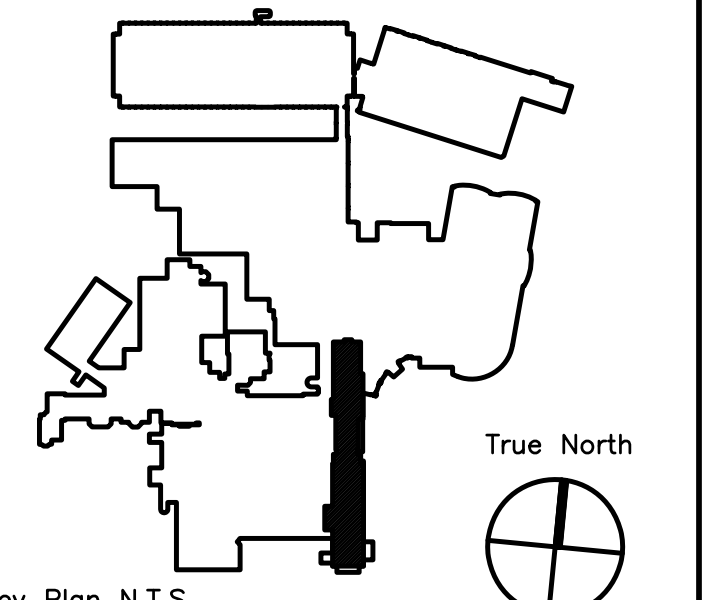

Key Plan N.T.S.

ADDENDUM#	Date	No
ADDENDUM#1	12/4/09	1
Revision	Date	No



MAINE MEDICAL CENTER
PAVILION 6 RENOVATIONS

MorrisSwitzer Project Number 28034
Date 11/19/09
Scale 1/8" = 1'-0"
Sheet Title and Number

SIXTH FLOOR PAVILIONS "A" & "C" MECHANICAL NEW PIPING PLAN
3M2.1

