


Seals


BECKER
structural engineers, inc.

75 York Street
Portland, ME 04101-4701
info@beckerstructural.com
Tel 207-879-1838
Fax 207-879-1822
www.beckerstructural.com

Consultant

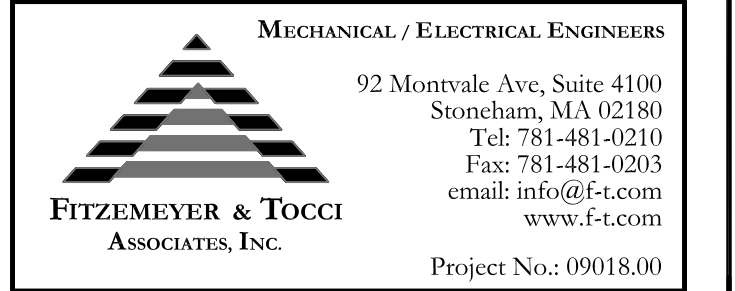

Consultant

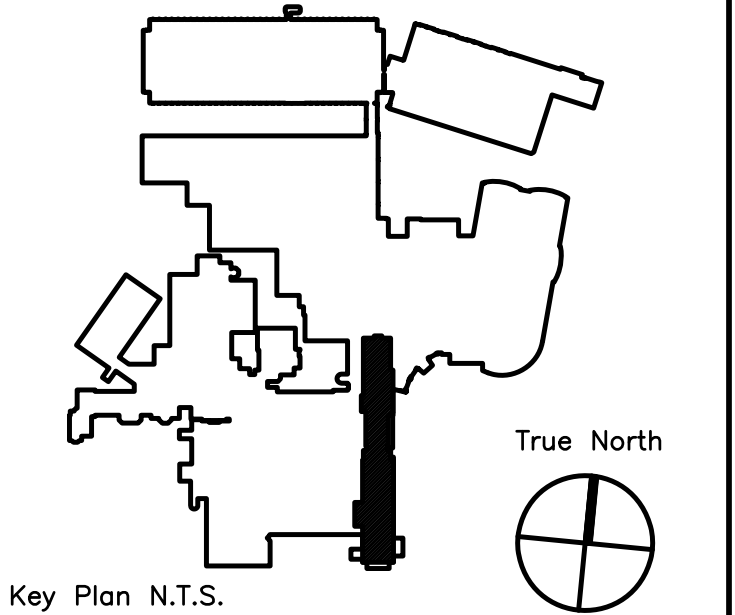

Key Plan N.T.S.

ADDENDUM#	Date	No
ADDENDUM#1	12/4/09	1
Revision	Date	No




Maine Medical Center
Portland, Maine

MAINE MEDICAL CENTER
PAVILION 6 RENOVATIONS


MorrisSwitzer Project Number 28034
Date 11/19/09
Scale 1/8" = 1'-0"
Sheet Title and Number

SIXTH FLOOR PAVILIONS "A" & "C" MECHANICAL NEW WORK ROOF PLAN

3M2.2

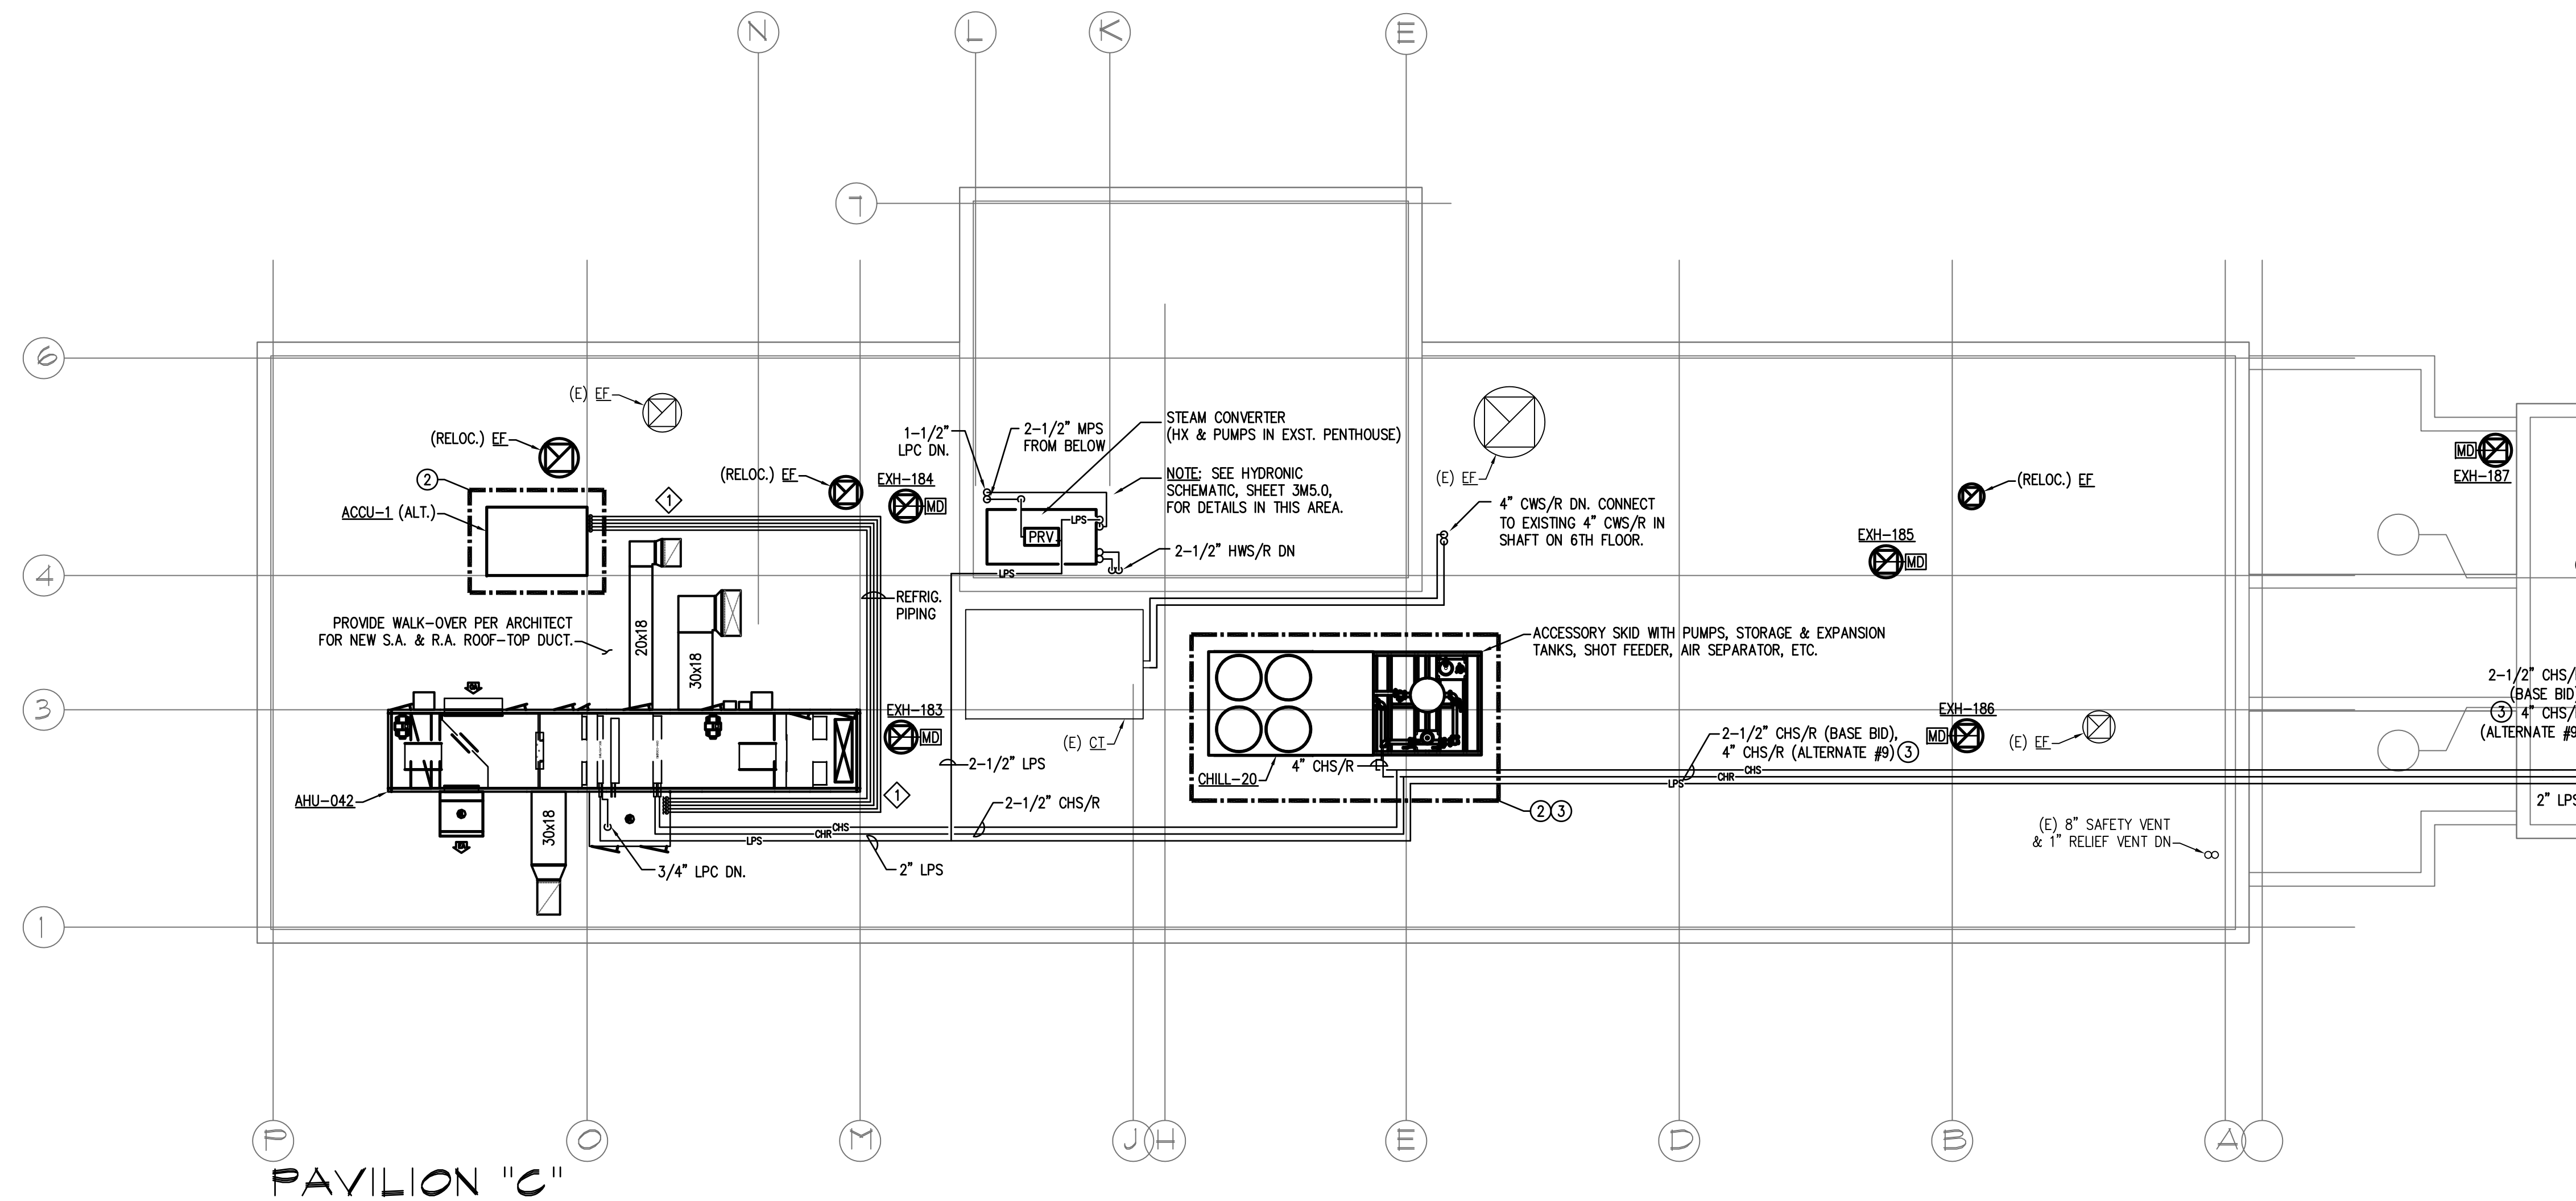

PAVILION "C"

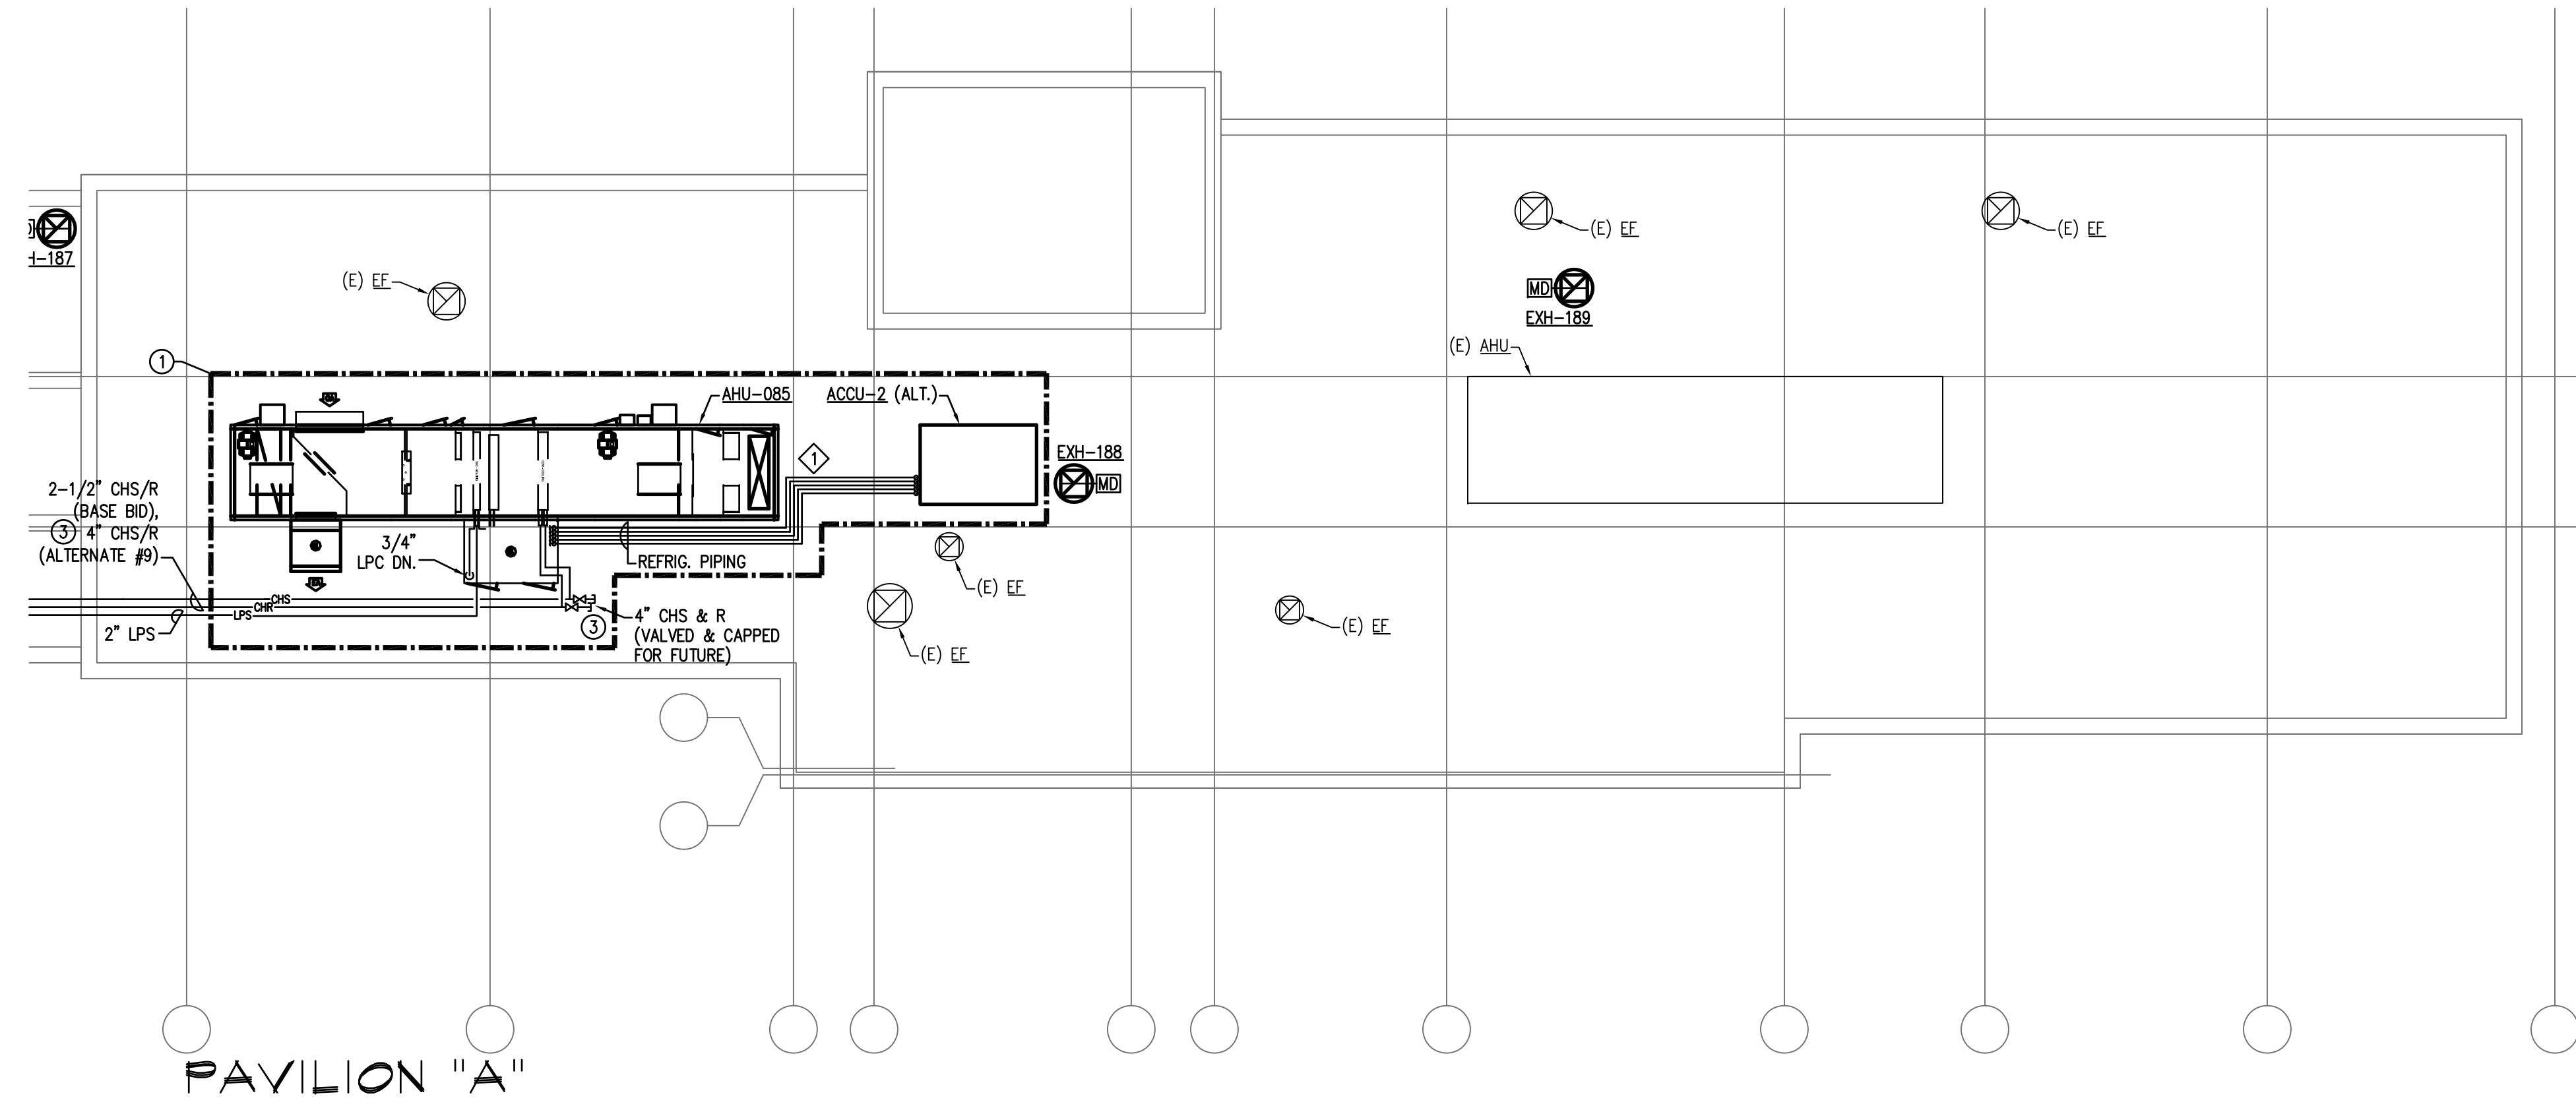

PAVILION "A"

