


Seals


**BECKER**  
structural engineers, inc.

75 York Street Portland, ME 04101-4701  
info@beckerstructural.com www.beckerstructural.com  
Tel: 207-879-1838 Fax: 207-879-1822

Consultant

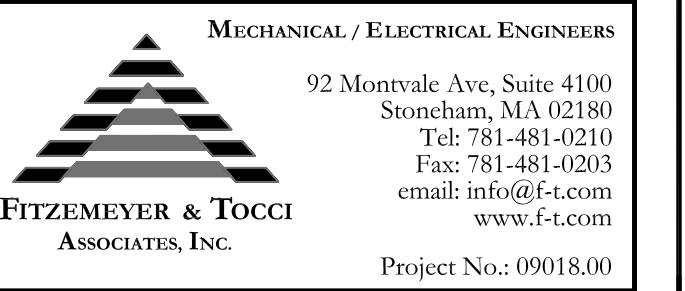

Consultant

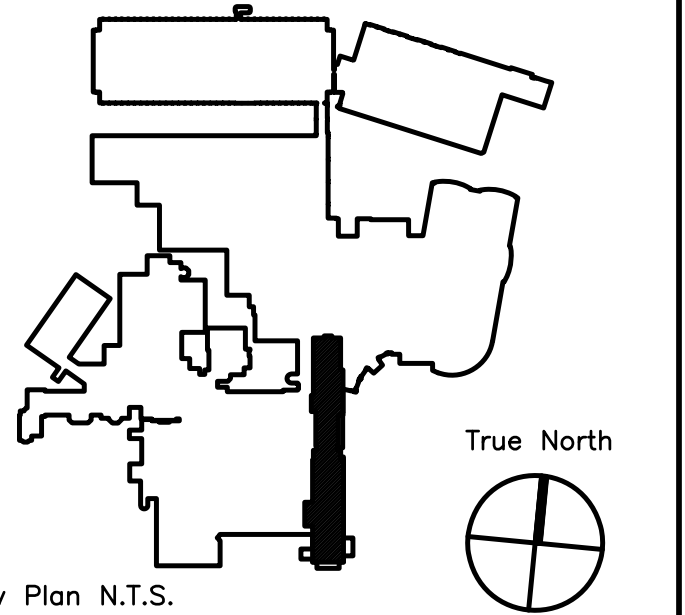

Key Plan N.T.S.

ADDENDUM#	Date	No
1	12/4/09	1
Revision	Date	No




**Maine Medical Center**  
Portland, Maine

**MAINE MEDICAL CENTER**  
PAVILION 6 RENOVATIONS


MorrisSwitzer Project Number 28034  
Date 11/19/09  
Scale N.T.S.  
Sheet Title and Number

**MECHANICAL HYDRONIC SCHEMATIC & INTER.**  
4th/5th FLOOR PLAN

**3M5.0**

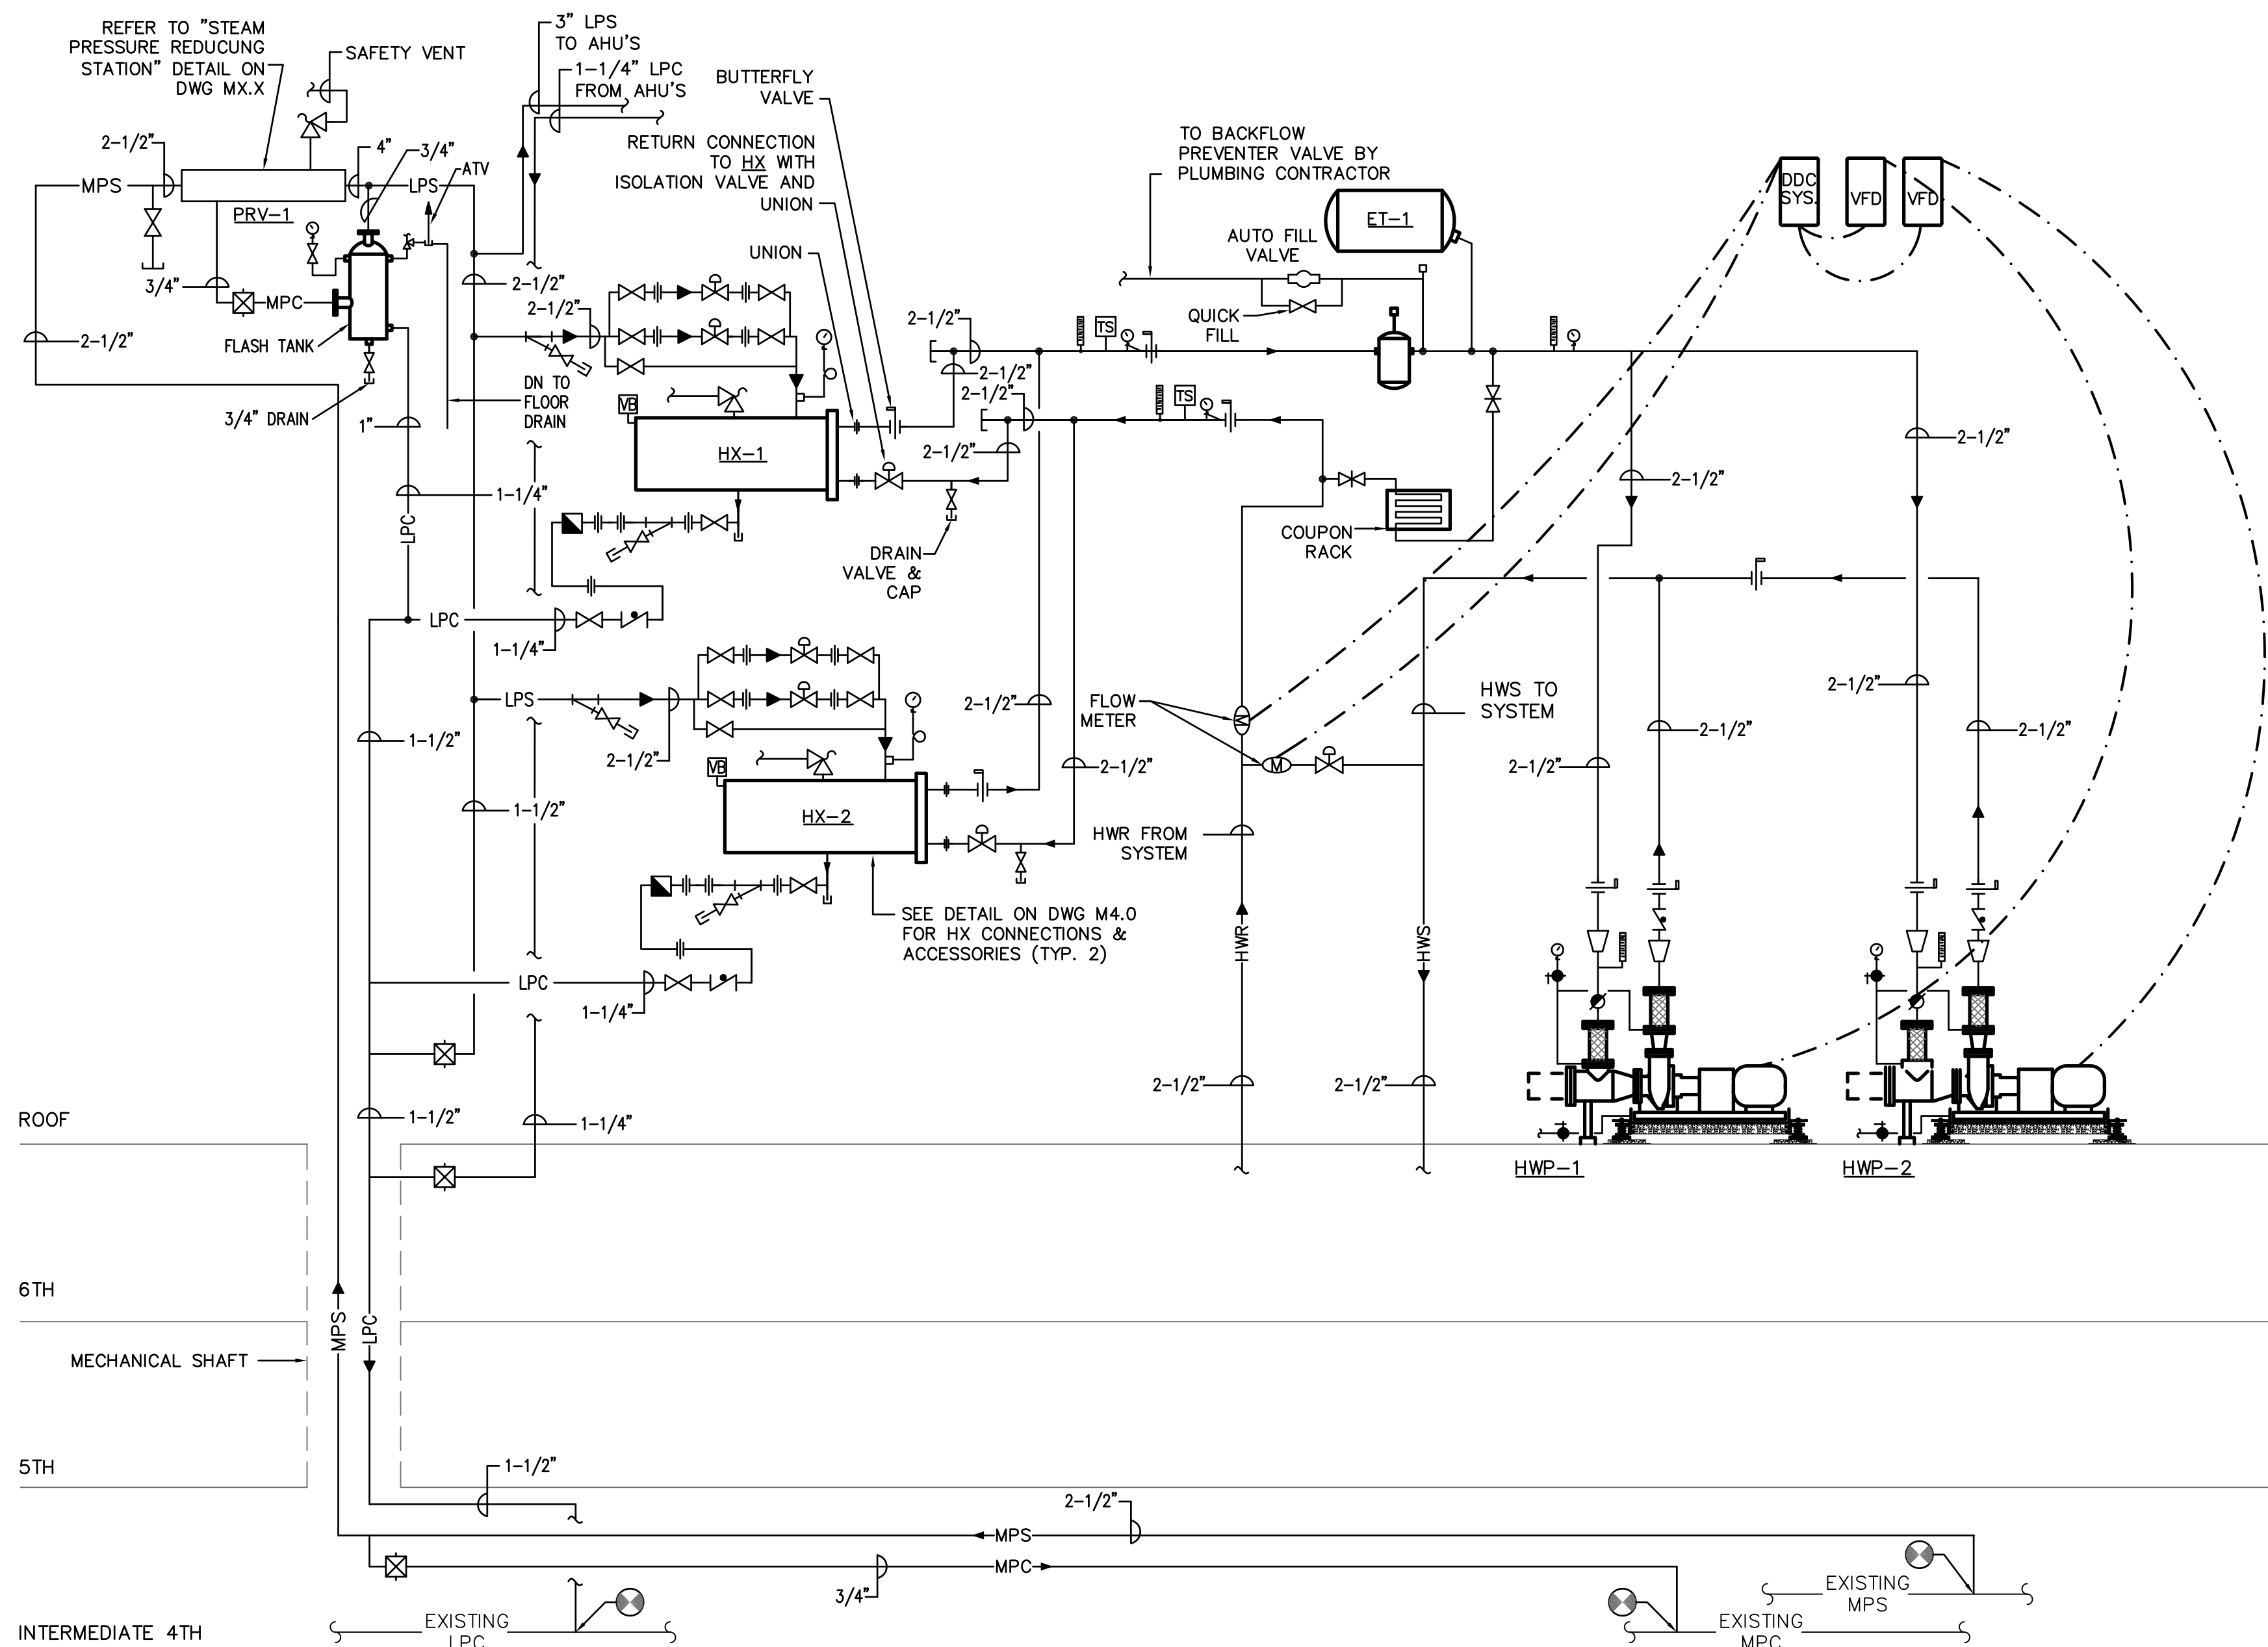

1 HYDRONIC SCHEMATIC  
- N.T.S.

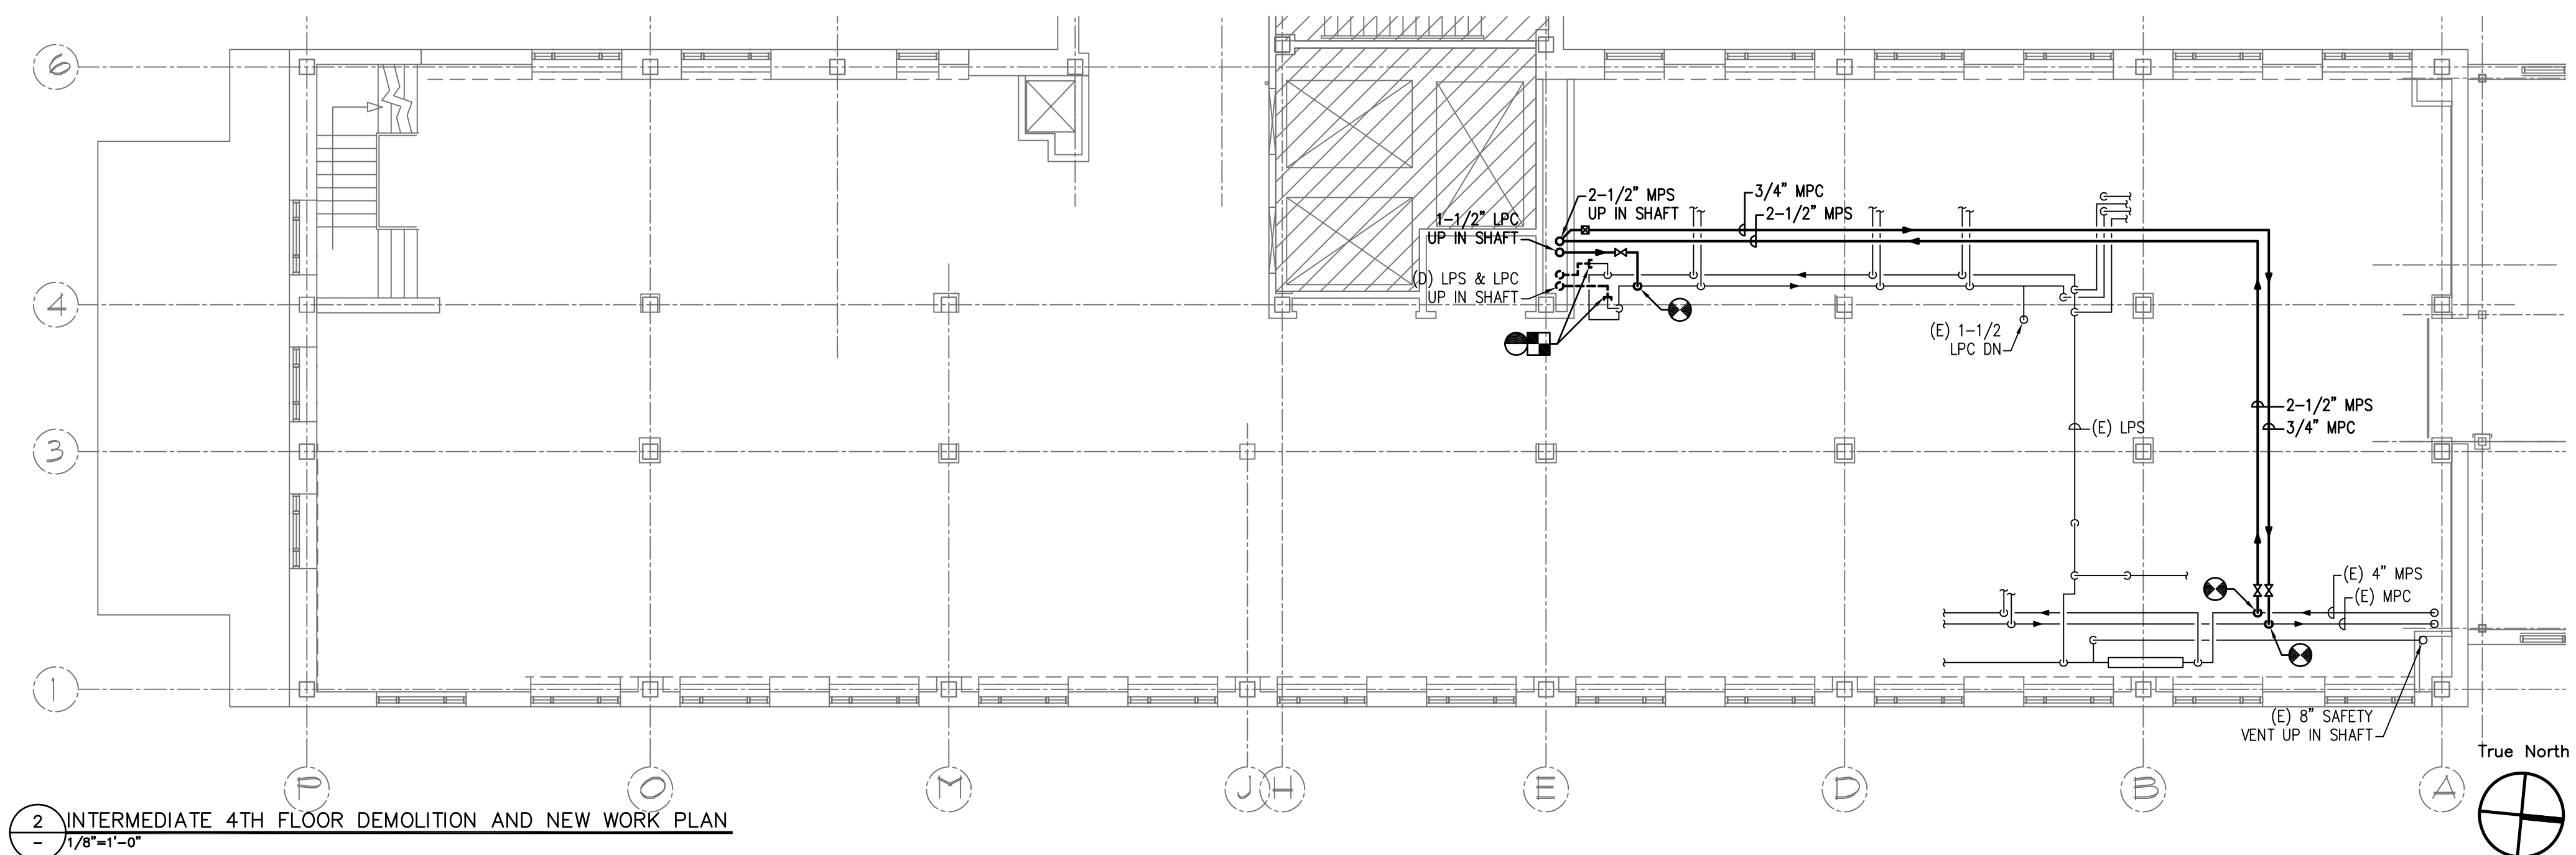

2 INTERMEDIATE 4TH FLOOR DEMOLITION AND NEW WORK PLAN  
- 1/8"=1'-0"