

LEGEND:

- EXISTING UPRIGHT SPRINKLER ON A BRANCH LINE
- ⊙ EXISTING CONCEALED PEND. SPRINK. (ONT SYSTEMS OPERATING ROOM) ON A 1" BRANCH LINE
- ⦿ EXISTING CONCEALED PEND. SPRINK. (ONT SYSTEMS OPERATING ROOM) ON A 1" BRANCH LINE
- NEW CONCEALED PENDENT SPRINKLER ON A 1" DRIP.
- EXISTING RECESSED PENDENT SPRINKLER ON A 1" DRIP.
- TO BE REPLACED WITH A NEW CONCEALED PENDENT SPRINKLER
- ROOF OR DRIP
- GROOVED COULMING
- Ⓖ CEILING HEIGHT
- EXISTING SPRINKLER PIPING
- FINISHED FLOOR TO PIPE CENTERLINE
- Ⓕ— BOTTOM OF JOIST TO PIPE CENTERLINE
- Ⓖ— CEILING TO PIPE CENTERLINE
- CONCRETE DECK TO PIPE CENTERLINE

GENERAL NOTES:


ALL THREADED PIPE IS TO BE SCH. 40 BLACK STEEL U/N.
 ALL THREADED PIPE FITTINGS ARE TO BE BLACK CAST IRON CLASS 125 U/N.
 DIMENSIONS SHOWN ON THREADED PIPE ARE CENTER TO CENTER U/N.
 DIMENSIONS SHOWN ON GROOVED PIPE ARE "OUT" LENGTHS U/N.
 PENDENT SPRINKLERS IN ACOUSTIC TILE CEILINGS ARE TO BE LOCATED IN THE CENTER OF GRIDING. THE BOTTOMS OF SPRINKLERS IN ACOUSTIC TILE CEILINGS ARE TO BE IDENTIFIED BY THE WT SPRINKLER SYSTEM IS REQUIRED TO BE FINISHED BY THE BUYER/OWNER.

SYSTEM CLASSIFICATION:

A WET PIPE SYSTEM WITH A STANDBY PUMP ROOM, WORKING TO BRING TO CODE WITH THE NEW CONSTRUCTION BEING DONE. ALL TO BE IN ACCORDANCE WITH NFPA-13, STANDARD FOR THE INSTALLATION OF SPRINKLER SYSTEMS, 2007 EDITION.

SCOPE OF WORK:

RELOCATE 20 SPRINKLERS, ADD 1, AND REMOVE (PLUG) 6 SPRINKLERS ON THE EXISTING SYSTEM. ALL WORK TO BE DONE IN ACCORDANCE WITH NFPA-13, STANDARD FOR THE INSTALLATION OF SPRINKLER SYSTEMS, 2007 EDITION. JUST OUTSIDE THE STAIR TOWER #24 IN CORRIDOR. ALL EXISTING RECESSED SPRINKLERS ARE TO BE REPLACED WITH NEW CONCEALED TYPE SPRINKLERS.

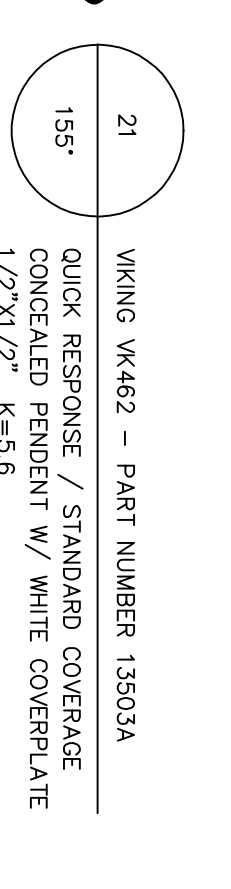

DRAWING TITLE		DATE		SCALE		SHEET NO.		REV.	
IN-PATIENT SERVICES		11/17/08		1/8" = 1'-0"		OF 1		0	0
DEAN & ALLYN, INC. FIRE PROTECTION - SPECIAL HAZARD		DANA A. STEWART NICOLE IV - #064544		JTB		JTB		MMC-2ND FLOOR BEAN BLDG 22 BRAHMAHALL STREET PORTLAND, MAINE	
(20) 957-5646 FAX: (20) 957-5647		RJV 11/17/08		RJV 11/17/08		RJV 11/17/08		REV. SPRINK-20 NO. OF SPRINKLERS 1 3 3	
CONTRACT WITH LANGRISH & LOW CONSTRUCTION CO INC 598 WARKEN AVE - PORTLAND, ME 04108		RJV 12/1/08		RJV 12/1/08		RJV 12/1/08		CONTRACT NO. C0810824	
RJV 12/1/08		RJV 12/1/08		RJV 12/1/08		RJV 12/1/08		REV. 0	
RJV 12/1/08		RJV 12/1/08		RJV 12/1/08		RJV 12/1/08		REV. 0	
RJV 12/1/08		RJV 12/1/08		RJV 12/1/08		RJV 12/1/08		REV. 0	
RJV 12/1/08		RJV 12/1/08		RJV 12/1/08		RJV 12/1/08		REV. 0	
RJV 12/1/08		RJV 12/1/08		RJV 12/1/08		RJV 12/1/08		REV. 0	