


1 | ROOF DECK ELECTRICAL PLAN
SCALE: 1/16" = 1' - 0"

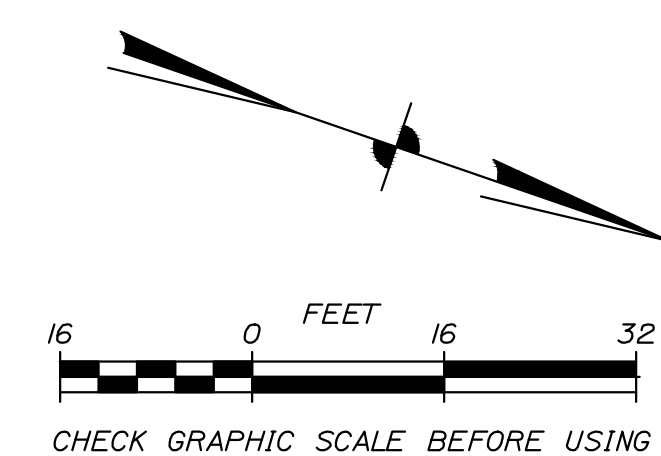

NOT FOR CONSTRUCTION
LEVEL III SITE PLAN APPLICATION
6/22/18

Sheet No.	
Date	
Issued For	
Approt	

222 ST. JOHN ST PG
PORTLAND, ME
ROOF DECK ELECTRICAL PLAN

Designed LEB	Scale 1" = 16'-0"
Drawn LEB	Date 06/22/18
Checked LEB	Becker Job Number 4070

E1.4