



1 | ELECTRICAL AND LIGHTING SITE PLAN
SCALE: 1" = 20' - 0"

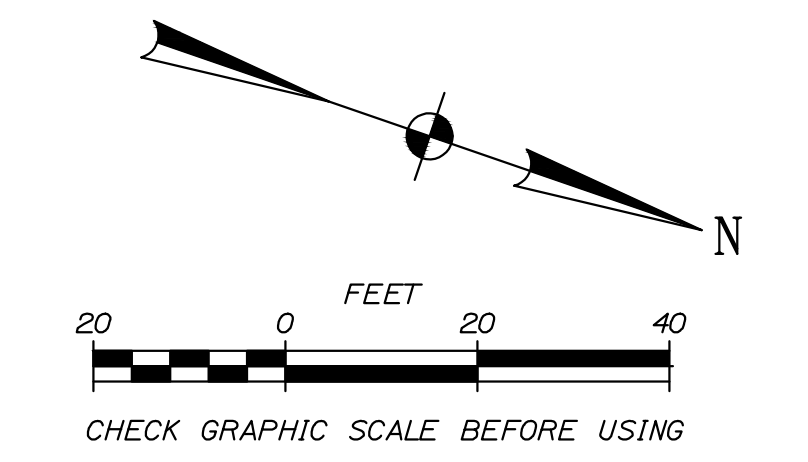

NOT FOR CONSTRUCTION
LEVEL III SITE PLAN SUBMISSION
07/24/18

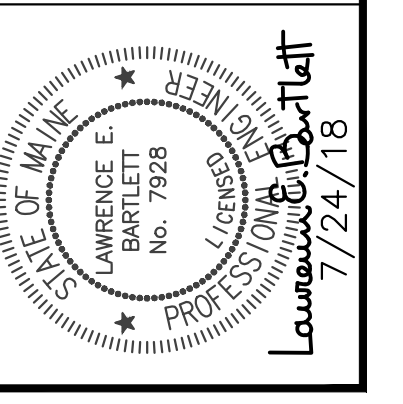

Project No.	
Client	
Date	
Drawn By	
Checked By	
Approved For	

222 ST. JOHN ST PG
PORTLAND, ME
ELECTRICAL SITE PLAN - 2

Designed LEB	Scale 1" = 20'-0"
Drawn LEB	Date 7/16/18
Checked LEB	Checker Job Number 4070

E1.2