



NOTES:
 1. ALL WORK SHOWN SHALL BE QUOTED UNDER AN ALTERNATE BID. INFORMATION SHOWN IS FOR PRICING ONLY AND NOT FOR CONSTRUCTION.

OFF-SITE PROJECT IMPROVEMENTS:
 NEW SIDEWALK ALONG D STREET
 NEW CROSSWALK AT THE INTERSECTION OF D STREET AND VALLEY STREET
 NEW CROSSWALK AT THE INTERSECTION OF C STREET AND VALLEY STREET

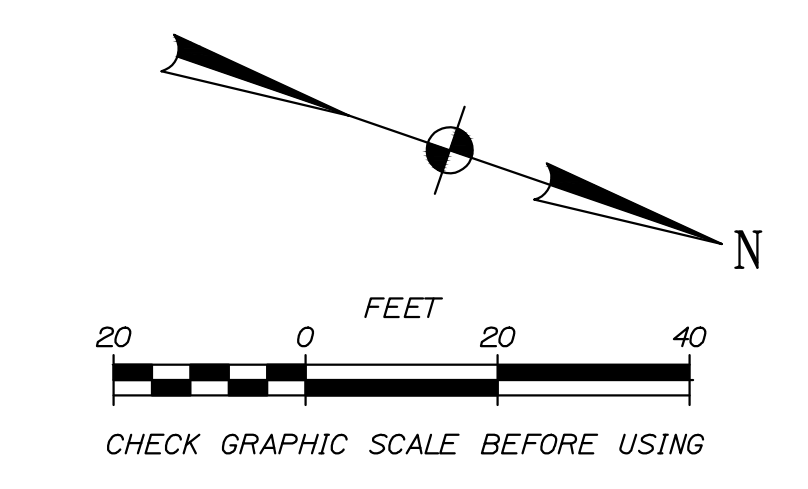

1 | ELECTRICAL AND LIGHTING SITE PLAN
 SCALE: 1" = 20' - 0"

NOT FOR CONSTRUCTION
 LEVEL III SITE PLAN SUBMISSION
 07/24/18

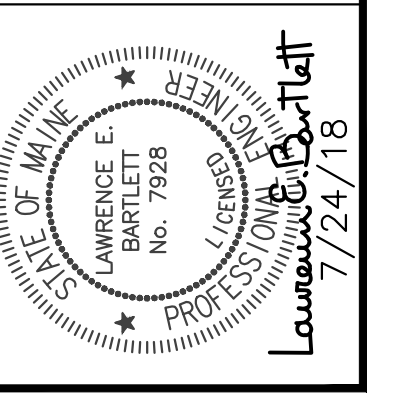

Project No.	
Client	
Date	
Drawn By	
Checked By	

222 ST. JOHN ST PG
 PORTLAND, ME
 ELECTRICAL SITE PLAN - 3

Designed LEB	Scale 1" = 20'-0"
Drawn LEB	Date 7/16/18
Checked LEB	Checker Job Number 4070

E1.3