


41 Hutchins Drive
Portland, Maine 04102
800.426.4362 | www.woodardcurran.com

WOODARD & CURRAN

COMMITMENT & INTEGRITY DRIVE RESULTS

PROFESSIONAL SEAL OF DAVID A. SENUS, P.E., PROFESSIONAL ENGINEER, LICENSE NO. 10001, STATE OF MAINE, EXPIRES 12/31/2018

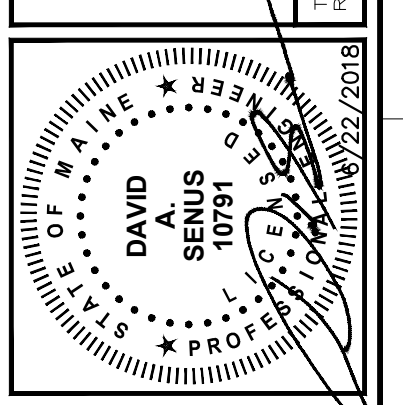

NO.	DESCRIPTION	DATE	BY	CHKD.
1	RESPONSE TO COMMENTS SUBMISSION	1/24/2018		
2	DESIGNED BY: DAS			
3	DRAWN BY: BCW			
4	CHECKED BY: DAS			


SITE LAYOUT & MATERIALS PLAN - 2

MAINE MEDICAL CENTER
BRANFILL STREET
PORTLAND, ME 04102

**MHC ST. JOHN STREET
EMPLOYEE PARKING GARAGE**

JOB NO: 0231158.00
DATE: LINE 22, 2018
SCALE: 1"=20'
SHEET: 5 OF 17

C-101

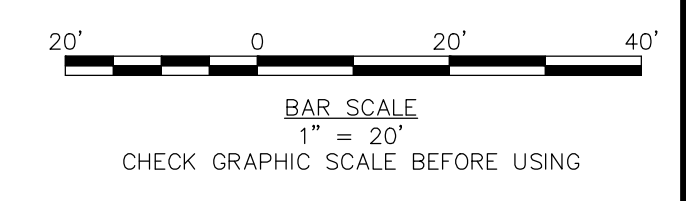

LEVEL III SITE PLAN APPLICATION - NOT FOR CONSTRUCTION