


STRUCTURE TABLE

NAME	DIA.	RIM	SUMP DEPTH	INV IN/SIZE/FROM	INV OUT/SIZE/TO
OIL WATER SEP.	4'	25.99	0'	18.50/6"S/GAR.	18.40/6"S/PUMP ST.
PUMP ST.	4'	28.20	0'	17.99/6"S/OIL WATER SEP.	25.00/2"FM/VALVE BOX
SMH1	4'	38.99	0'	35.00/2"FM/VALVE BOX	34.90/6"S/MAIN
VALVE BOX	2'X2'	27.50	0'	25.00/2"FM/PUMP ST.	25.00/2"FM/SMH1

PIPE TABLE

PIPE NAME	SIZE	LENGTH	SLOPE
FM1	2" FM	2'	N/A*
FM2	2" FM	133'	N/A*
PIPE S1	6" S	42'	0.0050
PIPE S2	6" S	61'	0.0063
PIPE S4	6" S	32'	0.1157

*SLOPE BACK TO PUMP STATION

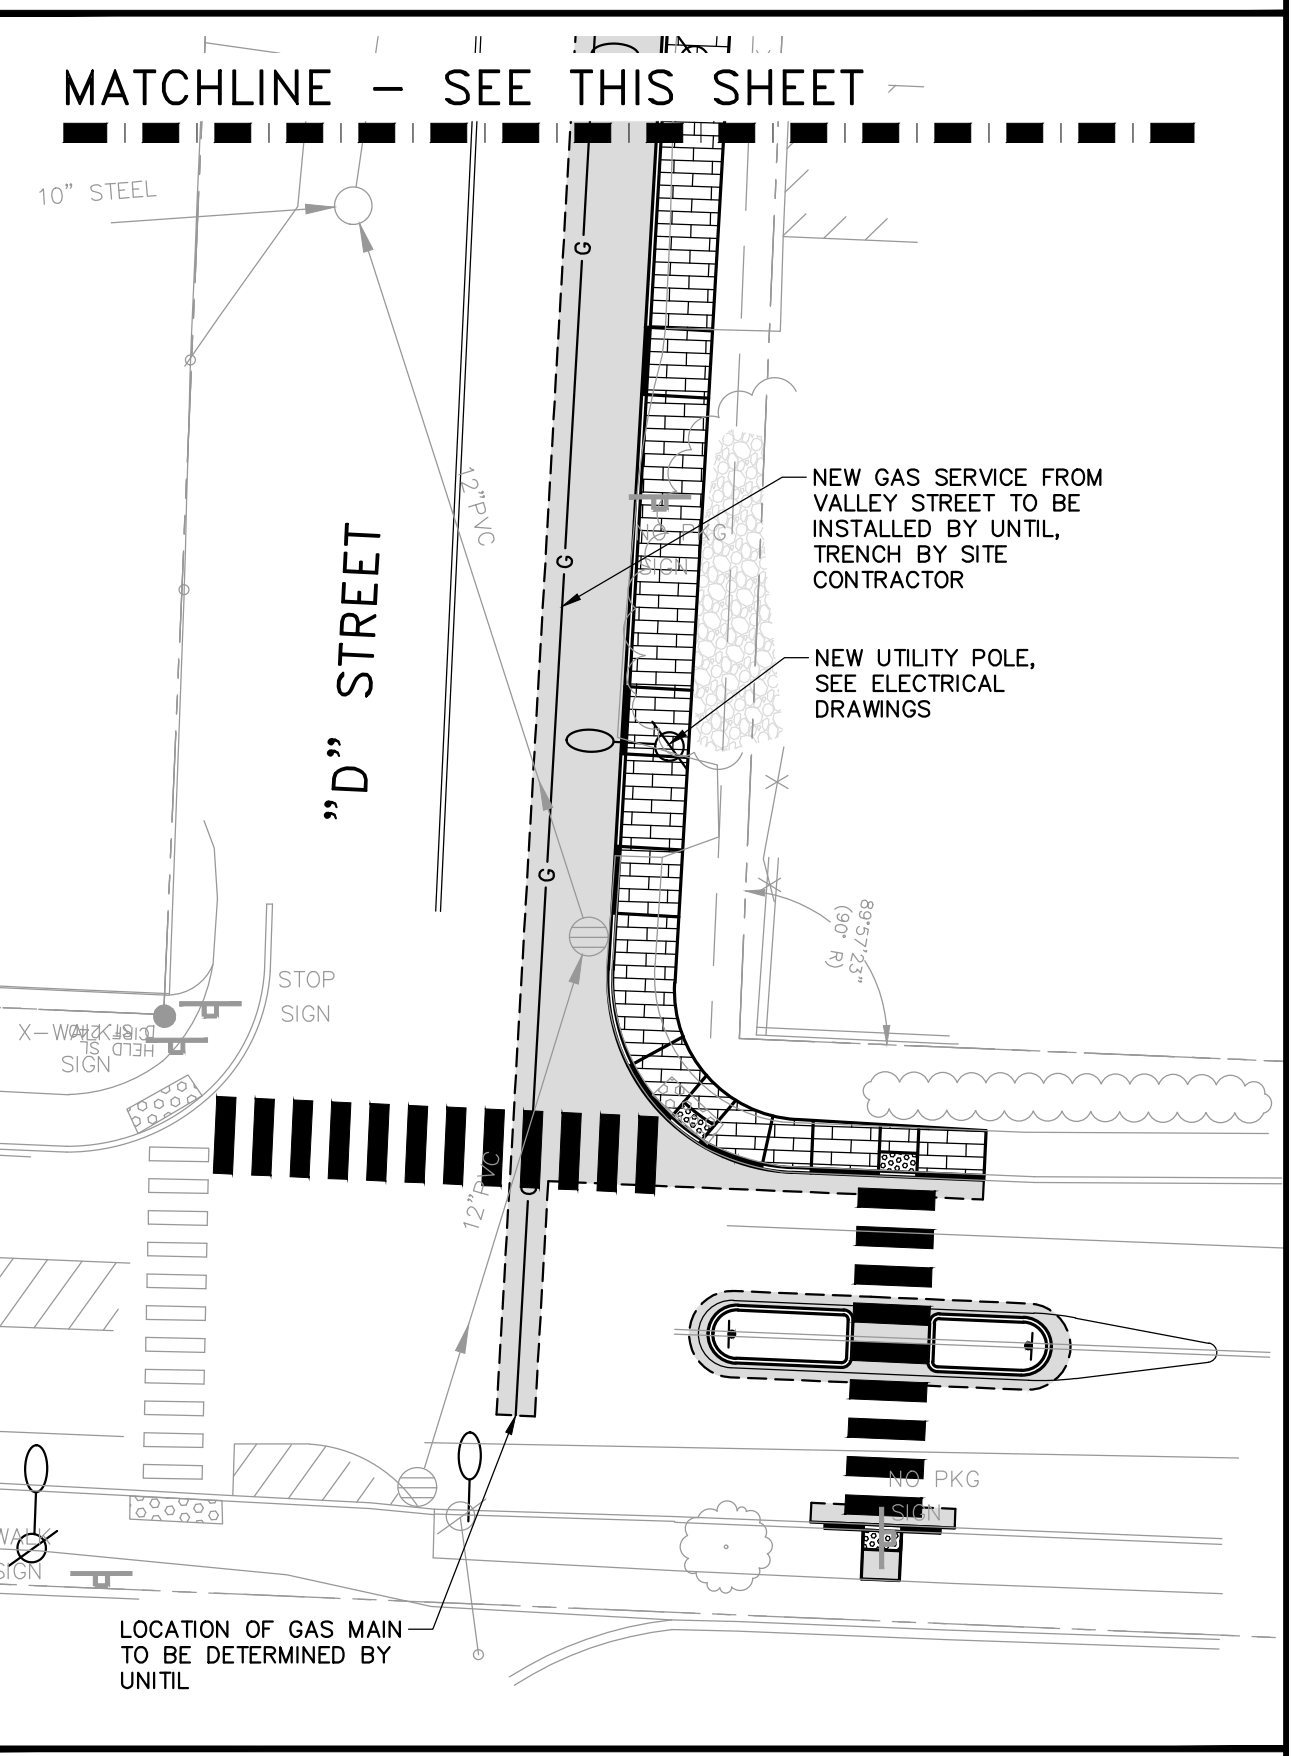

41 Hutchins Drive
Portland, Maine 04102
800.426.4362 | www.woodwardcurran.com

WOODWARD & CURRAN
COMMITMENT & INTEGRITY DRIVE RESULTS

DAVID A. SENUS
REGISTERED PROFESSIONAL ENGINEER
REPRODUCTION OR MODIFICATION OF ANY PART OF THIS DRAWING WITHOUT THE WRITTEN PERMISSION OF WOODWARD & CURRAN IS PROHIBITED.

NO.	DESCRIPTION	DATE	BY	CHKD.
1	RESPONSE TO COMMENTS SUBMISSION	1/24/2018		

DESIGNED BY: GMS
DRAWN BY: BOU
CHECKED BY: DAS

UTILITY PLAN - 1

MMCS ST. JOHN STREET EMPLOYEE PARKING GARAGE

MAINE MEDICAL CENTER
BRANFILL STREET
PORTLAND, ME 04102

JOB NO: 0231158-00
DATE: JUNE 22, 2018
SCALE: 1"=20'
SHEET: 8 OF 17

C-104

LEVEL III SITE PLAN APPLICATION - NOT FOR CONSTRUCTION