


STRUCTURE TABLE

NAME	DIA.	RIM	SUMP DEPTH	INV IN/SIZE/FROM	INV OUT/SIZE/TO
OIL WATER SEP.	4'	25.99	0'	18.50/6"S/GAR.	18.40/6"S/PUMP ST.
PUMP ST.	4'	28.20	0'	17.99/6"S/OIL WATER SEP.	25.00/2"FM/VALVE BOX
SMH1	4'	38.99	0'	35.00/2"FM/VALVE BOX	34.90/6"S/MAIN
VALVE BOX	2'X2'	27.03	0'	25.00/2"FM/PUMP ST.	25.00/2"FM/SMH1

PIPE TABLE

PIPE NAME	SIZE	LENGTH	SLOPE
FM1	2" FM	2'	N/A*
FM2	2" FM	117'	N/A*
PIPE S1	6" S	42'	0.0050
PIPE S2	6" S	78'	0.0050
PIPE S4	6" S	32'	0.1157


*SLOPE BACK TO PUMP STATION

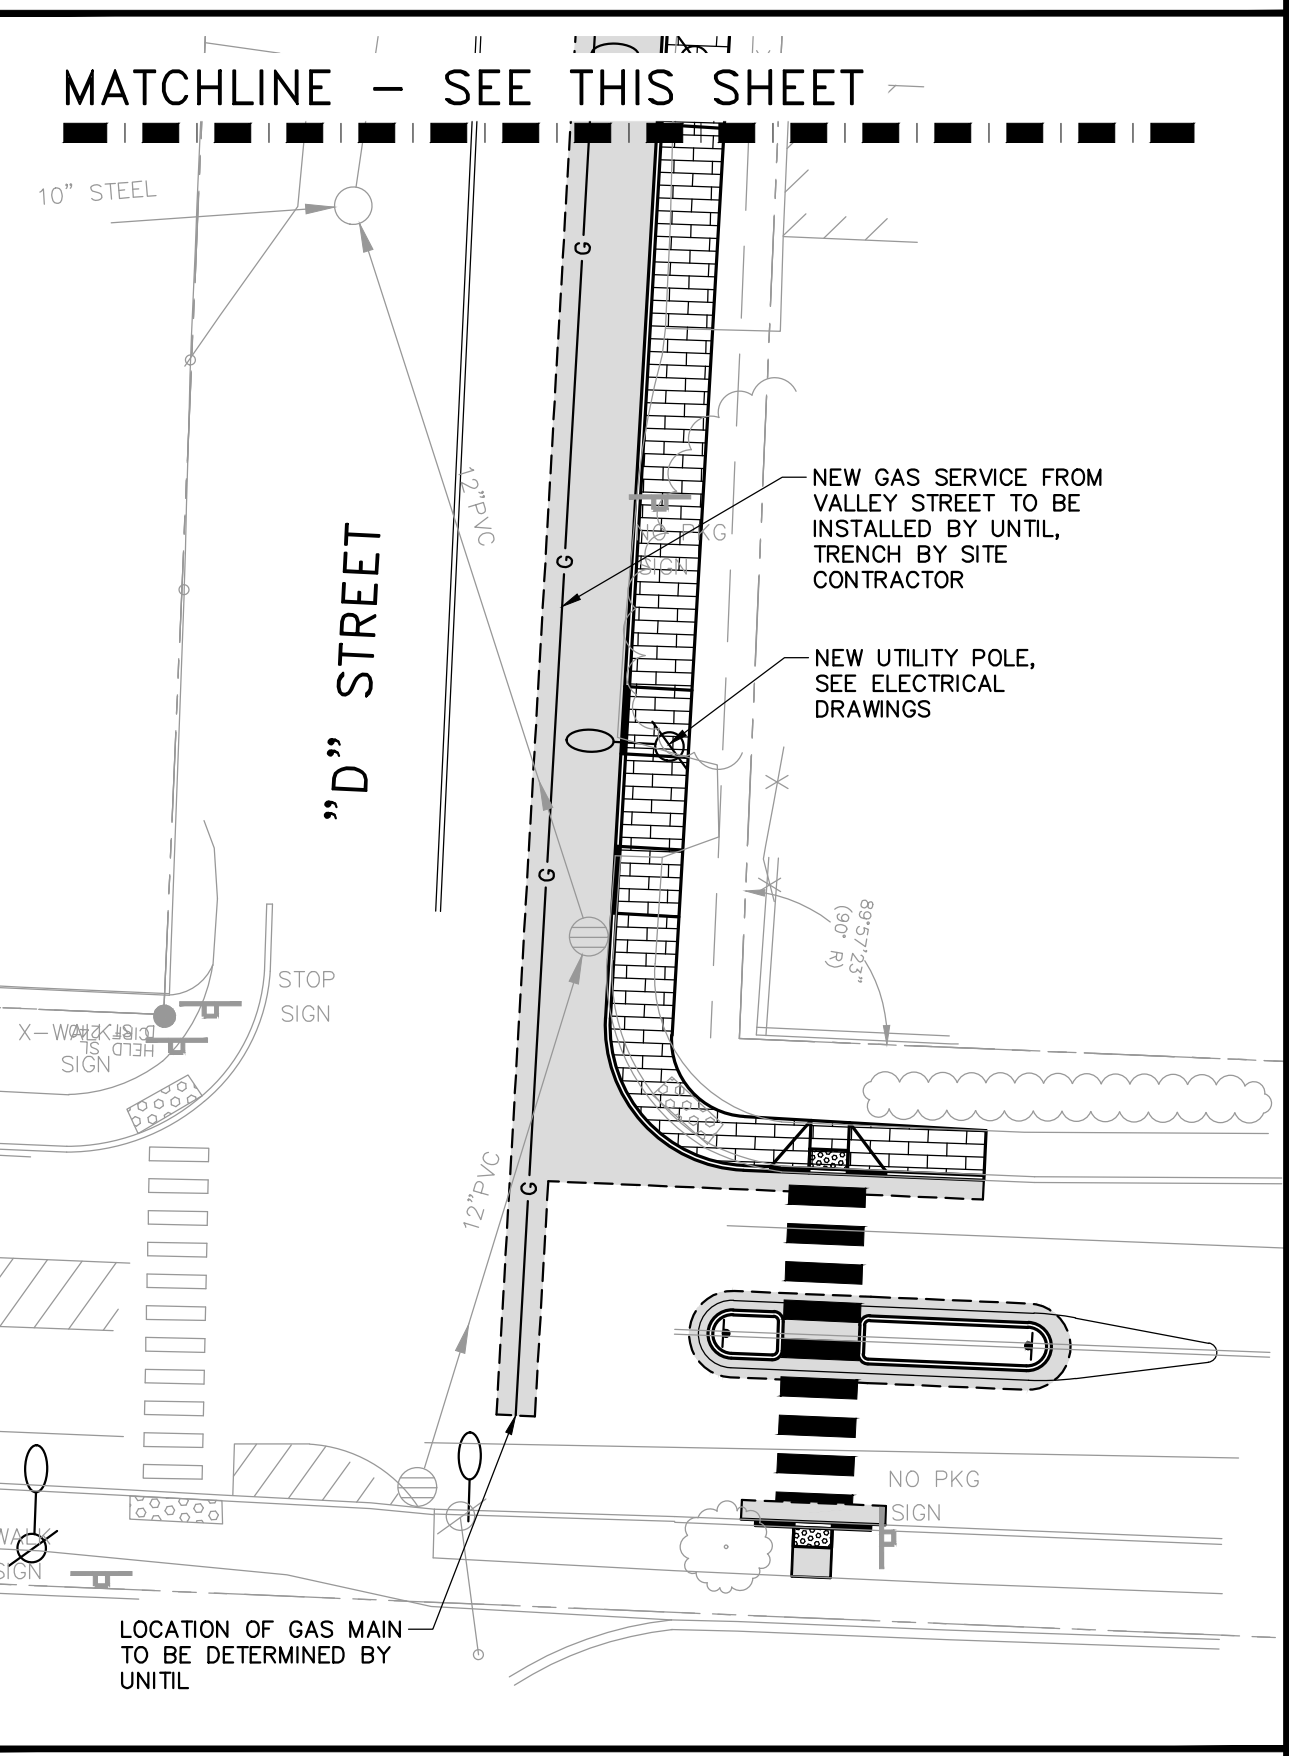

41 Hutchins Drive
Portland, Maine 04102
800.426.4262 | www.woodwardclay.com

WOODWARD & CLAY
CONSULTING ENGINEERS

COMMITMENT & INTEGRITY DRIVE RESULTS

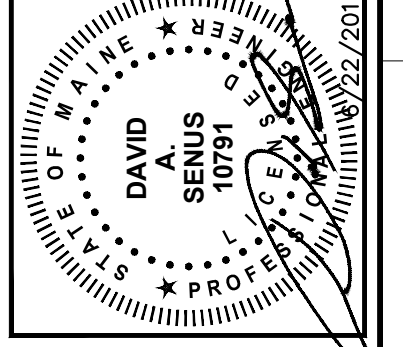

NO.	DATE	DESCRIPTION	BY	CHKD.
1	02/11/2016	ISSUED FOR PERMITS	DAVID S. SINUS	
2	02/11/2016	ISSUED FOR PERMITS	DAVID S. SINUS	
3	02/11/2016	ISSUED FOR PERMITS	DAVID S. SINUS	
4	02/11/2016	ISSUED FOR PERMITS	DAVID S. SINUS	
5	02/11/2016	ISSUED FOR PERMITS	DAVID S. SINUS	
6	02/11/2016	ISSUED FOR PERMITS	DAVID S. SINUS	
7	02/11/2016	ISSUED FOR PERMITS	DAVID S. SINUS	
8	02/11/2016	ISSUED FOR PERMITS	DAVID S. SINUS	
9	02/11/2016	ISSUED FOR PERMITS	DAVID S. SINUS	
10	02/11/2016	ISSUED FOR PERMITS	DAVID S. SINUS	

UTILITY PLAN - 1

MAINE MEDICAL CENTER
BRANFORD STREET
PORTLAND, ME 04102

**MHC ST. JOHN STREET
EMPLOYEE PARKING GARAGE**

JOB NO: 0231158.00
DATE: JUNE 22, 2016
SCALE: 1"=20'
SHEET: 8 OF 17

C-104

LEVEL III SITE PLAN APPLICATION-NOT FOR CONSTRUCTION