


STRUCTURE TABLE

NAME	DIA.	RIM	SUMP DEPTH	INV IN/SIZE/FROM	INV OUT/SIZE/TO
OIL WATER SEP.	4'	26.70	0'	13.44/6"S/GAR.	13.10/6"S/PUMP ST.
PUMP ST.	4'	27.20	5'	13.05/6"S/OIL WATER SEP.	23.00/2"FM/VALVE BOX
SMH1	4'	38.99	0'	35.00/2"FM/VALVE BOX	34.90/8"S/MAIN
VALVE BOX	2'X2'	27.50	0'	23.00/2"FM/PUMP ST.	23.00/2"FM/SMH1

PIPE TABLE

PIPE NAME	SIZE	LENGTH	SLOPE
FM1	2" FM	2'	N/A*
FM2	2" FM	133'	N/A*
PIPE S1	6" S	42'	0.0050
PIPE S2	6" S	5'	0.0050
PIPE S3	6" S	190'	0.0059
PIPE S4	8" S	32'	0.1157


*SLOPE BACK TO PUMP STATION

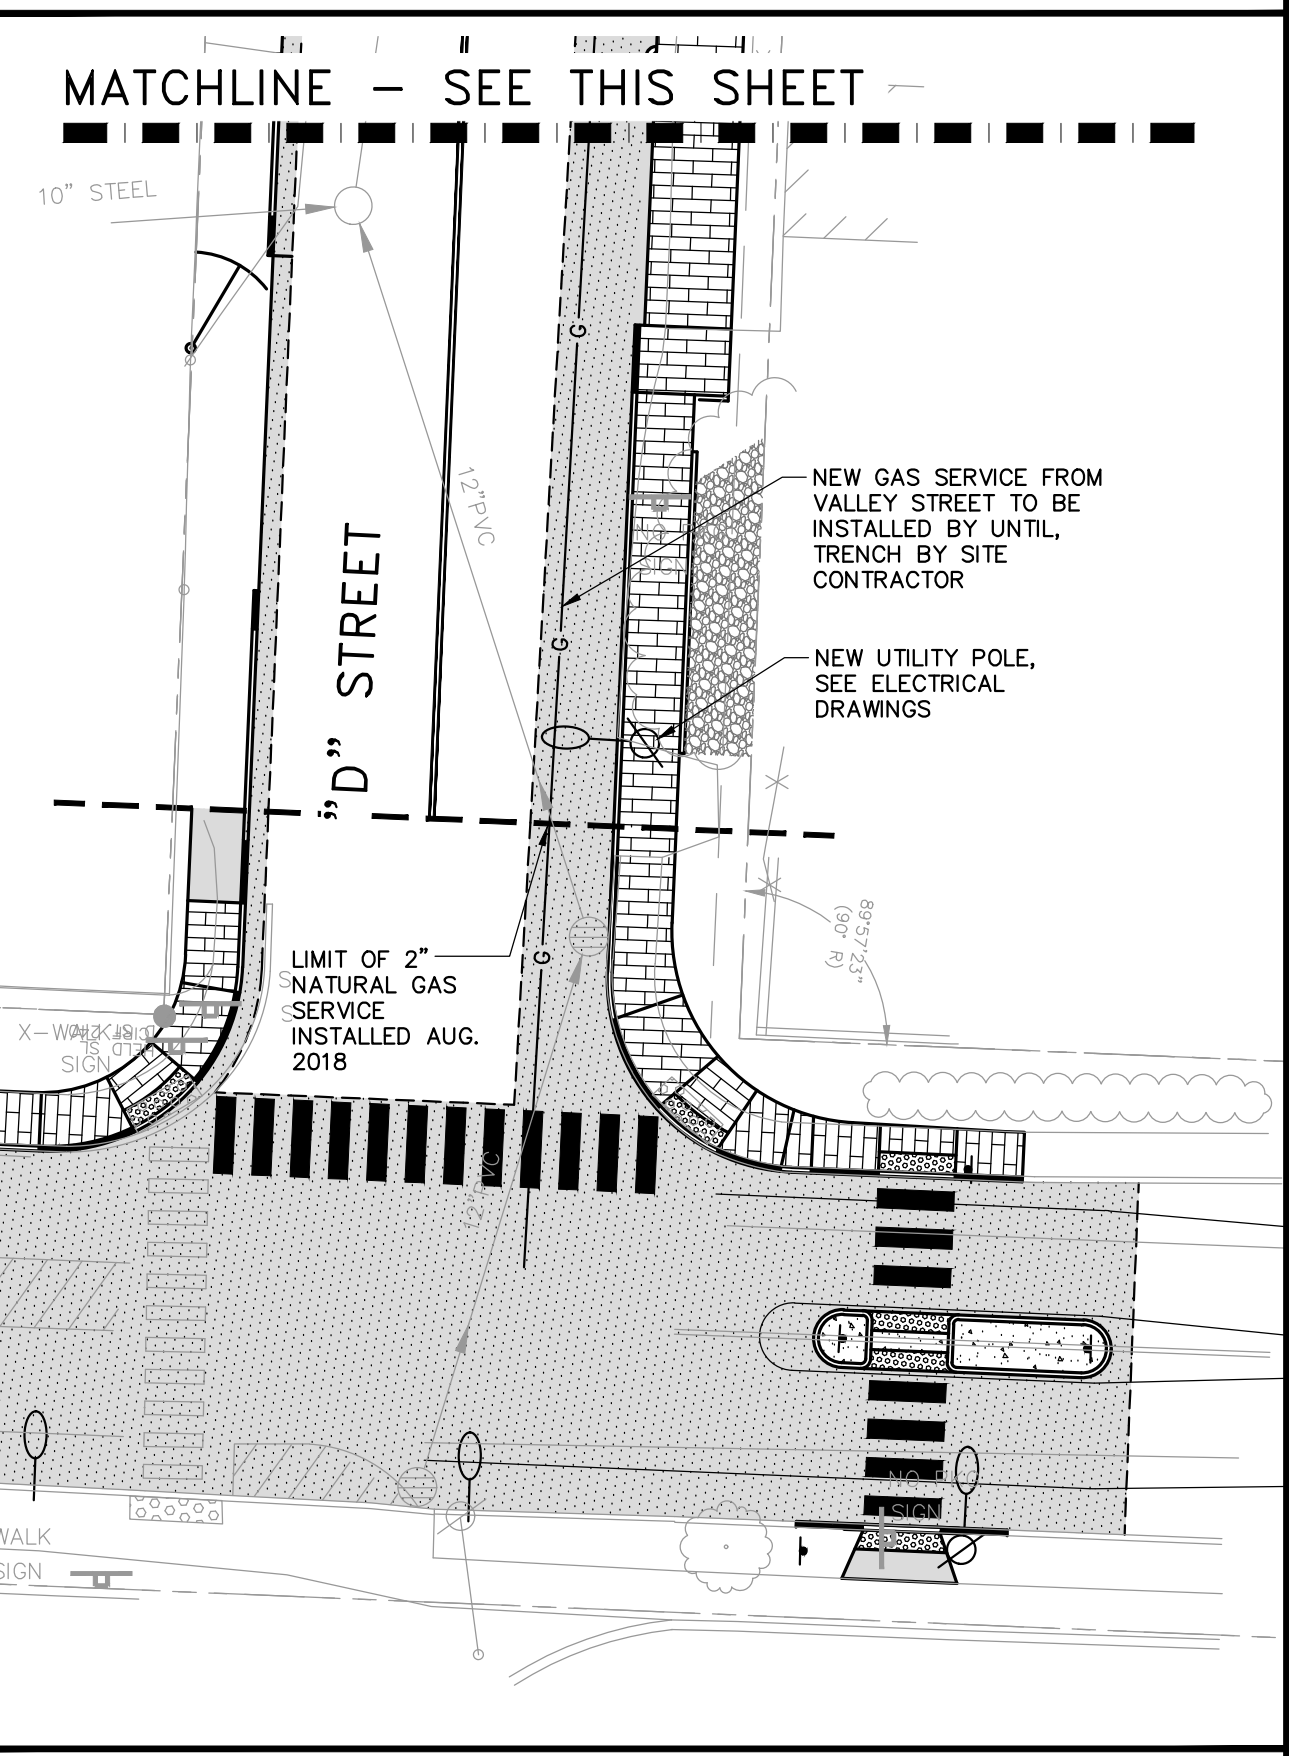

41 Hutchins Drive
Portland, Maine 04102
800.426.4362 | www.woodwardclay.com

WOODWARD & CLAY

COMMITMENT & INTEGRITY DRIVE RESULTS

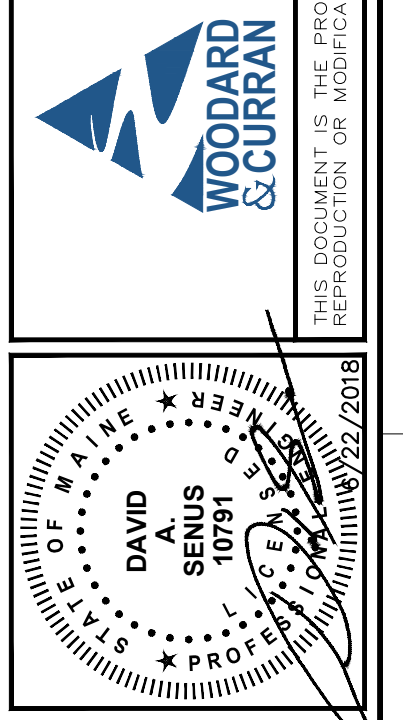

NO.	DATE	DESCRIPTION	BY	CHKD.
1	12/24/2018	RESPONSE TO COMMENTS	DA	DA
2	1/23/2019	RESPONSE TO COMMENTS	DA	DA
3	6/23/2018	RESPONSE TO COMMENTS	DA	DA

DESIGNED BY: DAS
CHECKED BY: DAS
DATE: 08/18/2018

UTILITY PLAN - 1

MAINE MEDICAL CENTER
BRANFILL STREET
PORTLAND, ME 04102

MMC ST. JOHN STREET
EMPLOYEE PARKING GARAGE

JOB NO: 0231158-00
DATE: JUNE 22, 2018
SCALE: 1"=20'
SHEET: 8 OF 17

LEVEL III SITE PLAN APPLICATION - NOT FOR CONSTRUCTION