

CONSULTANTS

CIVIL/LANDSCAPE ARCHITECT
Seglio Technics
75 John Roberts Road, Suite 1A, South
Portland, ME 04106

STRUCTURAL ENGINEER/BUILDING ENVELOPE
Simpson Gumpertz & Heger Inc.
41 Seyon Street, Building 1, Suite 500, Waltham,
Massachusetts 02453

MEPP ENGINEER/COOR
AKF Group LLC
99 Bedford Street, 2nd Floor, Boston, MA 02111

LIGHTING CONSULTANT
Lightcraft
99 Bedford Street, 2nd Floor, Boston, MA 02111


PROJECT

Congress St.
22 Bramhall St.
Portland, ME 04102



Maine Medical Center
22 Bramhall St.
Portland, ME 04102

KEYPLAN

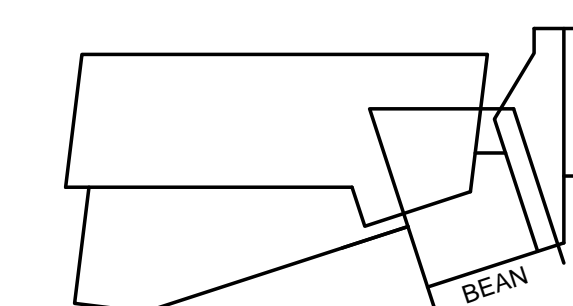

ISSUE CHART

**Exterior Photometric
Submission to the City
of Portland Maine**
10.30.2018

DATE	ISSUE
Job Number	8162234-00
Drawn	
Checked	
Approved	

TITLE


PHOTOMETRIC

SHEET NUMBER

L-100

A1	STREET PEDESTRIAN LIGHTING POLE - CITY OF PORTLAND, MAINE	HALOPHANE PEDESTRIAN ESPLANADE SERIES
A2	RECESSED LINEAR WALL MOUNTED FIXTURE	BEGA 33054
A3	LINEAR COVE MOUNTED FIXTURE IN PERFORATED CEILING	LUMENPULSE LUMENFACADE
A4	LINEAR LED TAPE LIGHT IN CHANNEL BELOW BENCH SEATING	LED LINEAR, ADONIS HYDRA WHITE

illuminance (Fc)
Average = 1.34
Maximum = 5.4
Minimum = 0.1

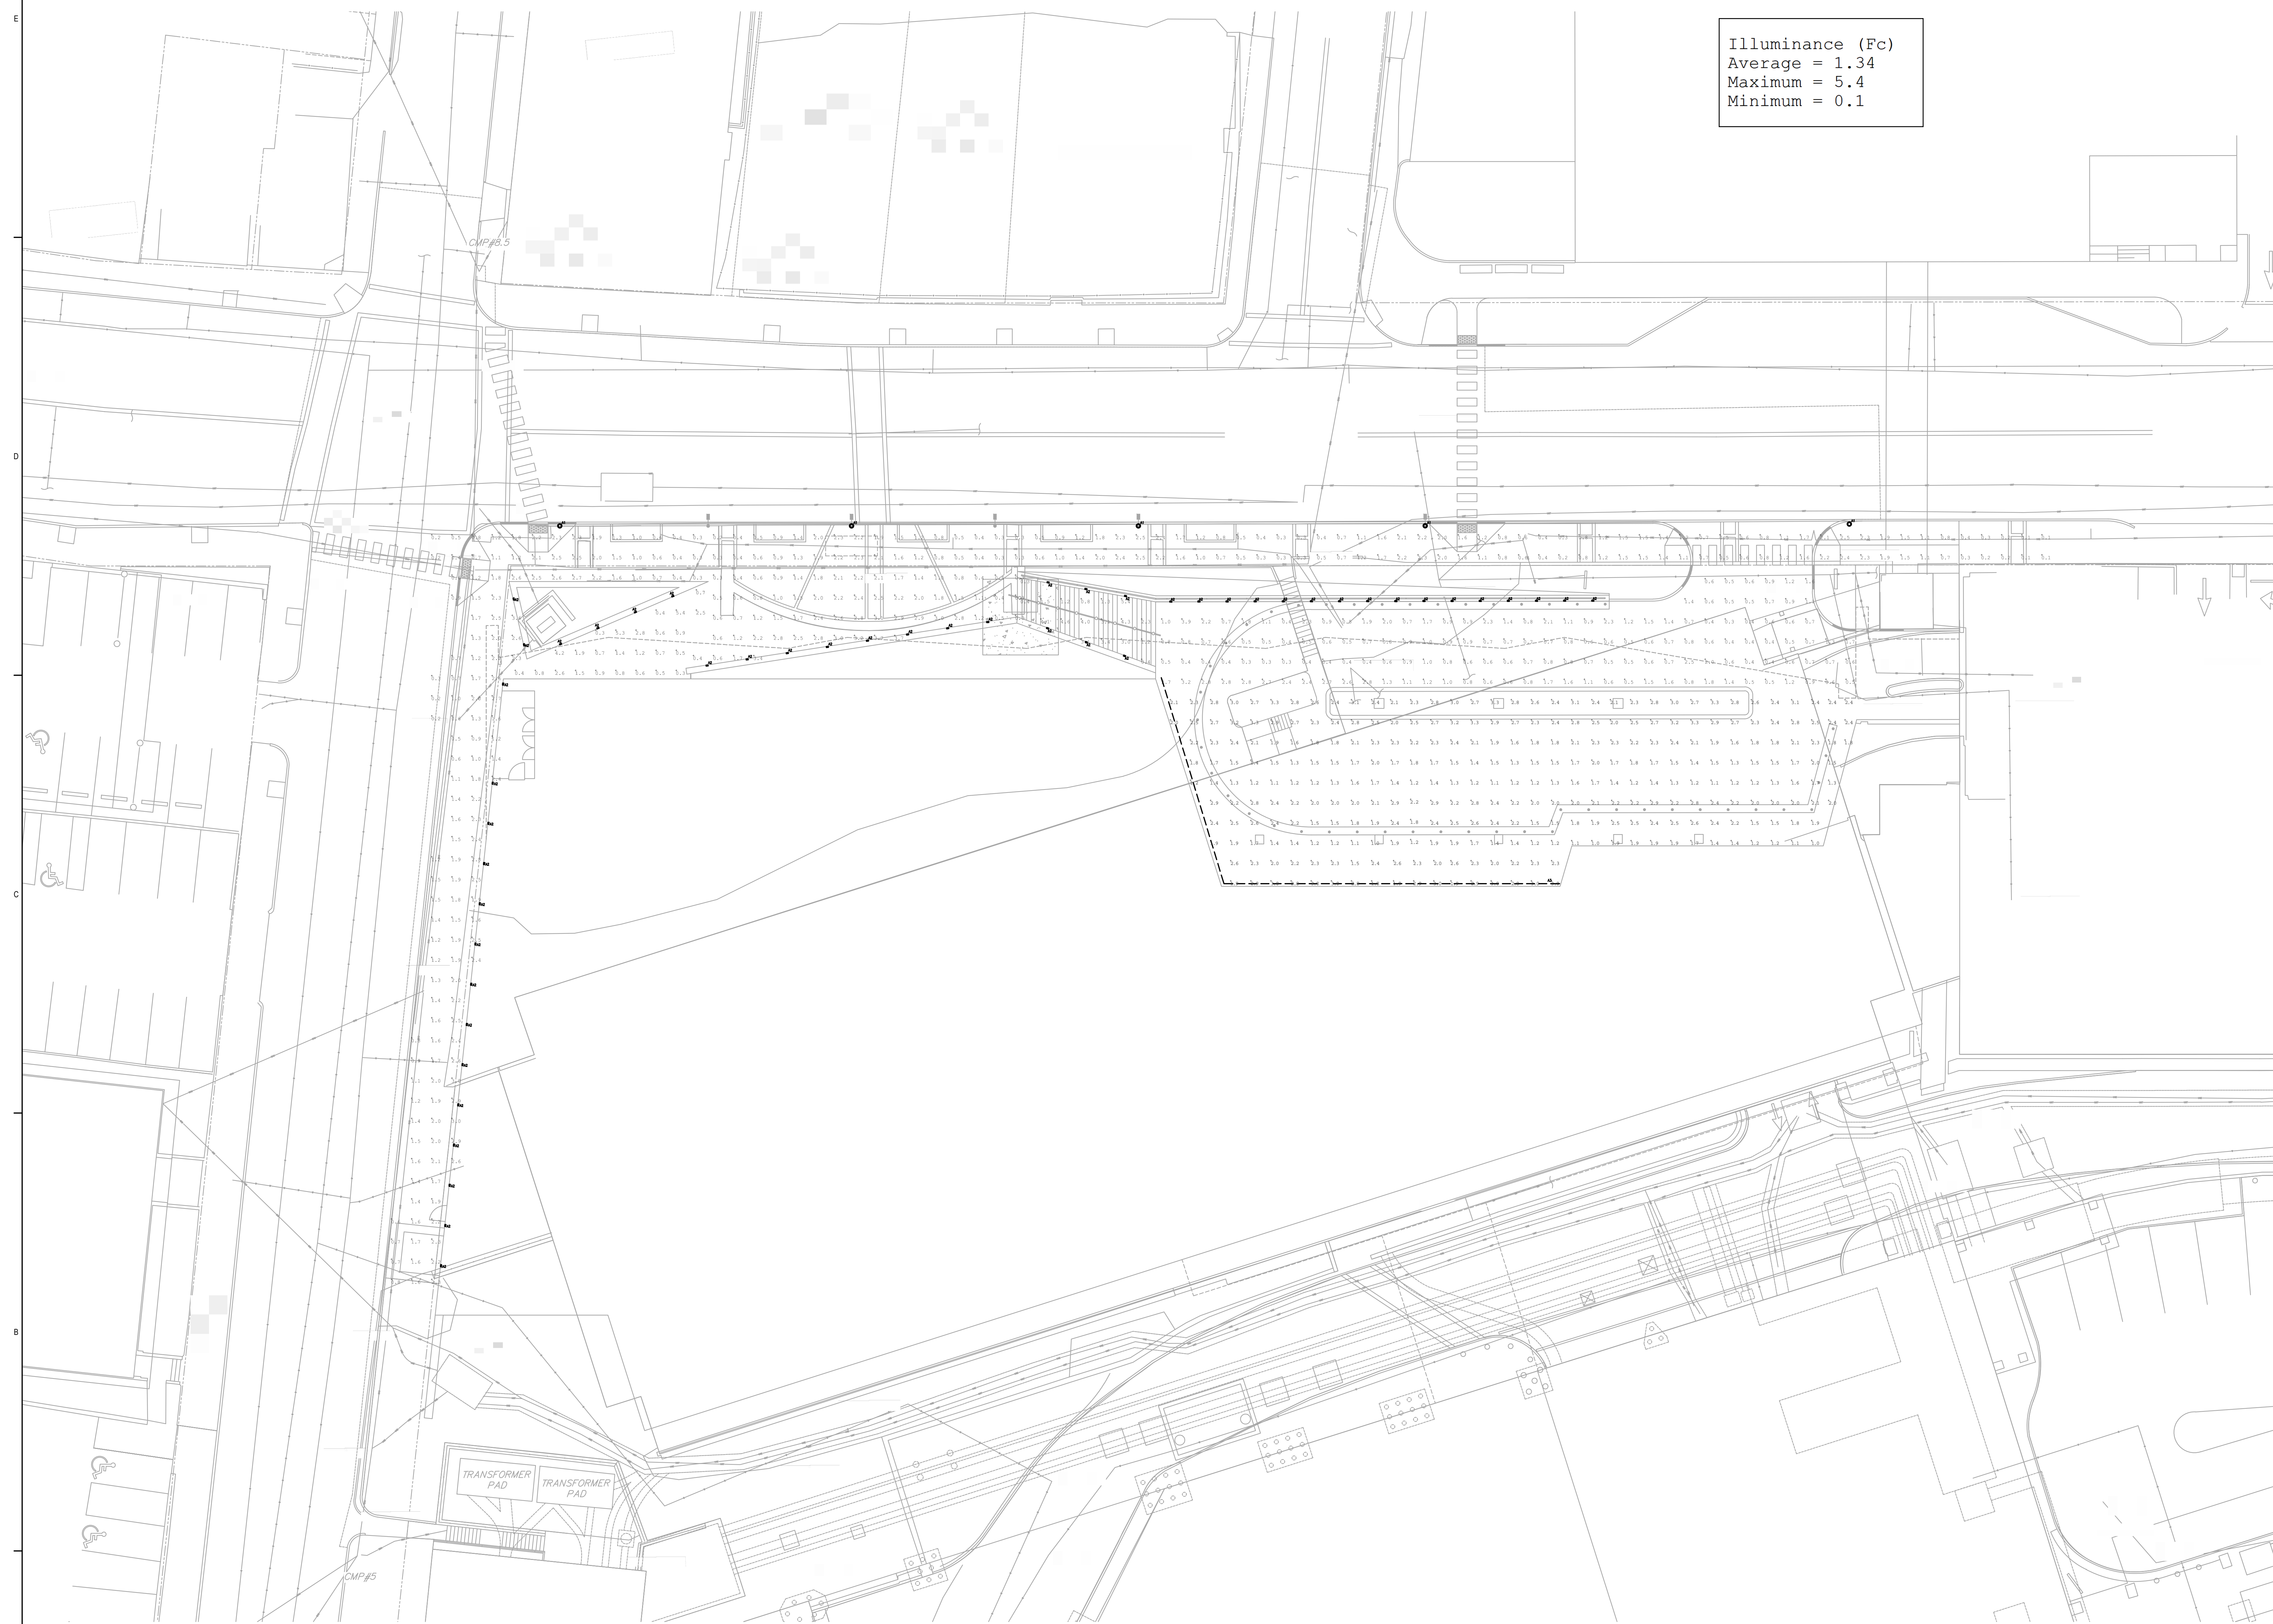

1 EXTERIOR SITE PLAN
SCALE: 1/16"=1'-0"