



- 1 - NOT USED
- 2 - CONGRESS STREET
- 3 - VISITOR GARAGE
- 4 - EAST TOWER
- 5 - CENTRAL UTILITY PLANT
- 6 - BEAN BUILDING
- 7 - RICHARDS BUILDING
- 8 - MAINE GENERAL BUILDING

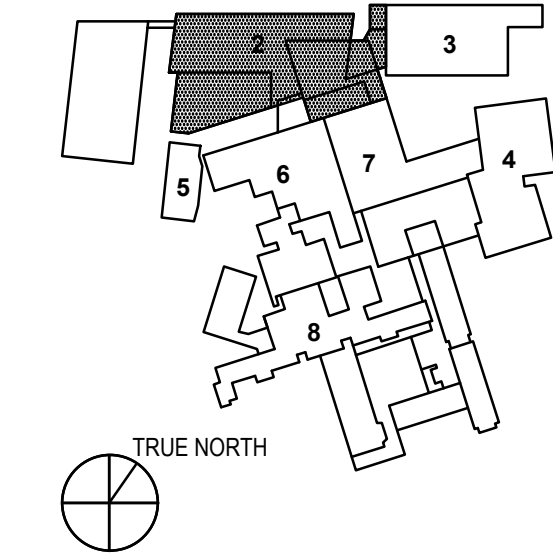

| NO. | ISSUE | DATE |
|------------|------------|------|
| Job Number | 152189.000 | |
| Drawn | MAL | |
| Checked | WTC | |
| Approved | DLR | |

TITLE
**SITE PLAN,
UPPER CONGRESS,
CONGRESS STREET
EXPANSION**

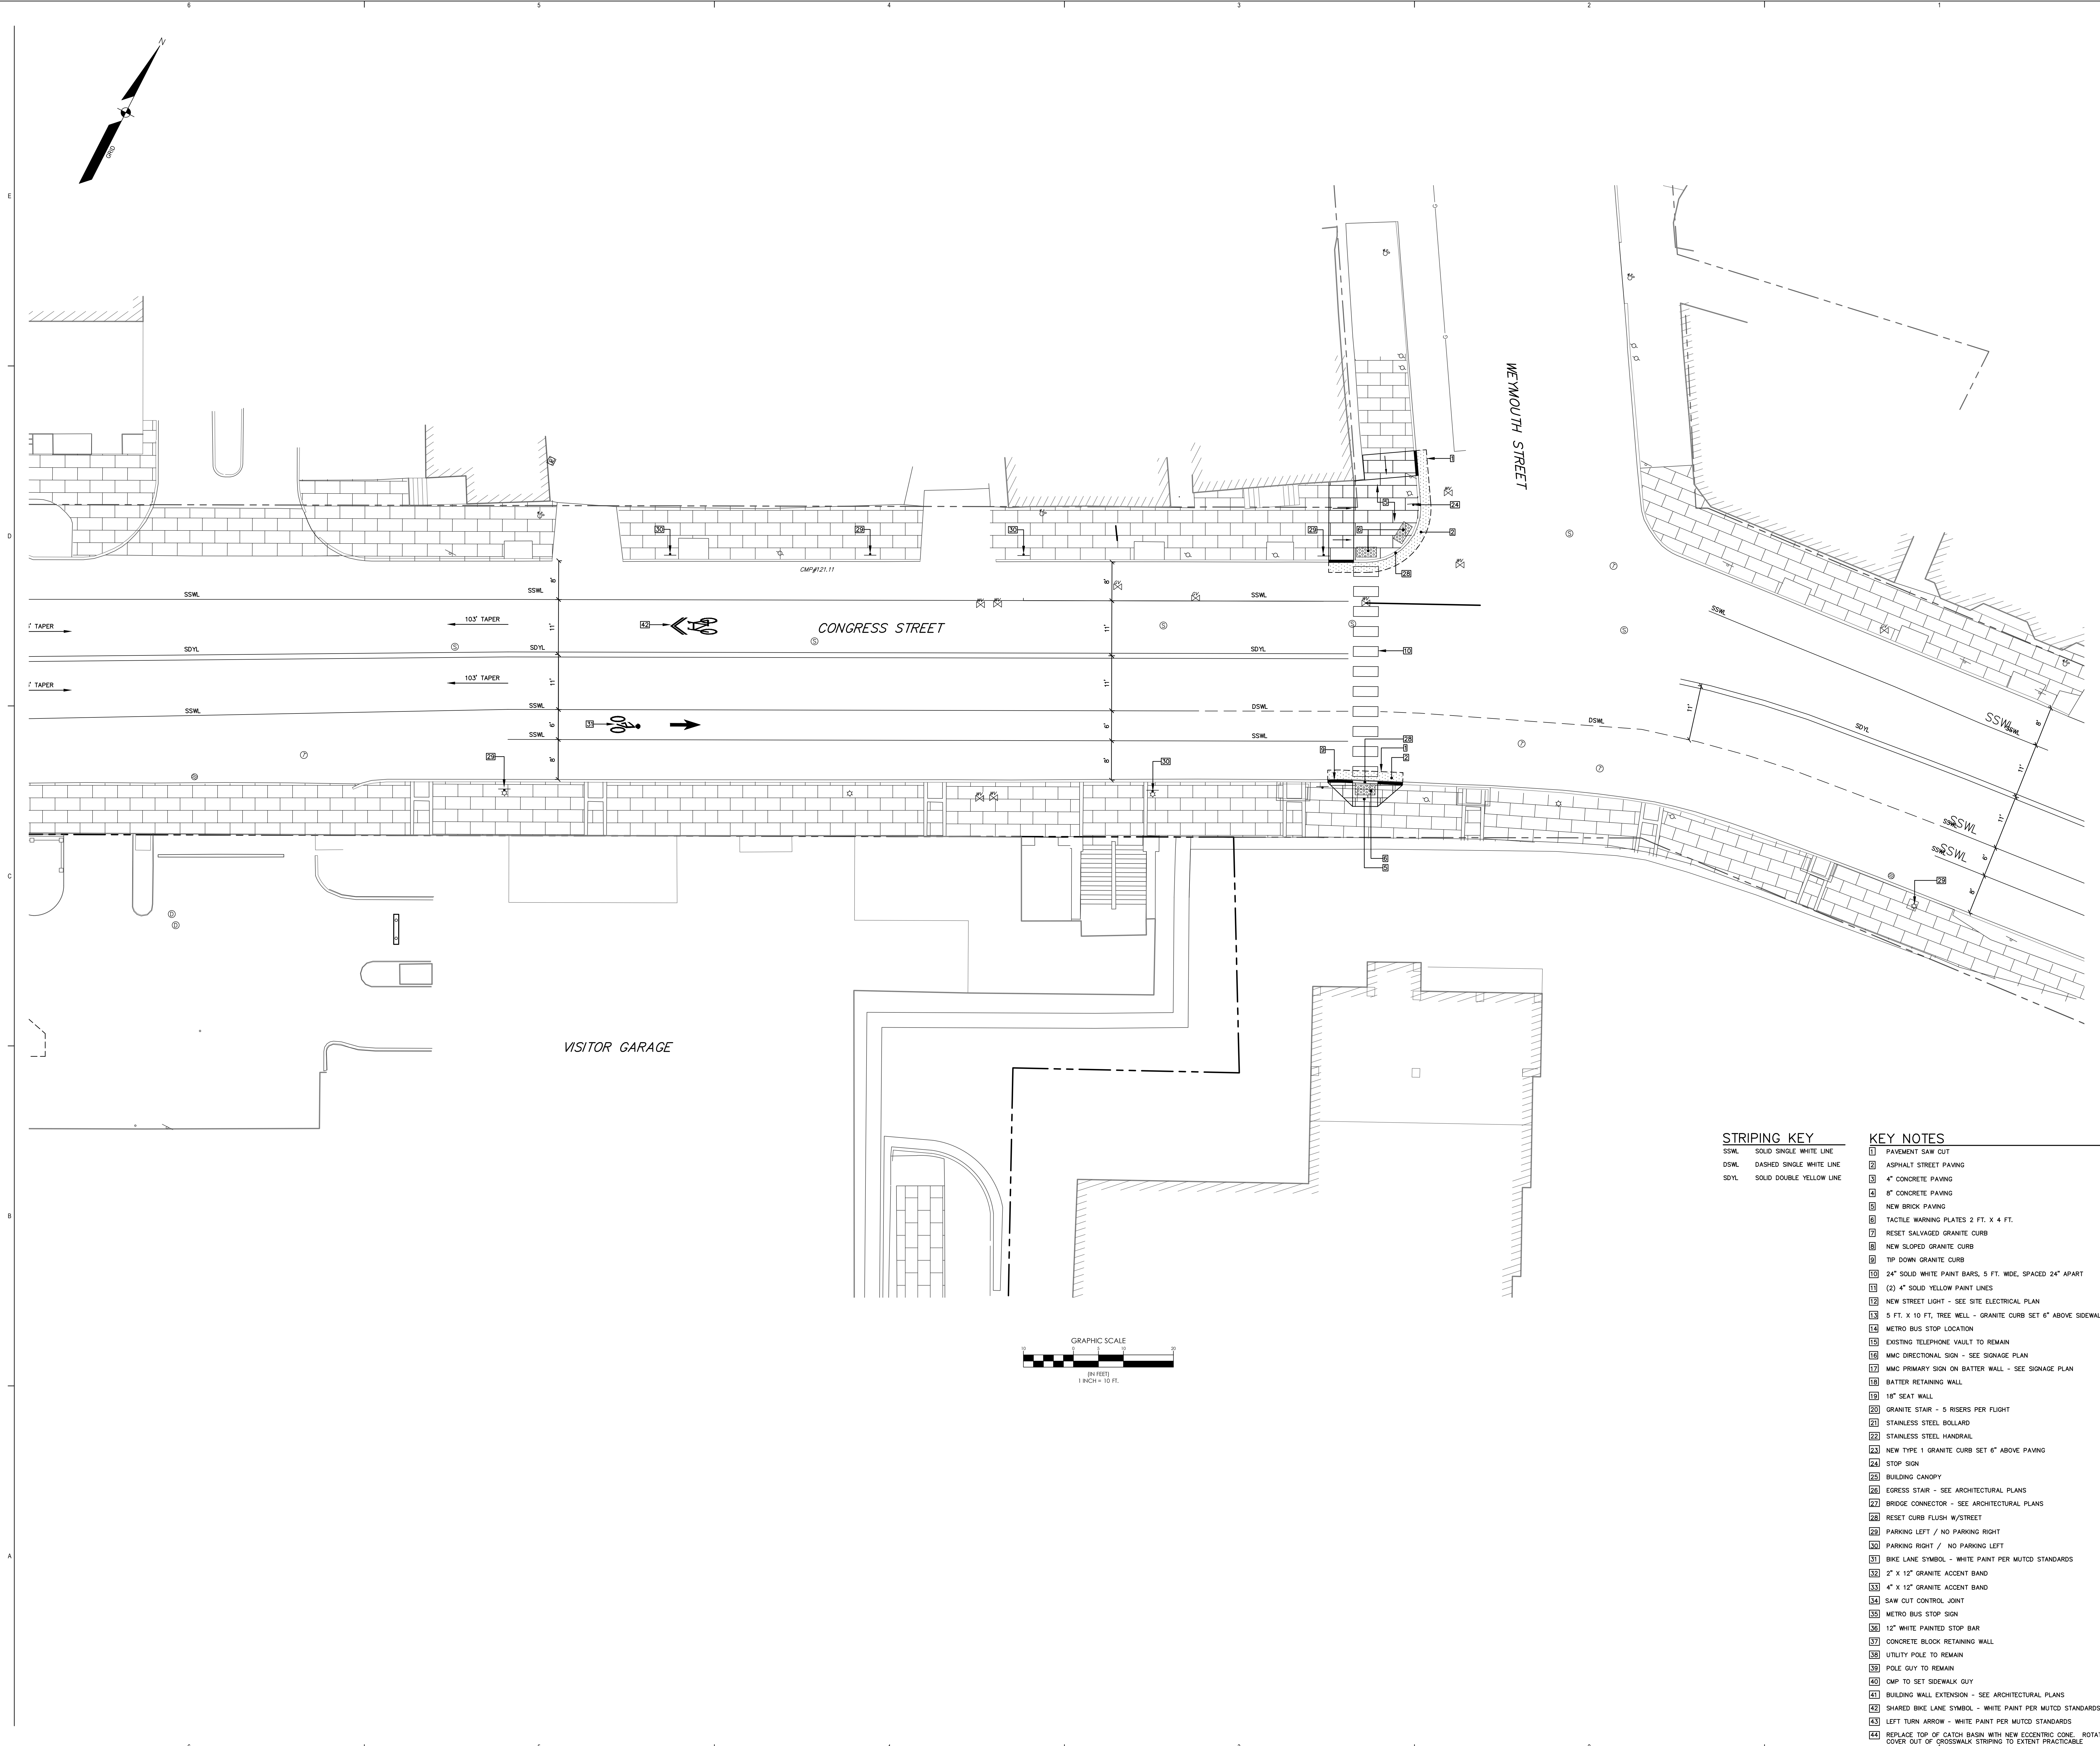

STRIPING KEY

- SSWL SOLID SINGLE WHITE LINE
- DSWL DASHED SINGLE WHITE LINE
- SDYL SOLID DOUBLE YELLOW LINE

- KEY NOTES**
- 01 PAVEMENT SAW CUT
 - 02 ASPHALT STREET PAVING
 - 03 4" CONCRETE PAVING
 - 04 8" CONCRETE PAVING
 - 05 NEW BRICK PAVING
 - 06 TACTILE WARNING PLATES 2 FT. X 4 FT.
 - 07 RESET SALVAGED GRANITE CURB
 - 08 NEW SLOPED GRANITE CURB
 - 09 TIP DOWN GRANITE CURB
 - 10 24" SOLID WHITE PAINT BARS, 5 FT. WIDE, SPACED 24" APART
 - 11 (2) 4" SOLID YELLOW PAINT LINES
 - 12 NEW STREET LIGHT - SEE SITE ELECTRICAL PLAN
 - 13 5 FT. X 10 FT. TREE WELL - GRANITE CURB SET 6" ABOVE SIDEWALK
 - 14 METRO BUS STOP LOCATION
 - 15 EXISTING TELEPHONE VAULT TO REMAIN
 - 16 MMC DIRECTIONAL SIGN - SEE SIGNAGE PLAN
 - 17 MMC PRIMARY SIGN ON BATTER WALL - SEE SIGNAGE PLAN
 - 18 BATTER RETAINING WALL
 - 19 18" SEAT WALL
 - 20 GRANITE STAIR - 5 RISERS PER FLIGHT
 - 21 STAINLESS STEEL BOLLARD
 - 22 STAINLESS STEEL HANDRAIL
 - 23 NEW TYPE 1 GRANITE CURB SET 6" ABOVE PAVING
 - 24 STOP SIGN
 - 25 BUILDING CANOPY
 - 26 EPRESS STAR - SEE ARCHITECTURAL PLANS
 - 27 BRIDGE CONNECTOR - SEE ARCHITECTURAL PLANS
 - 28 RESET CURB FLUSH W/STREET
 - 29 PARKING LEFT / NO PARKING RIGHT
 - 30 PARKING RIGHT / NO PARKING LEFT
 - 31 BIKE LANE SYMBOL - WHITE PAINT PER MUTCD STANDARDS
 - 32 2" X 12" GRANITE ACCENT BAND
 - 33 4" X 12" GRANITE ACCENT BAND
 - 34 SAW CUT CONTROL JOINT
 - 35 METRO BUS STOP SIGN
 - 36 12" WHITE PAINTED STOP BAR
 - 37 CONCRETE BLOCK RETAINING WALL
 - 38 UTILITY POLE TO REMAIN
 - 39 POLE GUY TO REMAIN
 - 40 CMP TO SET SIDEWALK GUY
 - 41 BUILDING WALL EXTENSION - SEE ARCHITECTURAL PLANS
 - 42 SHARED BIKE LANE SYMBOL - WHITE PAINT PER MUTCD STANDARDS
 - 43 LEFT TURN ARROW - WHITE PAINT PER MUTCD STANDARDS
 - 44 REPLACE TOP OF CATCH BASIN WITH NEW ECCENTRIC CONE. ROTATE COVER OUT OF CROSSWALK STRIPING TO EXTENT PRACTICABLE.

