
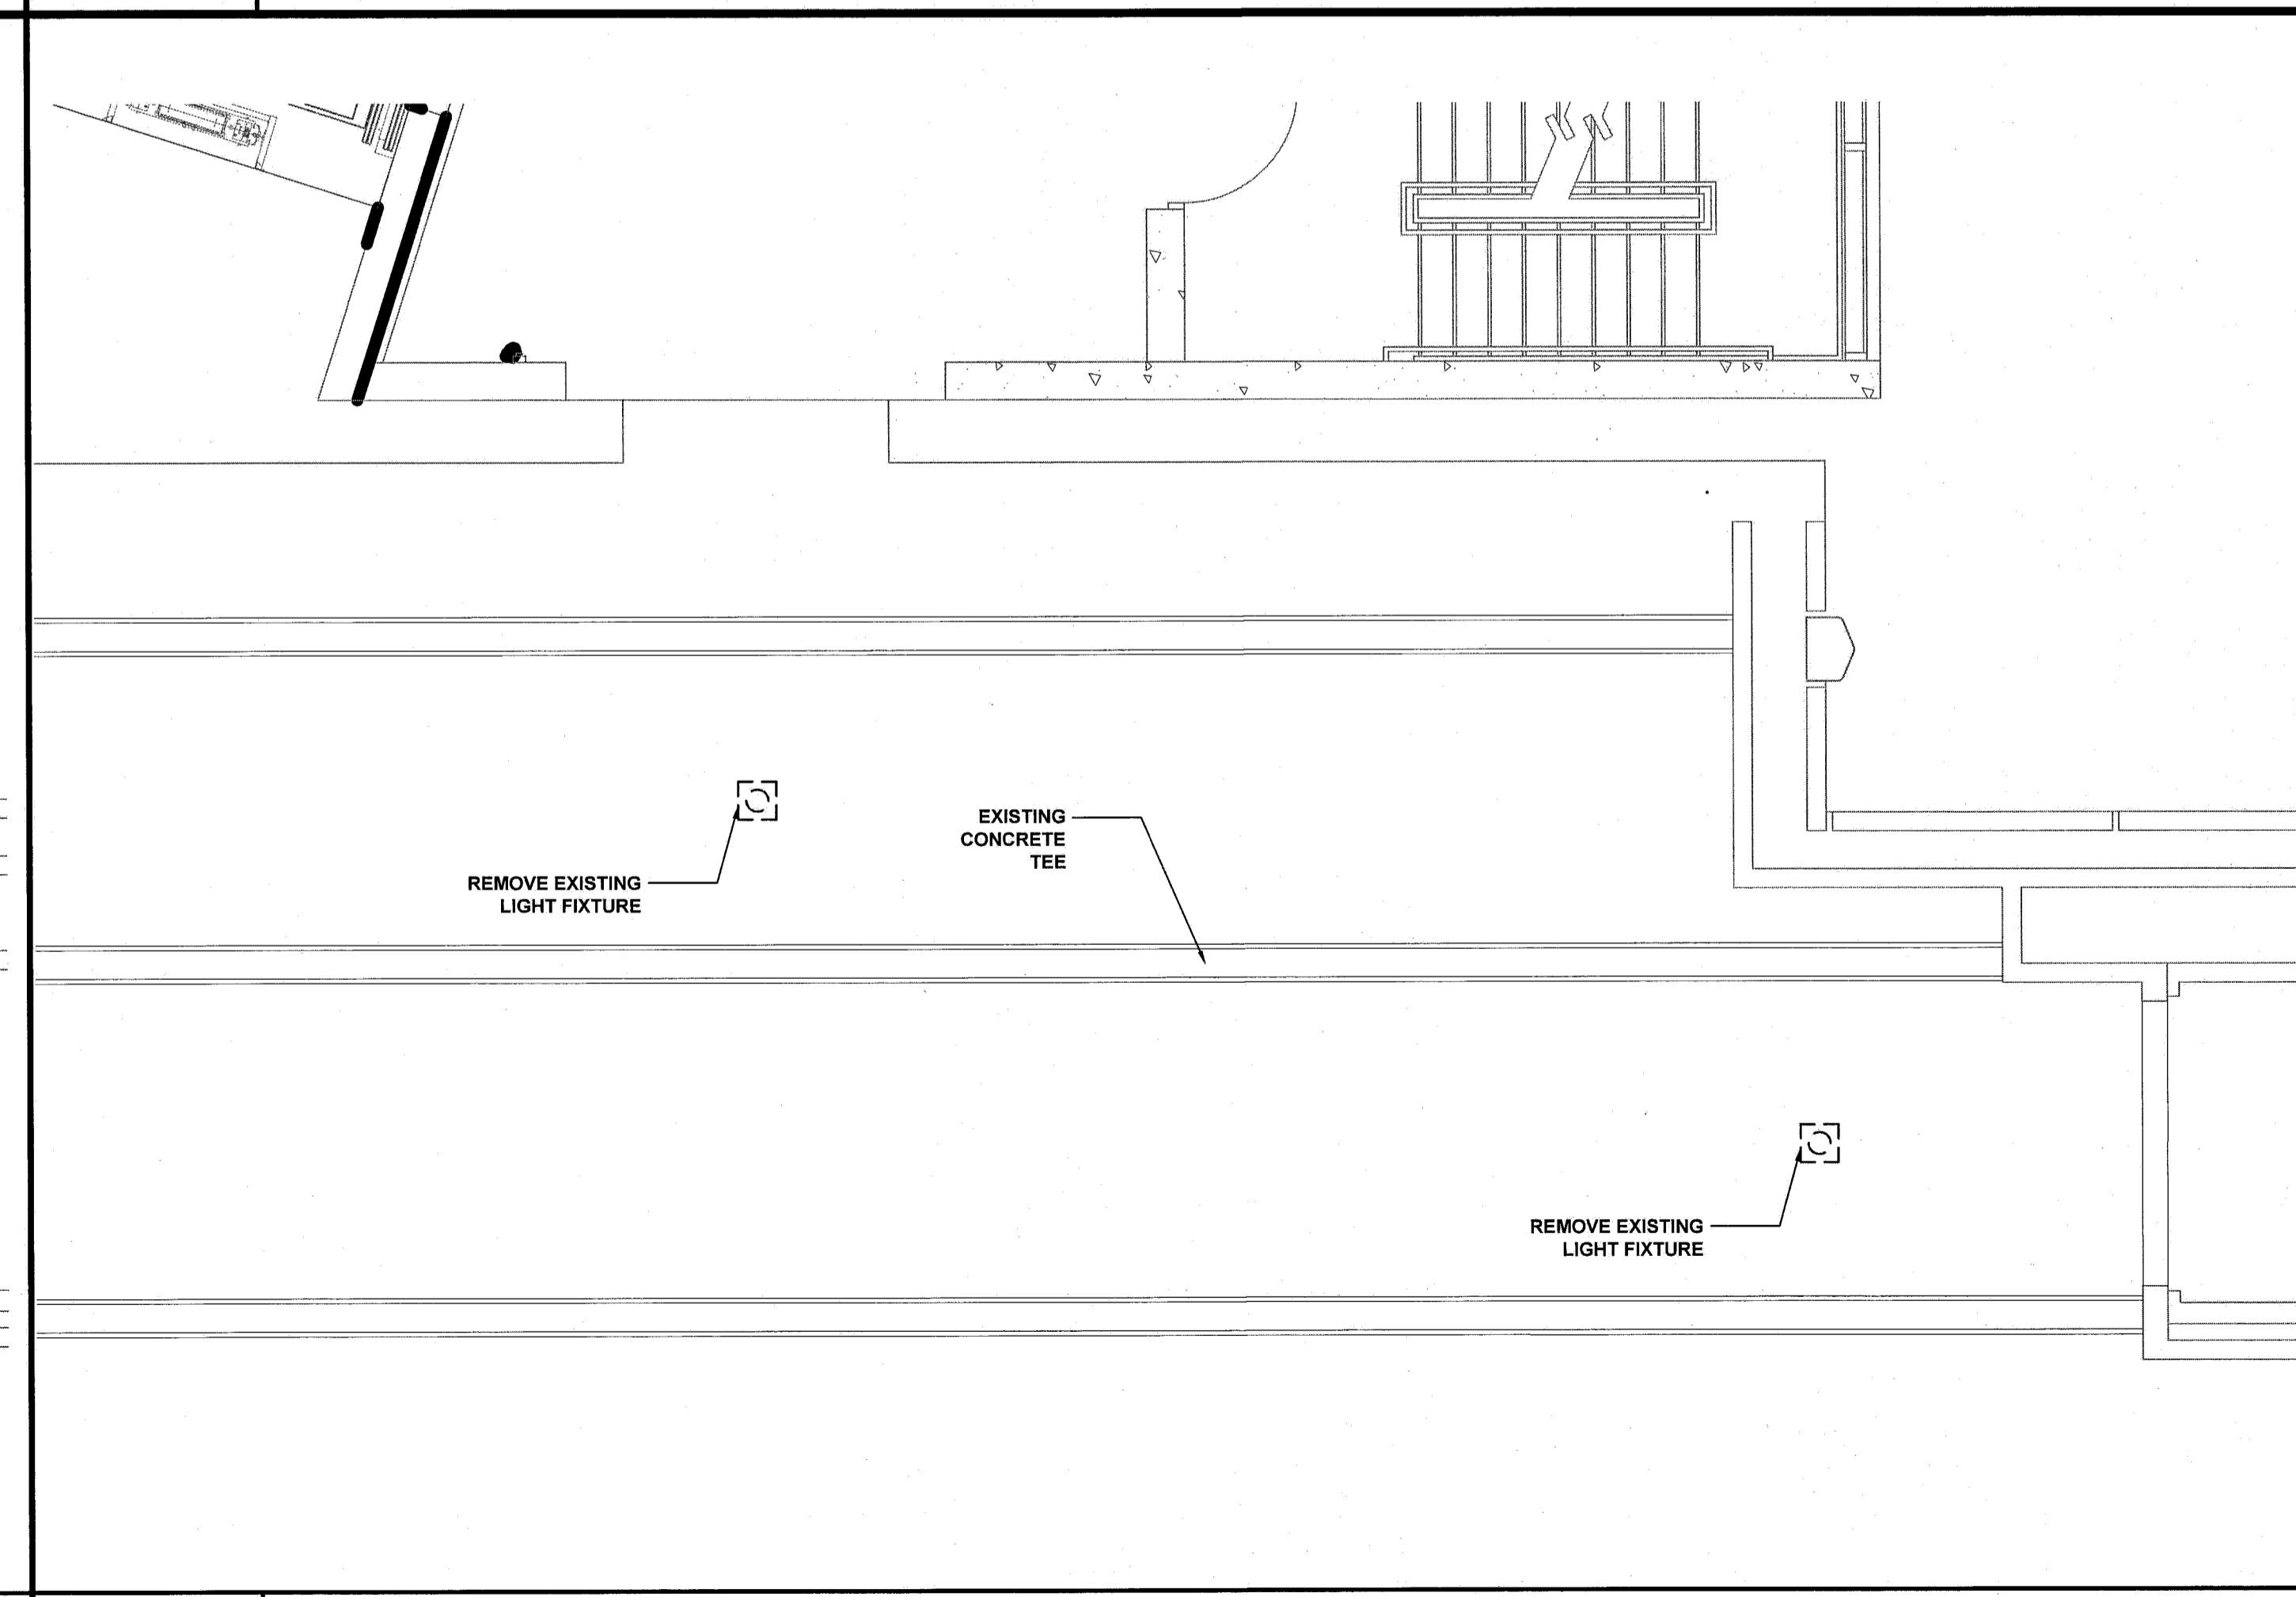


E1 REFLECTED CEILING PLAN LEVEL 8

E7 REFLECTED CEILING PLAN LEVEL 7

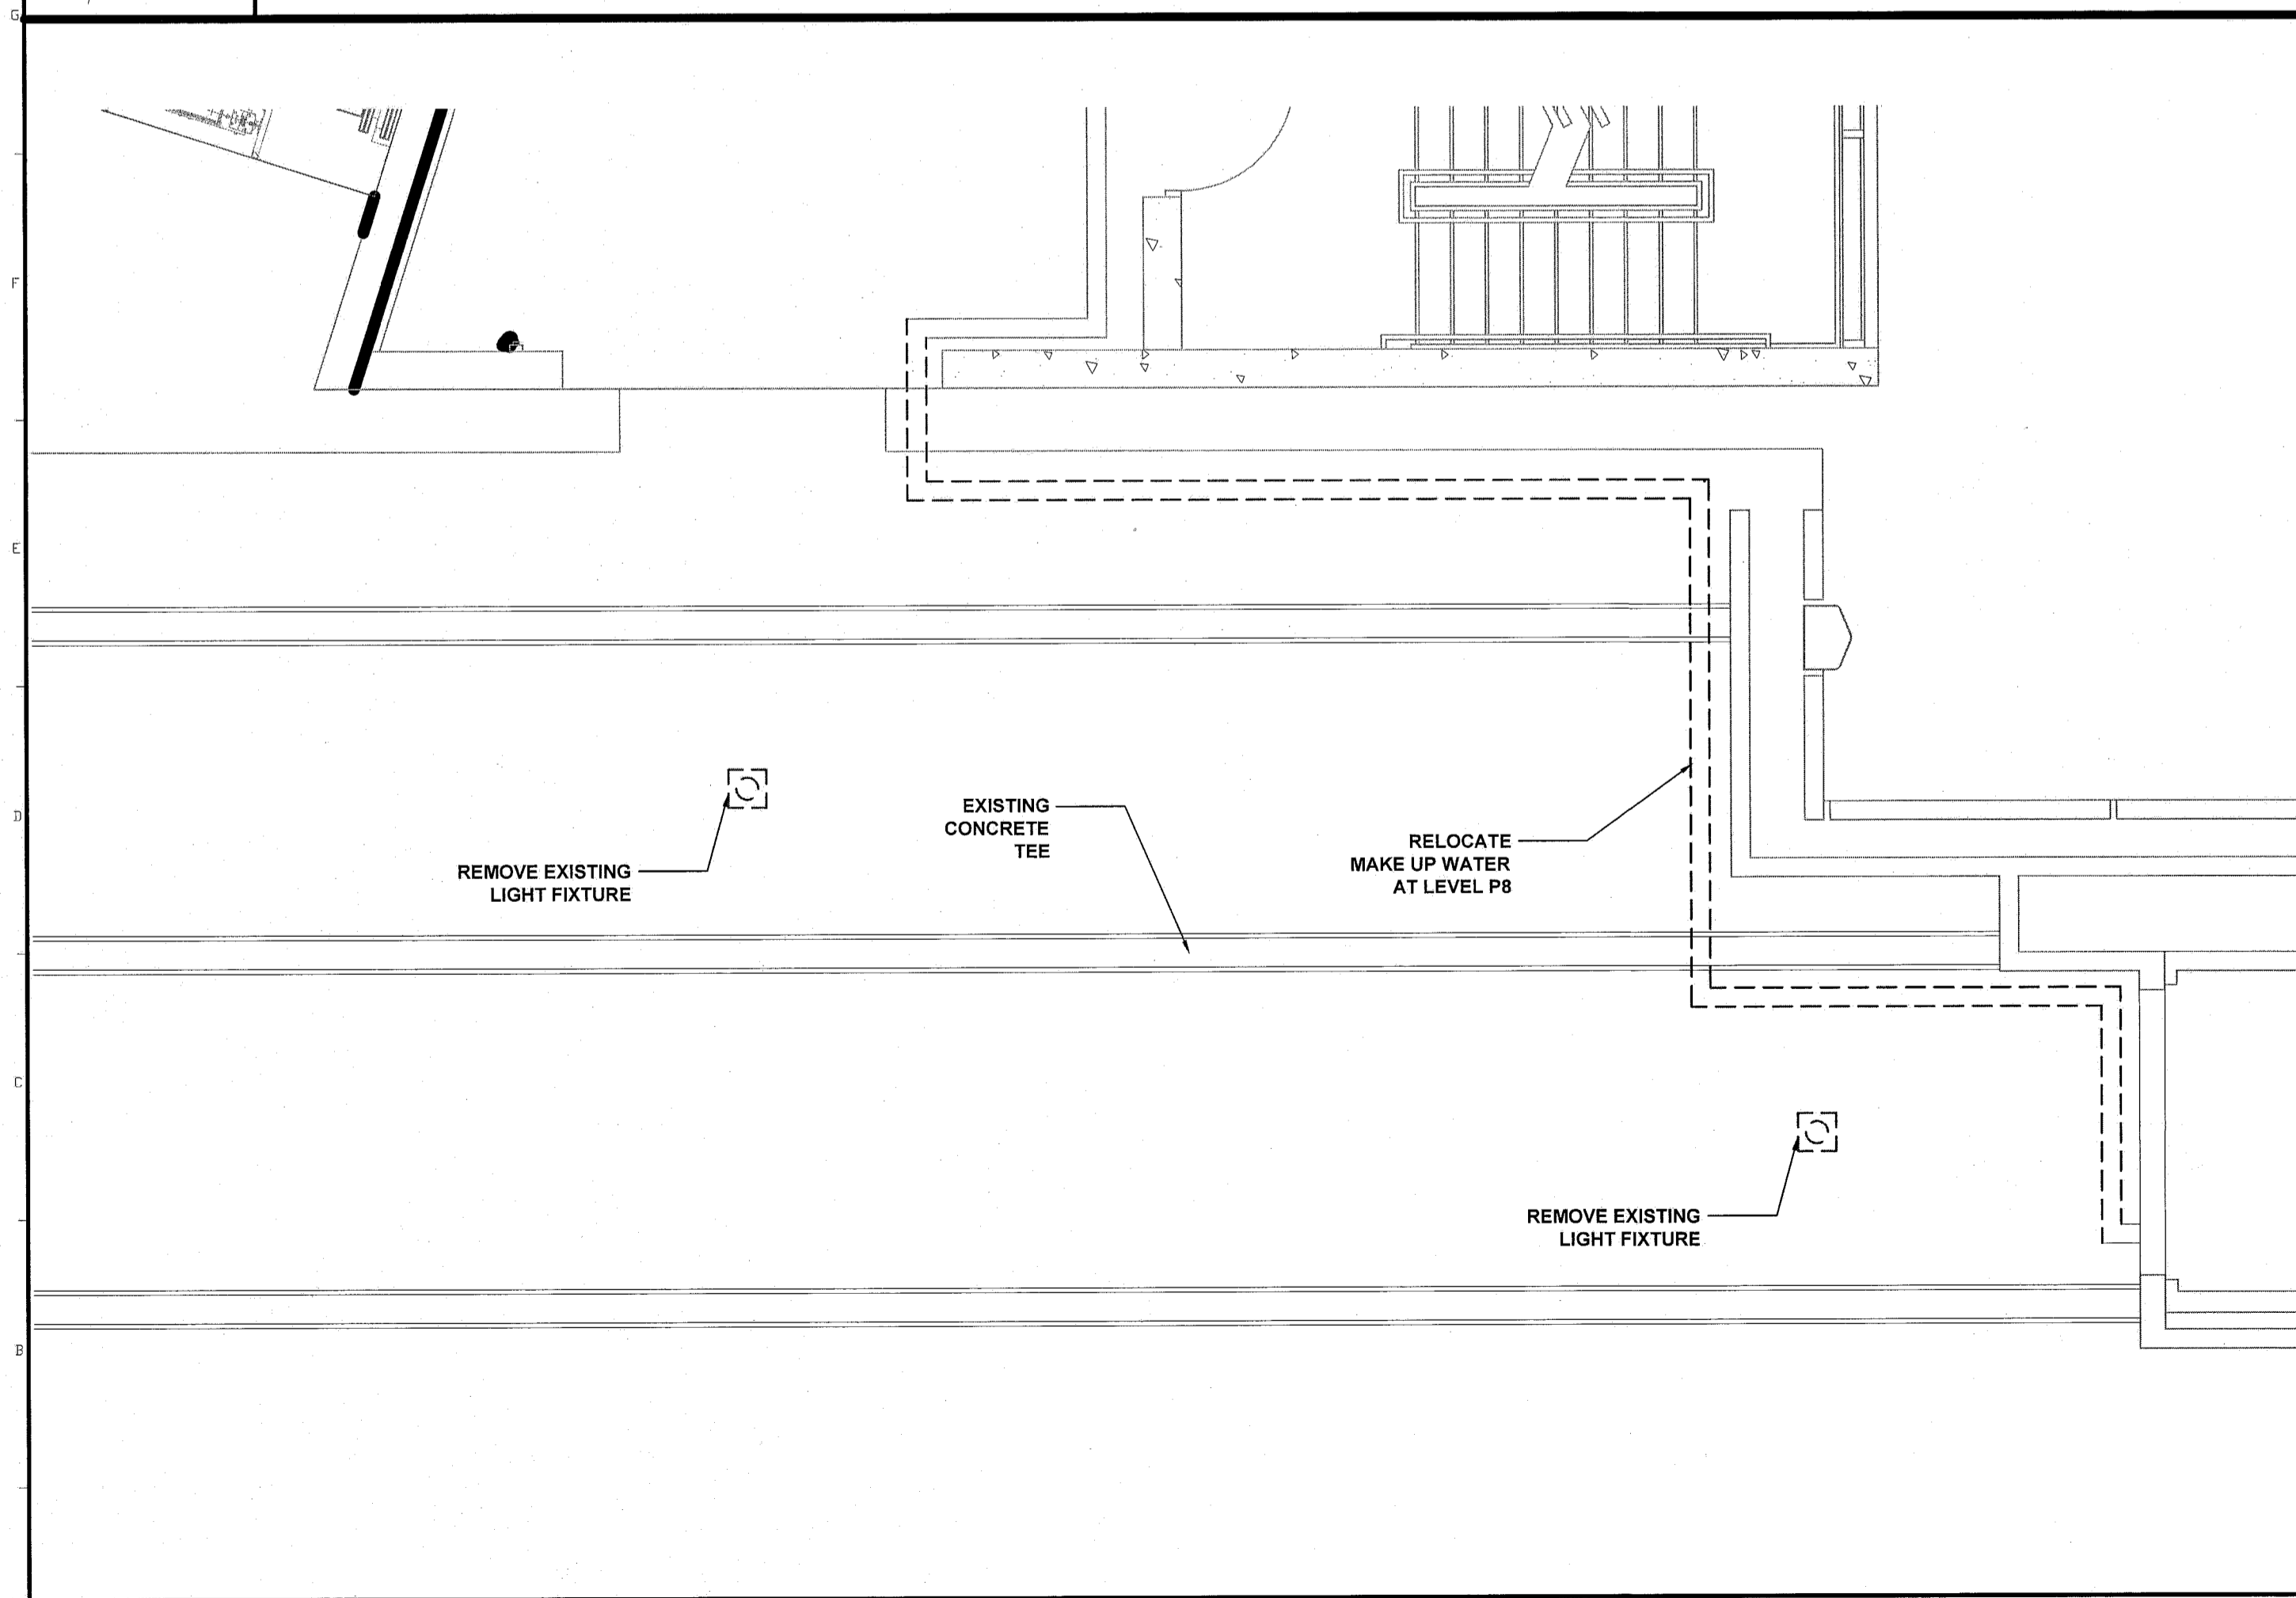


A1 REFLECTED CEILING REMOVALS PLAN LEVEL 8

E7 REFLECTED CEILING REMOVALS PLAN LEVEL P7

REV.	DESCRIPTION

ISSUED FOR CONSTRUCTION
08.03.2011

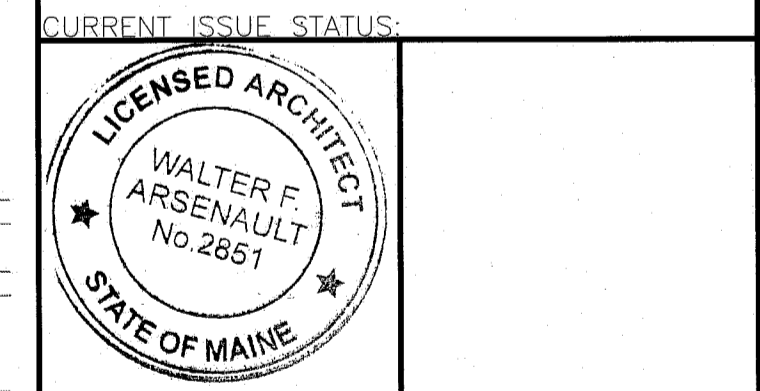

DESIGN GROUP COLLABORATIVE
ARCHITECTURE DESIGN + PLANNING
22 FREE STREET
PORTLAND, MAINE 04101
(207) 699-3300

MAINE MEDICAL CENTER
GILMAN STREET GARAGE
VESTIBULES
PORTLAND, MAINE

REFLECTED
CEILING PLANS,
REMOVALS PLANS

SHEET TITLE:	DATE:	08.03.2011	GRAPHIC SCALE:	0"
SCALE:	AS NOTED	PROJECT NO.:	112001	SHEET No.:
DRAWN BY:	WFA	A 104		
A/E OF RECORD:	CFC			