


MARK	ISSUE DATE	DESCRIPTION

Issue Log

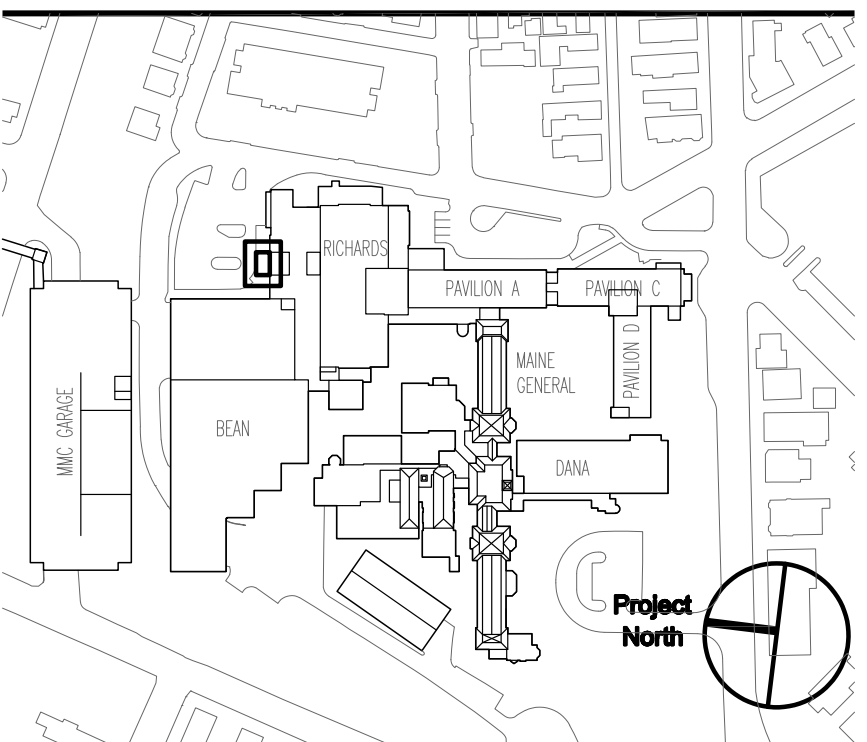


Key Plan

TRO
 ARCHITECTURE
 PLANNING
 ENGINEERING
 INTERIOR DESIGN
 The Ritchie Organization
 80 Bridge Street
 Newton, MA 02459-1154
 617-552-6400

Maine Medical Center
 ED Pediatric Exam Renovation
 Portland, Maine

Drawing Title
HVAC ROOF PLAN

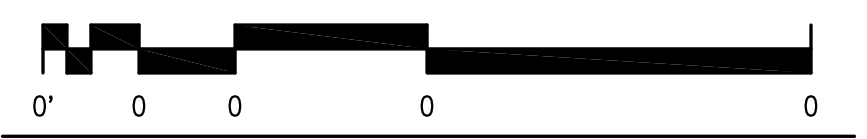

Commission No.	4684	Date Issued	JUNE 22, 2004
Scale	1/8" = 1'-0"	Sheet Number	
Drawn By	FWC		
Approved By	OW		
Filename	4684H200.DWG		

H201