




General Notes:
 1. ALL CEILING HEIGHTS SHALL BE 8'-0" UNLESS OTHERWISE NOTED
 2. ALL SOFFIT HEIGHTS SHALL BE 7'-2" UNLESS OTHERWISE NOTED
 3. ALL CEILING GRIDS ARE CENTERED IN ROOMS UNLESS NOTED OTHERWISE
 4. ABBREVIATION "FT." DEFINES THE USE OF A FULL TILE

REFLECTED CEILING LEGEND
 -SEE REFLECTED CEILING PLAN FOR CEILING HEIGHTS.

- | | | | |
|--|------------------------------------|--|--|
| | 2'x4' RECESSED FLUORESCENT LIGHT | | EXIT SIGN |
| | 2'x2' RECESSED FLUORESCENT LIGHT | | SPEAKER |
| | RECESSED PROCEDURE LIGHT FIXTURE | | NURSE CALL |
| | RECESSED 1'x4' FLUORESCENT LIGHT | | FIRE ALARM/HORN |
| | DOWN LIGHT | | SMOKE DETECTOR |
| | SURFACE MOUNTED STRIP LIGHT | | HEAT DETECTOR |
| | DOWN LIGHT (WALL WASHER) | | EMERGENCY LIGHTING |
| | PENDANT LIGHT FIXTURE | | SPRINKLER |
| | PENDANT LIGHT | | CEILING MOUNTED PROCEDURE/SURGICAL FIXTURE |
| | SURFACE MOUNTED FIXTURE | | WALL SCONCE |
| | WALL SCONCE | | WALL VALANCE |
| | TRACK LIGHTING | | SURFACE MOUNTED 2'x4' FLUORESCENT LIGHT |
| | COVE LIGHT FIXTURE | | SURFACE MOUNTED 2'x2' FLUORESCENT LIGHT |
| | PERIMETER SLOT LIGHT | | SURFACE MOUNTED 1'x4' FLUORESCENT LIGHT |
| | WALL SURFACE MOUNTED FIXTURE | | |
| | CEILING HEIGHT SYMBOL | | |
| | 2'x2' ACOUSTIC TILE | | 2'x4' ACOUSTIC TILE |
| | GYPSON WALLBOARD CEILING OR SOFFIT | | |
| | 2'x2' WOOD VENEER CEILING TILE | | |
| | METAL PANEL (MP-X) | | |
| | METAL PANEL (MP-X) | | |
| | PERFORATED ACOUSTIC METAL CEILING | | |
| | MECHANICAL SUPPLY DIFFUSER | | |
| | MECHANICAL RETURN REGISTER | | |
| | MECHANICAL EXHAUST | | |
| | RADIANT HEAT PANEL | | |
| | MECHANICAL LINEAR DIFFUSER/RETURN | | |
| | ACCESS PANEL | | |
| | CURTAIN TRACK | | |
| | N TRACK | | |

**FOR PERMIT ONLY
 NOT FOR CONSTRUCTION**

PERMIT 09/24/04 PERMIT SET - NOT FOR CONSTRUCTION
 Issue Log

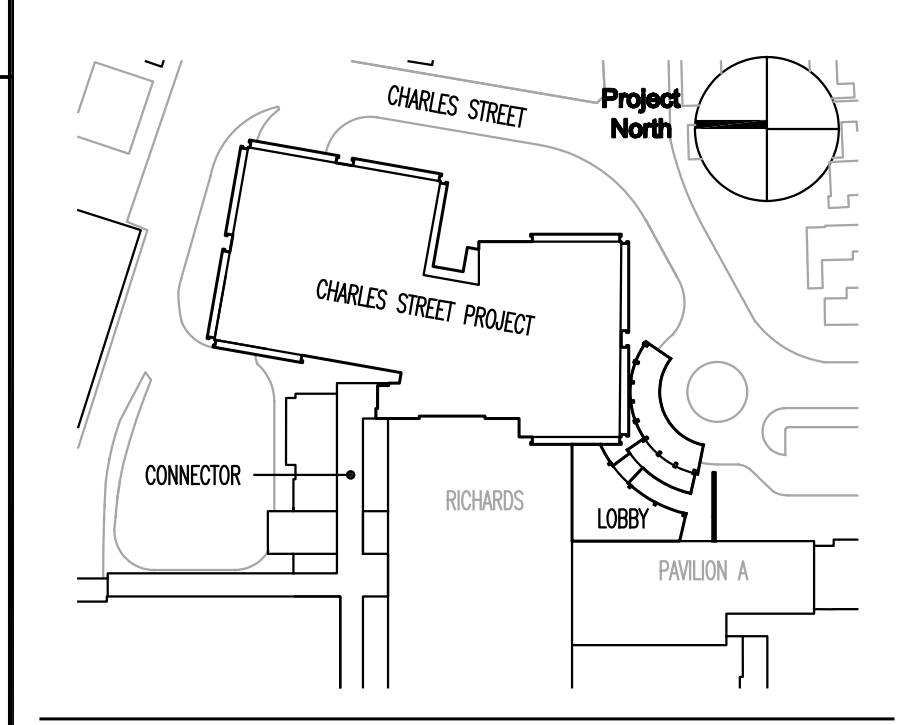


Key Plan

TRO
 ARCHITECTURE
 PLANNING
 ENGINEERING
 INTERIOR DESIGN
 The Ritchie Organization
 80 Bridge Street
 Newton, MA 02459-1196
 617-552-6000

Maine Medical Center
 Charles Street Project
 Portland, Maine MMC Project No. 21841

**ENLARGED SECOND FLOOR
 REFLECTED CEILING PLAN
 SECTOR 2**

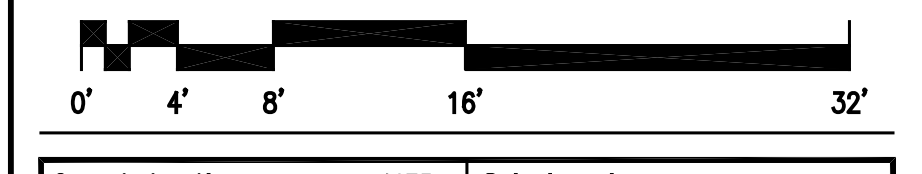

Commission No. 4673 Date Issued
 Scale 1/8" = 1'-0" Sheet Number
 Drawn By JLV
 Approved By TML
 Filename 4673A302.2.dwg
 Copyright © 2004 by TRO Inc.

ENLARGED REFLECTED CEILING PLAN
 SECOND FLOOR SECTOR 2
 SCALE: 1/4" = 1'-0"