


A  
B  
B.4  
C  
C.3  
C.6  
D  
E

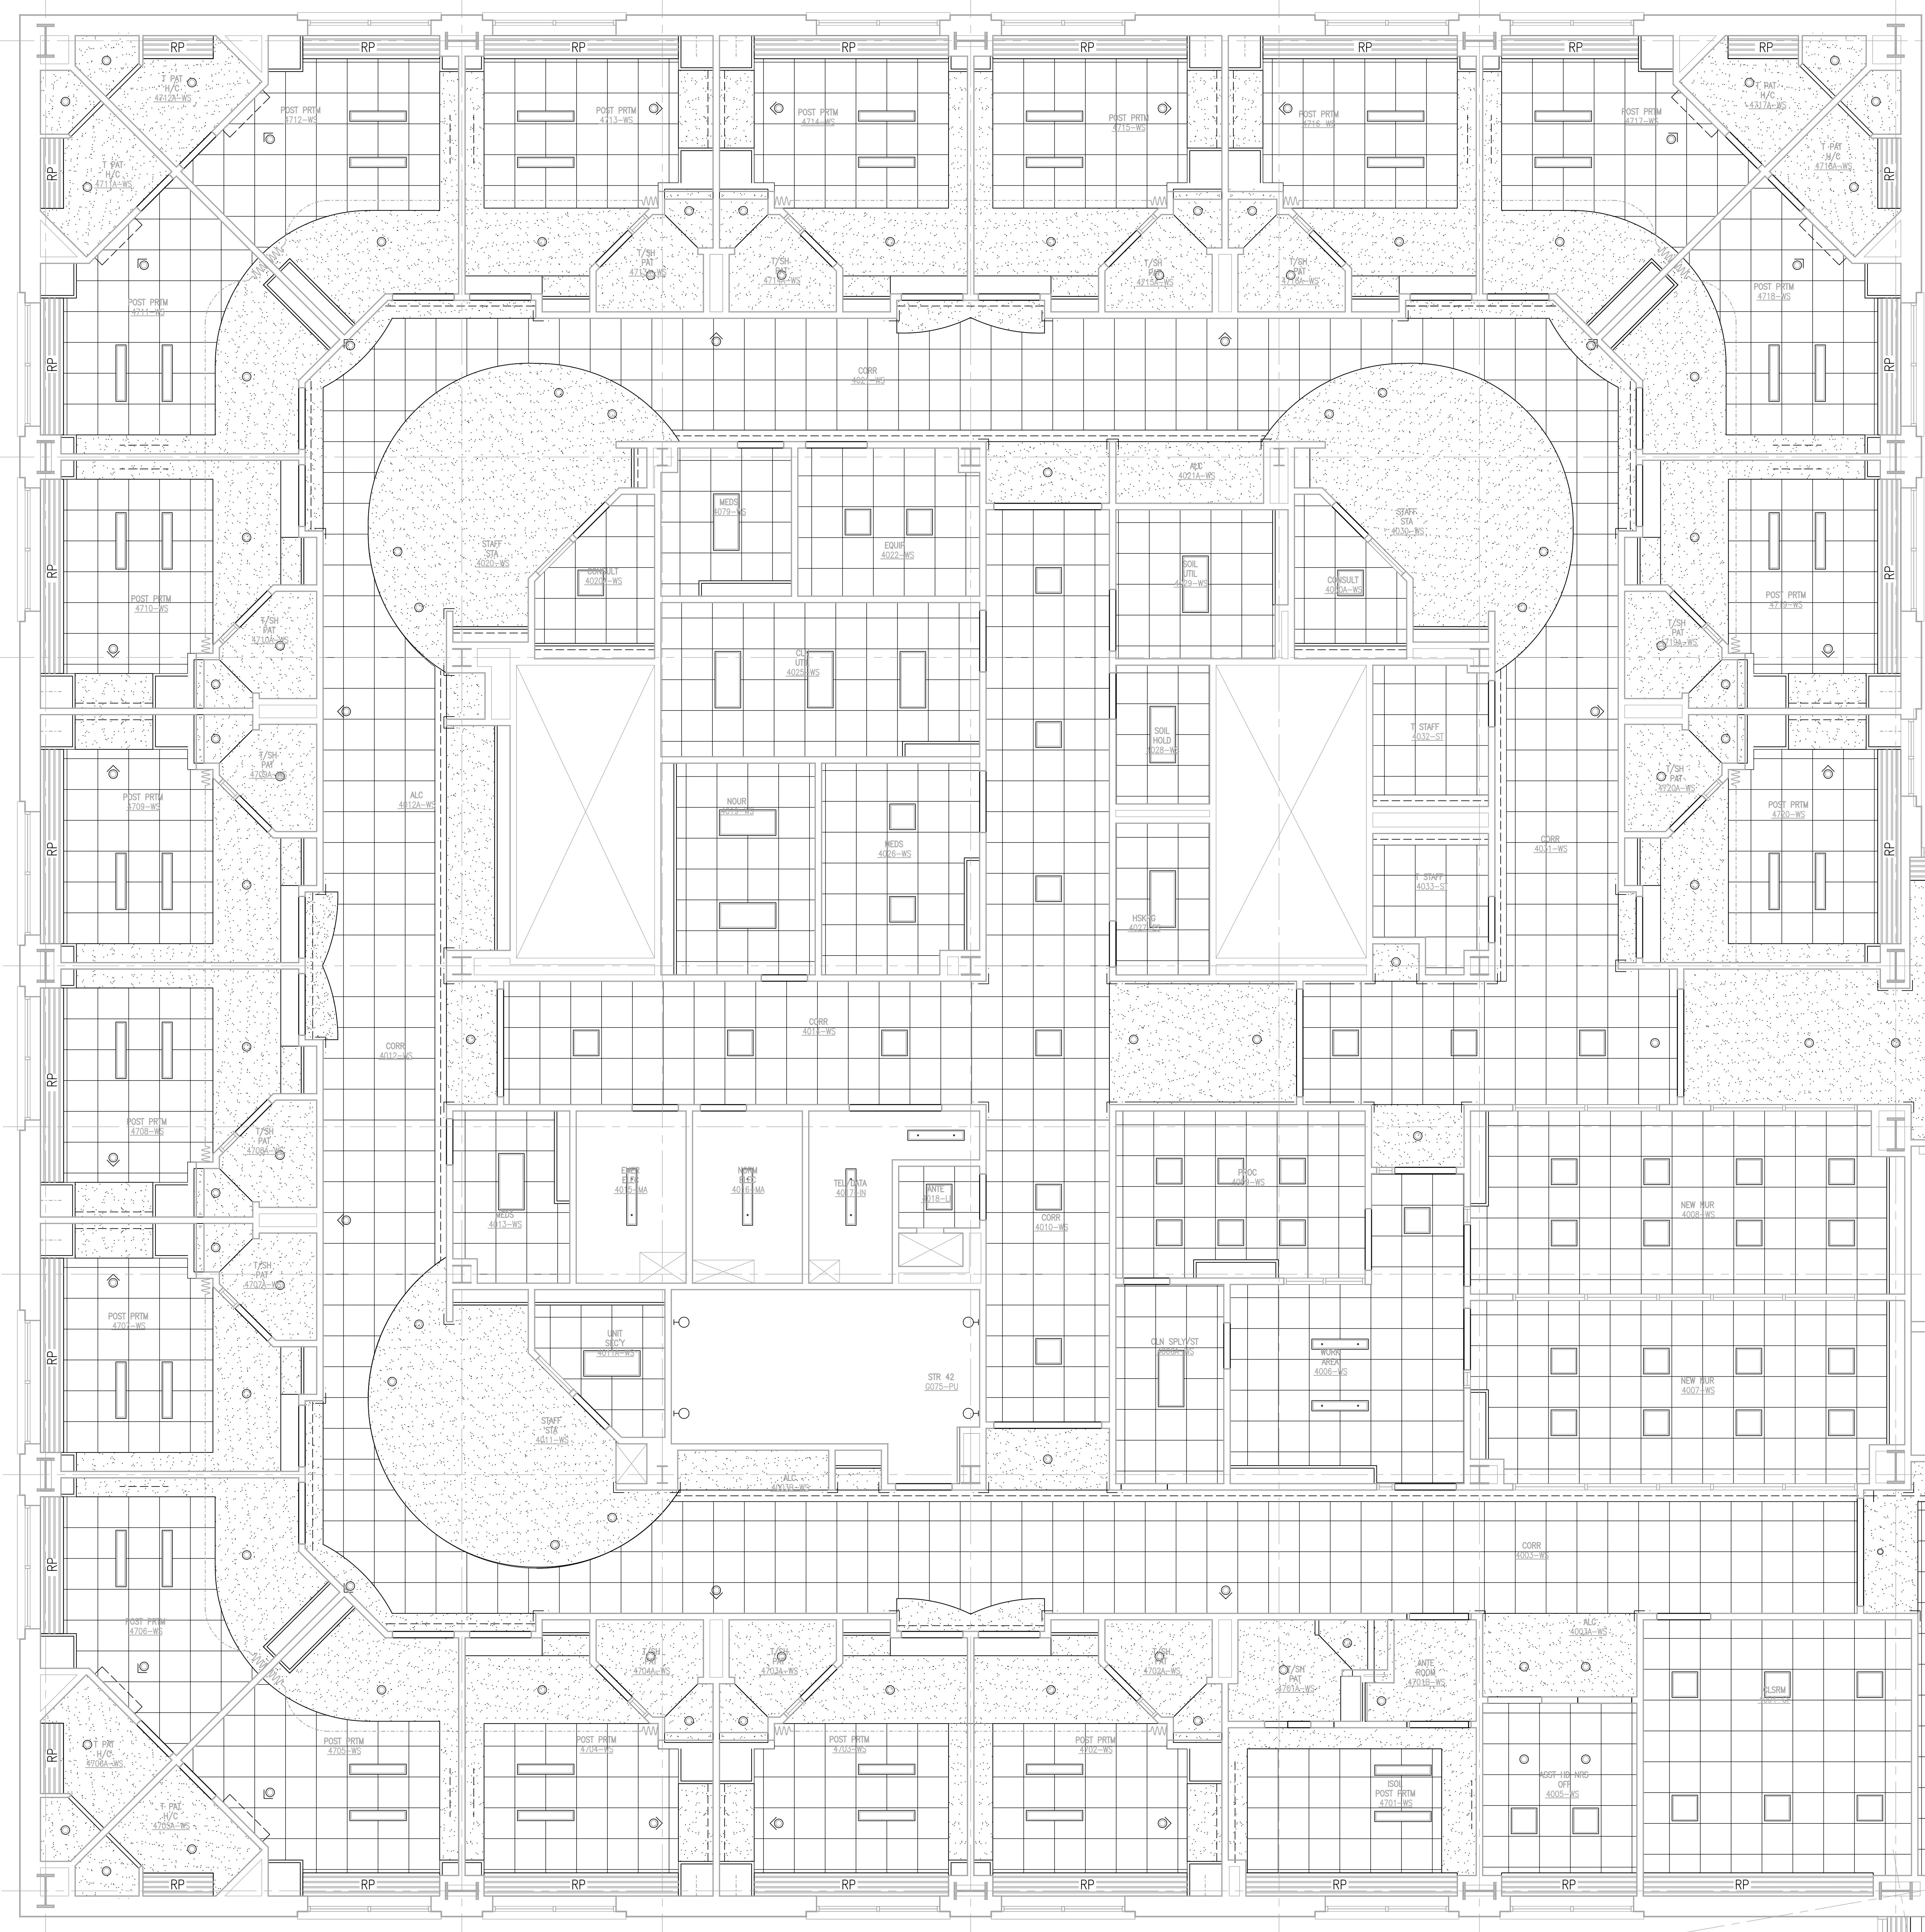


General Notes:  
 1. ALL CEILING HEIGHTS SHALL BE 8'-0" UNLESS OTHERWISE NOTED  
 2. ALL SOFFIT HEIGHTS SHALL BE 7'-2" UNLESS OTHERWISE NOTED  
 3. ALL CEILING GRIDS ARE CENTERED IN ROOMS UNLESS NOTED OTHERWISE  
 4. ABBREVIATION  $\perp$  FT. 1. DEFINES THE USE OF A FULL TILE

**REFLECTED CEILING LEGEND**  
 -SEE REFLECTED CEILING PLAN FOR CEILING HEIGHTS.

- RECESSED 2'x4' FLUORESCENT LIGHT
- RECESSED 2'x2' FLUORESCENT LIGHT
- RECESSED PROCEDURE LIGHT FIXTURE
- RECESSED 1'x4' FLUORESCENT LIGHT
- DOWN LIGHT
- SURFACE MOUNTED STRIP LIGHT
- DOWN LIGHT (WALL WASHER)
- PENDANT LIGHT FIXTURE
- SURFACE MOUNTED FIXTURE
- WALL SCONCE
- TRACK LIGHTING
- COVE LIGHT FIXTURE
- PERIMETER SLOT LIGHT
- WALL SURFACE MOUNTED FIXTURE
- CEILING HEIGHT SYMBOL
- 2'x2' ACOUSTIC TILE
- GYPSUM WALLBOARD CEILING OR SOFFIT
- 2'x2' WOOD VENEER CEILING TILE
- METAL PANEL (MP-X)
- PERFORATED ACOUSTIC METAL CEILING
- MECHANICAL SUPPLY DIFFUSER
- MECHANICAL RETURN REGISTER
- MECHANICAL EXHAUST
- RADIANT HEAT PANEL
- MECHANICAL LINEAR DIFFUSER/RETURN
- ACCESS PANEL
- CURTAIN TRACK
- N TRACK
- WALL VALANCE
- SURFACE MOUNTED 2'x4' FLUORESCENT LIGHT
- SURFACE MOUNTED 2'x2' FLUORESCENT LIGHT
- SURFACE MOUNTED 1'x4' FLUORESCENT LIGHT
- CEILING MOUNTED PROCEDURE/SURGICAL FIXTURE
- SPEAKER
- NURSE CALL
- FIRE ALARM/HORN
- SMOKE DETECTOR
- HEAT DETECTOR
- EMERGENCY LIGHTING
- SPRINKLER

**FOR PERMIT ONLY  
NOT FOR CONSTRUCTION**

MARK ISSUE DATE DESCRIPTION  
 PERMIT 09/24/04 PERMIT SET - NOT FOR CONSTRUCTION  
 Issue Log

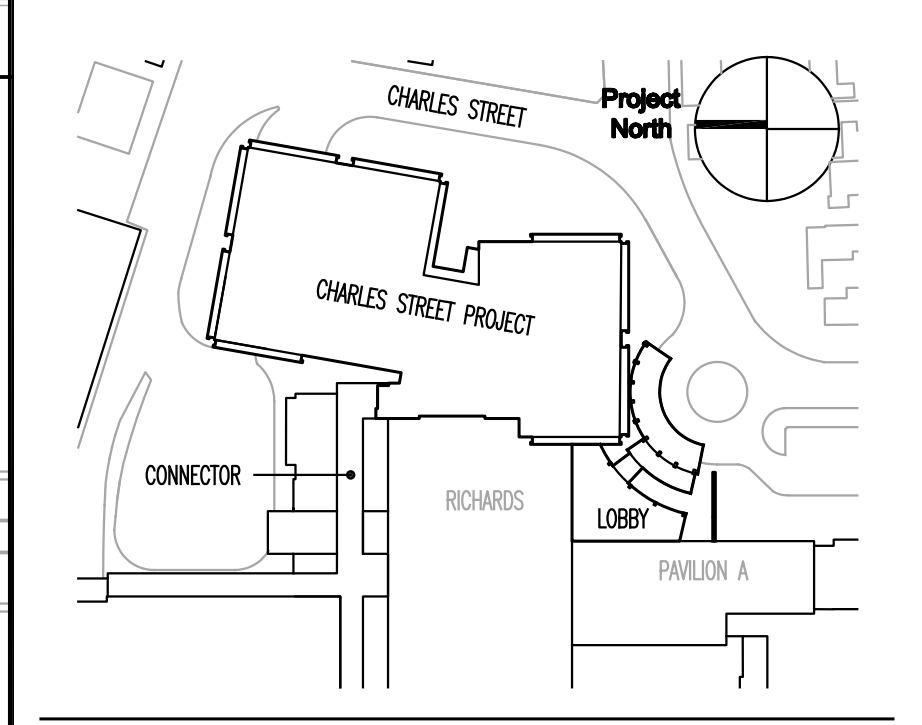

**TRO**  
 ARCHITECTURE  
 PLANNING  
 ENGINEERING  
 INTERIOR DESIGN

The Ritchie Organization  
 80 Bridge Street  
 Newton, MA 02459-1194  
 617-552-9100

**Maine Medical Center**  
 Charles Street Project  
 Portland, Maine MMC Project No. 21841

Drawing Title  
**ENLARGED FOURTH FLOOR  
 REFLECTED CEILING PLAN  
 SECTOR 1**

0' 2' 4' 8' 16'

Commission No. 4673 Date Issued  
 Scale 1/4" = 1'-0" Sheet Number  
 Drawn By JLV  
 Approved By TML  
 Filename 4673A304.1.dwg  
 Copyright © 2004 by TRO Architecture

**A304.1**

ENLARGED REFLECTED CEILING PLAN  
 FOURTH FLOOR SECTOR 1  
 SCALE: 1/4" = 1'-0"