


General Notes:
 1. ALL CEILING HEIGHTS SHALL BE 8'-0" UNLESS OTHERWISE NOTED
 2. ALL SOFFIT HEIGHTS SHALL BE 7'-2" UNLESS OTHERWISE NOTED
 3. ALL CEILING GRIDS ARE CENTERED IN ROOMS UNLESS NOTED OTHERWISE
 4. ABBREVIATION $\frac{1}{2}$ FT. $\frac{1}{2}$ DEFINES THE USE OF A FULL TILE

REFLECTED CEILING LEGEND
 -SEE REFLECTED CEILING PLAN FOR CEILING HEIGHTS.

- | | | | |
|--|------------------------------------|--|--|
| | RECESSED 2'x4' FLUORESCENT LIGHT | | EXIT SIGN |
| | RECESSED 2'x2' FLUORESCENT LIGHT | | SPEAKER |
| | RECESSED PROCEDURE LIGHT FIXTURE | | NURSE CALL |
| | RECESSED 1'x4' FLUORESCENT LIGHT | | FIRE ALARM/HORN |
| | DOWN LIGHT | | SMOKE DETECTOR |
| | SURFACE MOUNTED STRIP LIGHT | | HEAT DETECTOR |
| | DOWN LIGHT (WALL WASHER) | | EMERGENCY LIGHTING |
| | PENDANT LIGHT FIXTURE | | SPRINKLER |
| | PENDANT LIGHT | | CEILING MOUNTED PROCEDURE/SURGICAL FIXTURE |
| | SURFACE MOUNTED FIXTURE | | WALL VALANCE |
| | WALL SCONCE | | SURFACE MOUNTED 2'x4' FLUORESCENT LIGHT |
| | TRACK LIGHTING | | SURFACE MOUNTED 2'x2' FLUORESCENT LIGHT |
| | OVAL LIGHT FIXTURE | | SURFACE MOUNTED 1'x4' FLUORESCENT LIGHT |
| | PERIMETER SLOT LIGHT | | |
| | WALL SURFACE MOUNTED FIXTURE | | |
| | CEILING HEIGHT SYMBOL | | |
| | 2'x2' ACOUSTIC TILE | | 2'x4' ACOUSTIC TILE |
| | GYPSON WALLBOARD CEILING OR SOFFIT | | |
| | 2'x2' WOOD VENEER CEILING TILE | | |
| | METAL PANEL (MP-X) | | |
| | METAL PANEL (MP-Y) | | |
| | PERFORATED ACOUSTIC METAL CEILING | | |
| | MECHANICAL SUPPLY DIFFUSER | | |
| | MECHANICAL RETURN REGISTER | | |
| | MECHANICAL EXHAUST | | |
| | RADIANT HEAT PANEL | | |
| | MECHANICAL LINEAR DIFFUSER/RETURN | | |
| | ACCESS PANEL | | |
| | CURTAIN TRACK | | |
| | N TRACK | | |


MARK	ISSUE DATE	DESCRIPTION
FOR PERMIT ONLY NOT FOR CONSTRUCTION		
PERMIT	09/24/04	PERMIT SET - NOT FOR CONSTRUCTION
Issue Log		

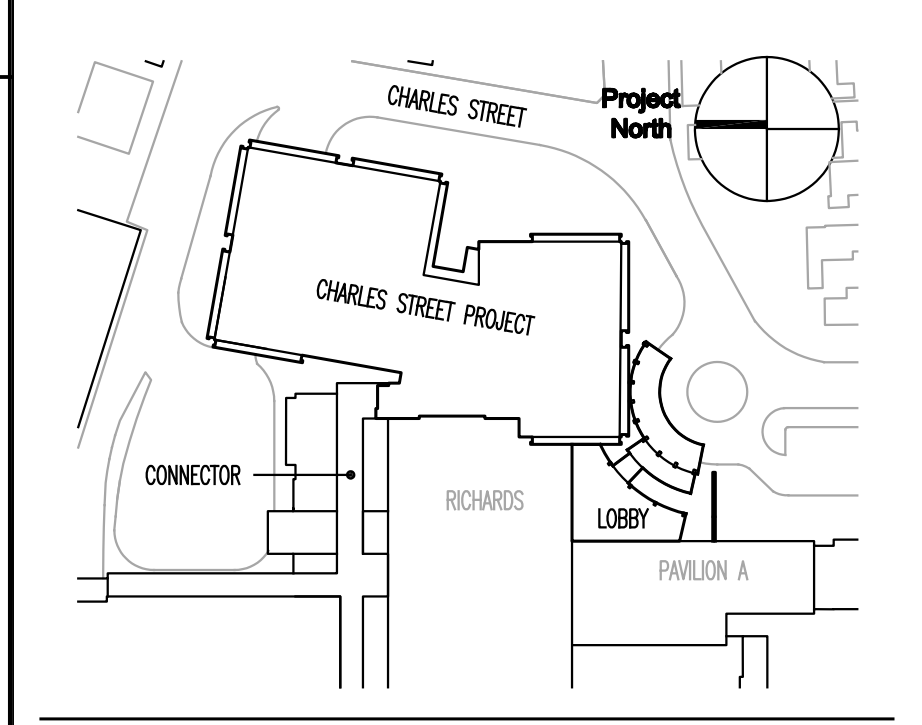

TRO
 ARCHITECTURE
 PLANNING
 ENGINEERING
 INTERIOR DESIGN
 The Ritchie Organization
 80 Bridge Street
 Newton, MA 02459-1194
 617-552-6900

Maine Medical Center
 Charles Street Project
 Portland, Maine MMC Project No. 21841

**ENLARGED BASEMENT
 REFLECTED CEILING PLAN
 SECTOR 2**

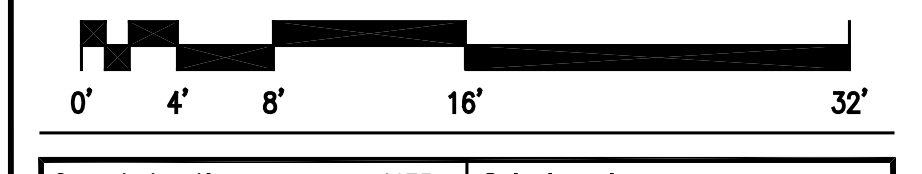

Commission No.	4673	Date Issued	
Scale	1/4" = 1'-0"	Sheet Number	
Drawn By	JW		
Approved By	TML		
Filename	4673A30B.2.dwg		
Copyright	© 2004	The Ritchie Organization	

A30B.2