


General Notes:
 1. ALL CEILING HEIGHTS SHALL BE 8'-0" UNLESS OTHERWISE NOTED
 2. ALL SOFFIT HEIGHTS SHALL BE 7'-2" UNLESS OTHERWISE NOTED
 3. ALL CEILING GRIDS ARE CENTERED IN ROOMS UNLESS NOTED OTHERWISE
 4. ABBREVIATION $\frac{1}{2}$ FT. $\frac{1}{2}$ DEFINES THE USE OF A FULL TILE

REFLECTED CEILING LEGEND

- SEE REFLECTED CEILING PLAN FOR CEILING HEIGHTS.
- RECESSED 2'x4' FLUORESCENT LIGHT
 - RECESSED 2'x2' FLUORESCENT LIGHT
 - RECESSED PROCEDURE LIGHT FIXTURE
 - RECESSED 1'x4' FLUORESCENT LIGHT
 - DOWN LIGHT
 - SURFACE MOUNTED STRIP LIGHT
 - DOWN LIGHT (WALL WASHER)
 - PENDANT LIGHT FIXTURE
 - PENDANT LIGHT
 - SURFACE MOUNTED FIXTURE
 - WALL SCONCE
 - TRACK LIGHTING
 - COVE LIGHT FIXTURE
 - PERIMETER SLOT LIGHT
 - WALL SURFACE MOUNTED FIXTURE
 - CEILING HEIGHT SYMBOL
 - 2'x2' ACOUSTIC TILE
 - GYPSON WALLBOARD CEILING OR SOFFIT
 - 2'x2' WOOD VENEER CEILING TILE
 - METAL PANEL (MP-X)
 - METAL PANEL (MP-Y)
 - PERFORATED ACOUSTIC METAL CEILING
 - MECHANICAL SUPPLY DIFFUSER
 - MECHANICAL RETURN REGISTER
 - MECHANICAL EXHAUST
 - RADIANT HEAT PANEL
 - MECHANICAL LINEAR DIFFUSER/RETURN
 - ACCESS PANEL
 - CURTAIN TRACK
 - N TRACK
 - EXIT SIGN
 - SPEAKER
 - NURSE CALL
 - FIRE ALARM/HORN
 - SMOKE DETECTOR
 - HEAT DETECTOR
 - EMERGENCY LIGHTING
 - SPRINKLER
 - CEILING MOUNTED PROCEDURE/SURGICAL FIXTURE
 - WALL VALANCE
 - SURFACE MOUNTED 2'x4' FLUORESCENT LIGHT
 - SURFACE MOUNTED 2'x2' FLUORESCENT LIGHT
 - SURFACE MOUNTED 1'x4' FLUORESCENT LIGHT

**FOR PERMIT ONLY
NOT FOR CONSTRUCTION**


MARK ISSUE DATE DESCRIPTION
 PERMIT 09/24/04 PERMIT SET - NOT FOR CONSTRUCTION
 Issue Log

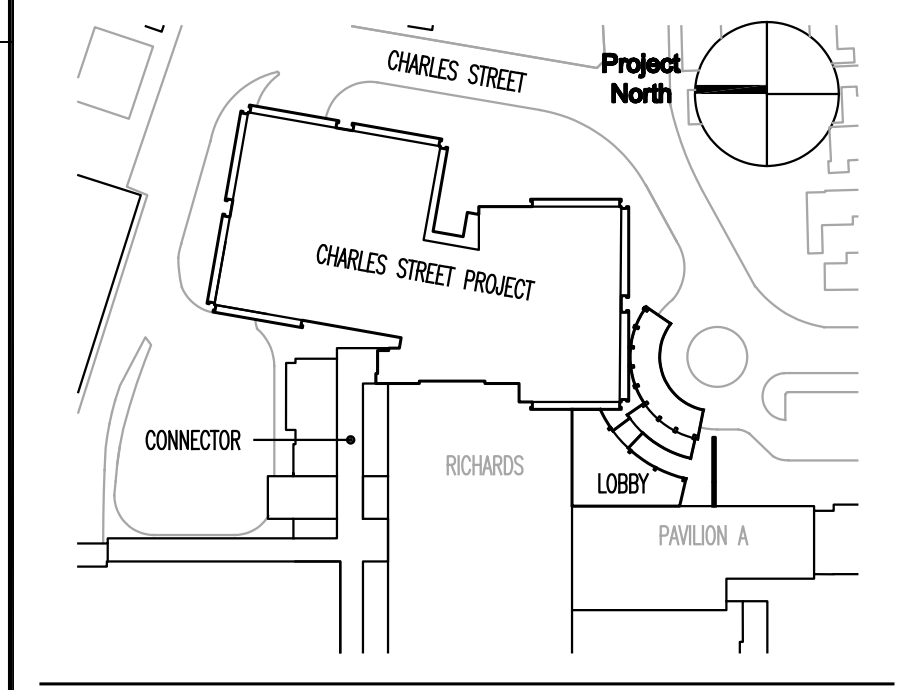

TRO
 ARCHITECTURE
 PLANNING
 ENGINEERING
 INTERIOR DESIGN
 The Ritchie Organization
 80 Bridge Street
 Newton, MA 02459-1194
 617-552-9100

Maine Medical Center
 Charles Street Project
 Portland, Maine MMC Project No. 21841

**BASEMENT
REFLECTED CEILING PLAN**

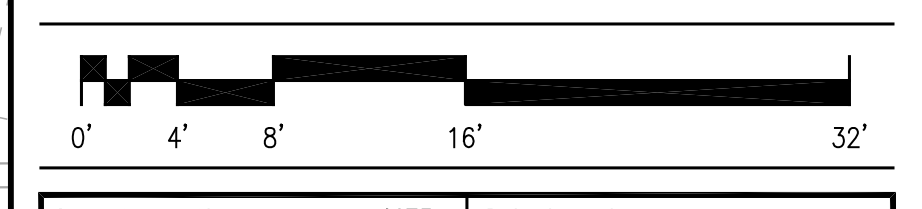

Commission No. 4673 Date Issued
 Scale 1/8" = 1'-0" Sheet Number
 Drawn By JVN
 Approved By BS
 Filename 4673A30B.dwg
 Copyright © 2004 The Ritchie Organization

A30B

