


General Notes:
 1. ALL CEILING HEIGHTS SHALL BE 8'-0" UNLESS OTHERWISE NOTED
 2. ALL SOFFIT HEIGHTS SHALL BE 7'-2" UNLESS OTHERWISE NOTED
 3. ALL CEILING GROSS ARE CENTERED IN ROOMS UNLESS NOTED OTHERWISE
 4. ABBREVIATION $\frac{1}{2}$ FT. $\frac{1}{2}$ DEFINES THE USE OF A FULL TILE

REFLECTED CEILING LEGEND
 -SEE REFLECTED CEILING PLAN FOR CEILING HEIGHTS.

- RECESSED 2'x4' FLUORESCENT LIGHT
- RECESSED 2'x2' FLUORESCENT LIGHT
- RECESSED PROCEDURE LIGHT FIXTURE
- RECESSED 1'x4' FLUORESCENT LIGHT
- DOWN LIGHT
- SURFACE MOUNTED STRIP LIGHT
- OR □ DOWN LIGHT (WALL WASHER)
- PENDANT LIGHT FIXTURE
- PENDANT LIGHT
- OR ○ SURFACE MOUNTED FIXTURE
- WALL SCONCE
- TRACK LIGHTING
- COVE LIGHT FIXTURE
- PERIMETER SLOT LIGHT
- WALL SURFACE MOUNTED FIXTURE
- ⊕ HEIGHT MARK
- 2'x2' ACOUSTIC TILE
- GYPSUM WALLBOARD CEILING OR SOFFIT
- 2'x2' WOOD VENEER CEILING TILE
- METAL PANEL (MP-X)
- METAL PANEL (MP-X)
- PERFORMED ACOUSTIC METAL CEILING
- MECHANICAL SUPPLY DIFFUSER
- MECHANICAL RETURN REGISTER
- MECHANICAL EXHAUST
- RADIANT HEAT PANEL
- MECHANICAL LINEAR DIFFUSER/RETURN
- ACCESS PANEL
- CURTAIN TRACK
- N TRACK
- CEILING MOUNTED PROCEDURE/SURGICAL FIXTURE
- WALL VALANCE
- SURFACE MOUNTED 2'x4' FLUORESCENT LIGHT
- SURFACE MOUNTED 2'x2' FLUORESCENT LIGHT
- SURFACE MOUNTED 1'x4' FLUORESCENT LIGHT
- 2'x4' ACOUSTIC TILE

MARK ISSUE DATE DESCRIPTION
FOR PERMIT ONLY
NOT FOR CONSTRUCTION
 PERMIT 09/24/04 PERMIT SET - NOT FOR CONSTRUCTION
 Issue Log

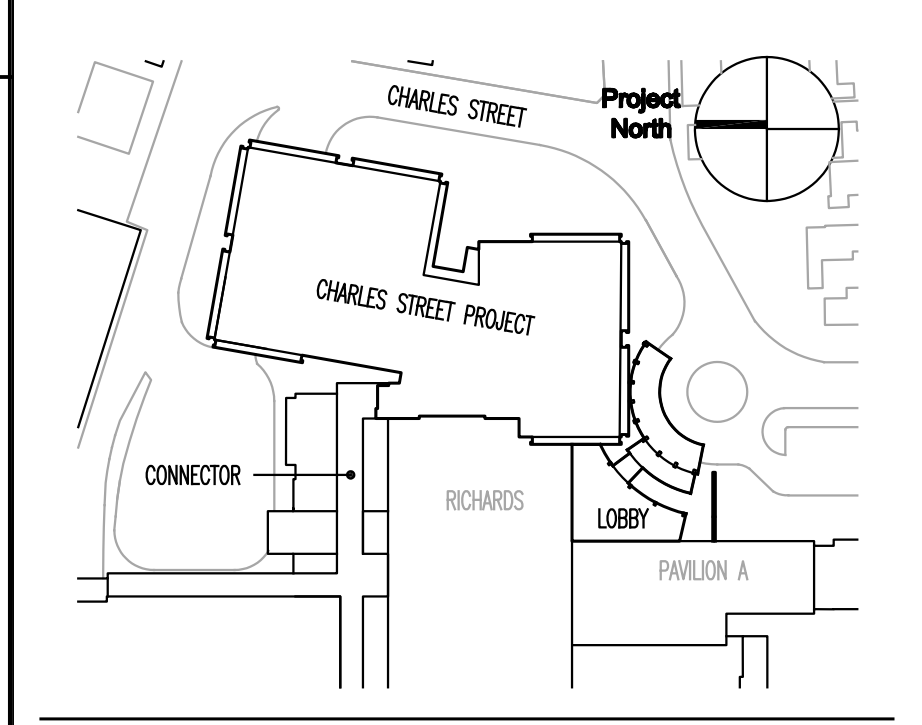

TRO
 ARCHITECTURE
 PLANNING
 ENGINEERING
 INTERIOR DESIGN
 The Ritchie Organization
 80 Bridge Street
 Newton, MA 02459-1194
 617-552-6900

Maine Medical Center
 Charles Street Project
 Portland, Maine MMC Project No. 21841

Drawing Title
ENLARGED SUB-BASEMENT REFLECTED CEILING PLAN L.L. BEAN BUILDING
 0' 2' 4' 8' 16'

Commission No. 4673 Date Issued
 Scale 1/8" = 1'-0" Sheet Number
 Drawn By JW
 Approved By BS
 Filename 4673A30B1.3.dwg
 Copyright © 2004 The Ritchie Organization
A30B1.3