


General Notes:

DRAWING NOTES:

1. REFER TO THE LIGHTING SPECIFICATIONS FOR "SPECIFICATIONS FOR THE INSTALLATION OF LIGHTING FIXTURES AND EQUIPMENT".

EQUIPMENT NOTES:


1. CONNECTION TO SHEET LIGHTING IS INDICATED BY A DIAMOND SYMBOL.

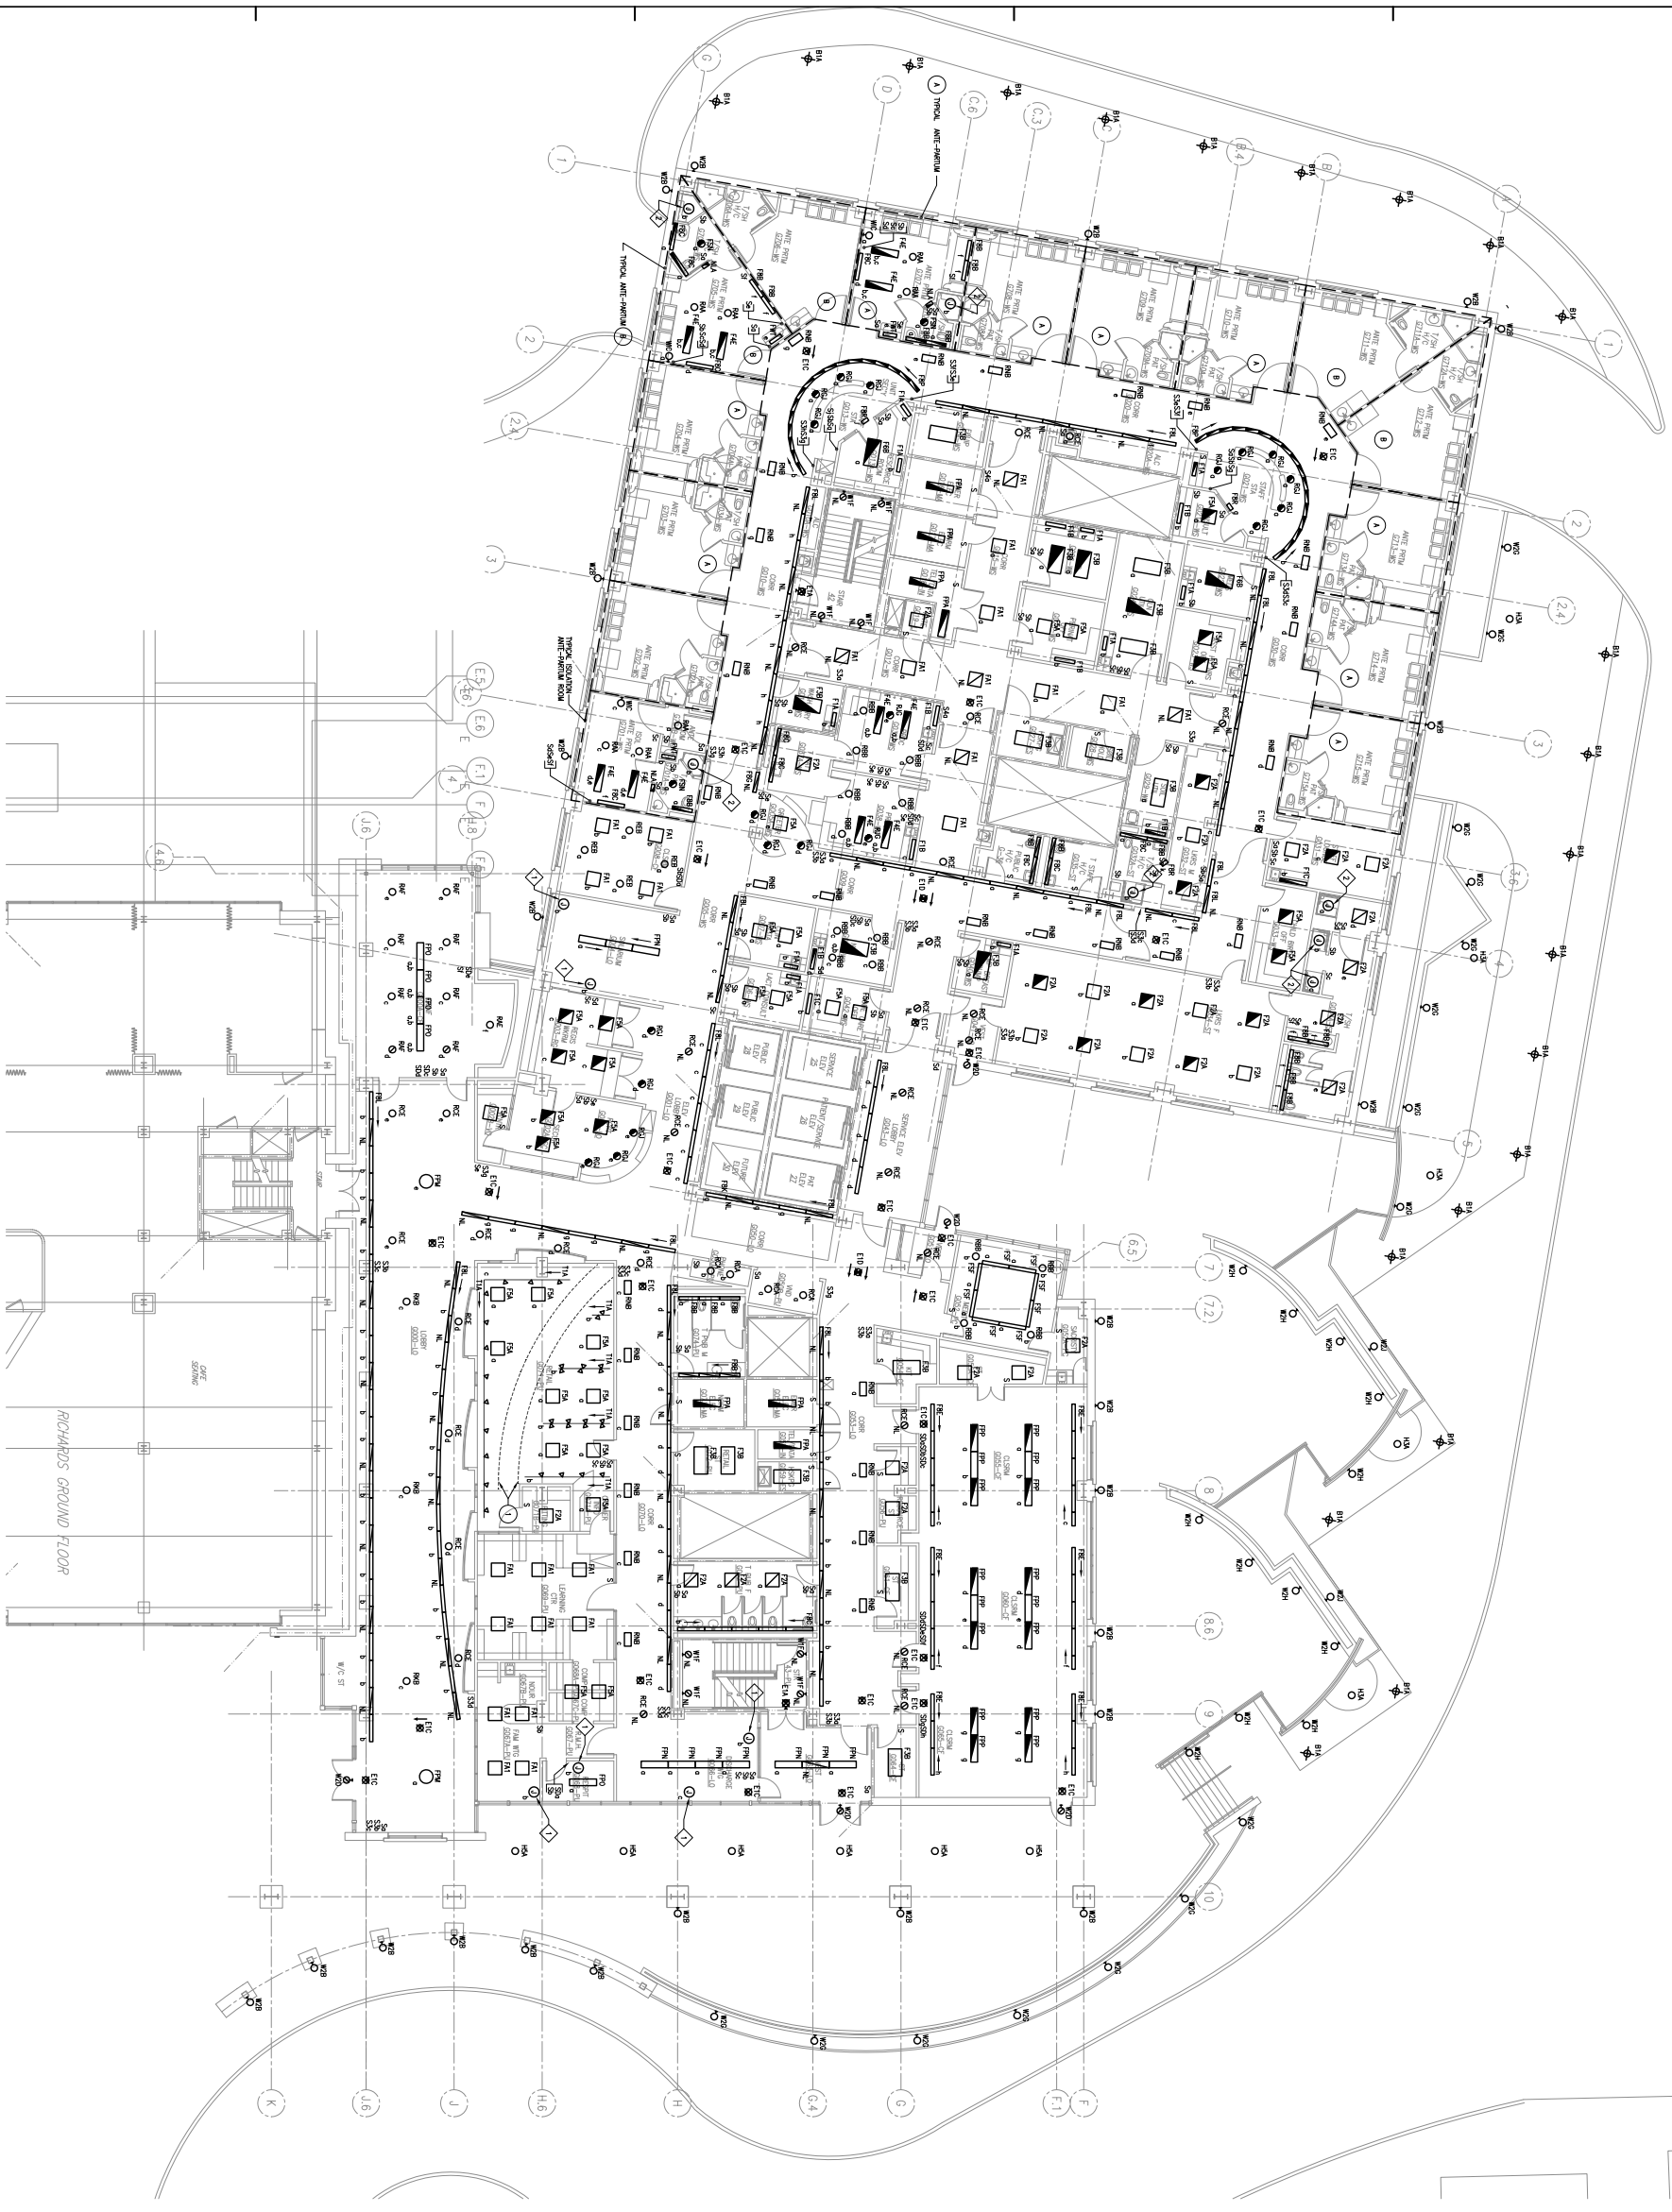

RICHARDS GROUND FLOOR

ISSUE ONE
FOR PERMIT ONLY
NOT FOR CONSTRUCTION

DATE: 09/24/24
PROJECT: CHARLES STREET - WEST WING CONSTRUCTION
SCALE: 1/8\"

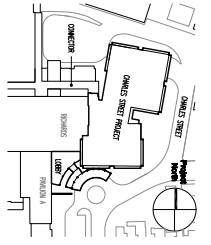

Maine Medical Center
Charles Street Project
Portland, Maine
MMC Project No. 21841

**ELECTRICAL
GROUND FLOOR
LIGHTING PLAN**

Commission No. 45122
Scale 1/8\"
Drawing No. E206
Revision 01
Date 09/24/24
Author J. Smith
Checker M. Smith