



General Notes:
 EQUIPMENT NOTES:
 ♦ EQUIPMENT CONNECTION TO REMAIN THE BUILDER'S RESPONSIBILITY

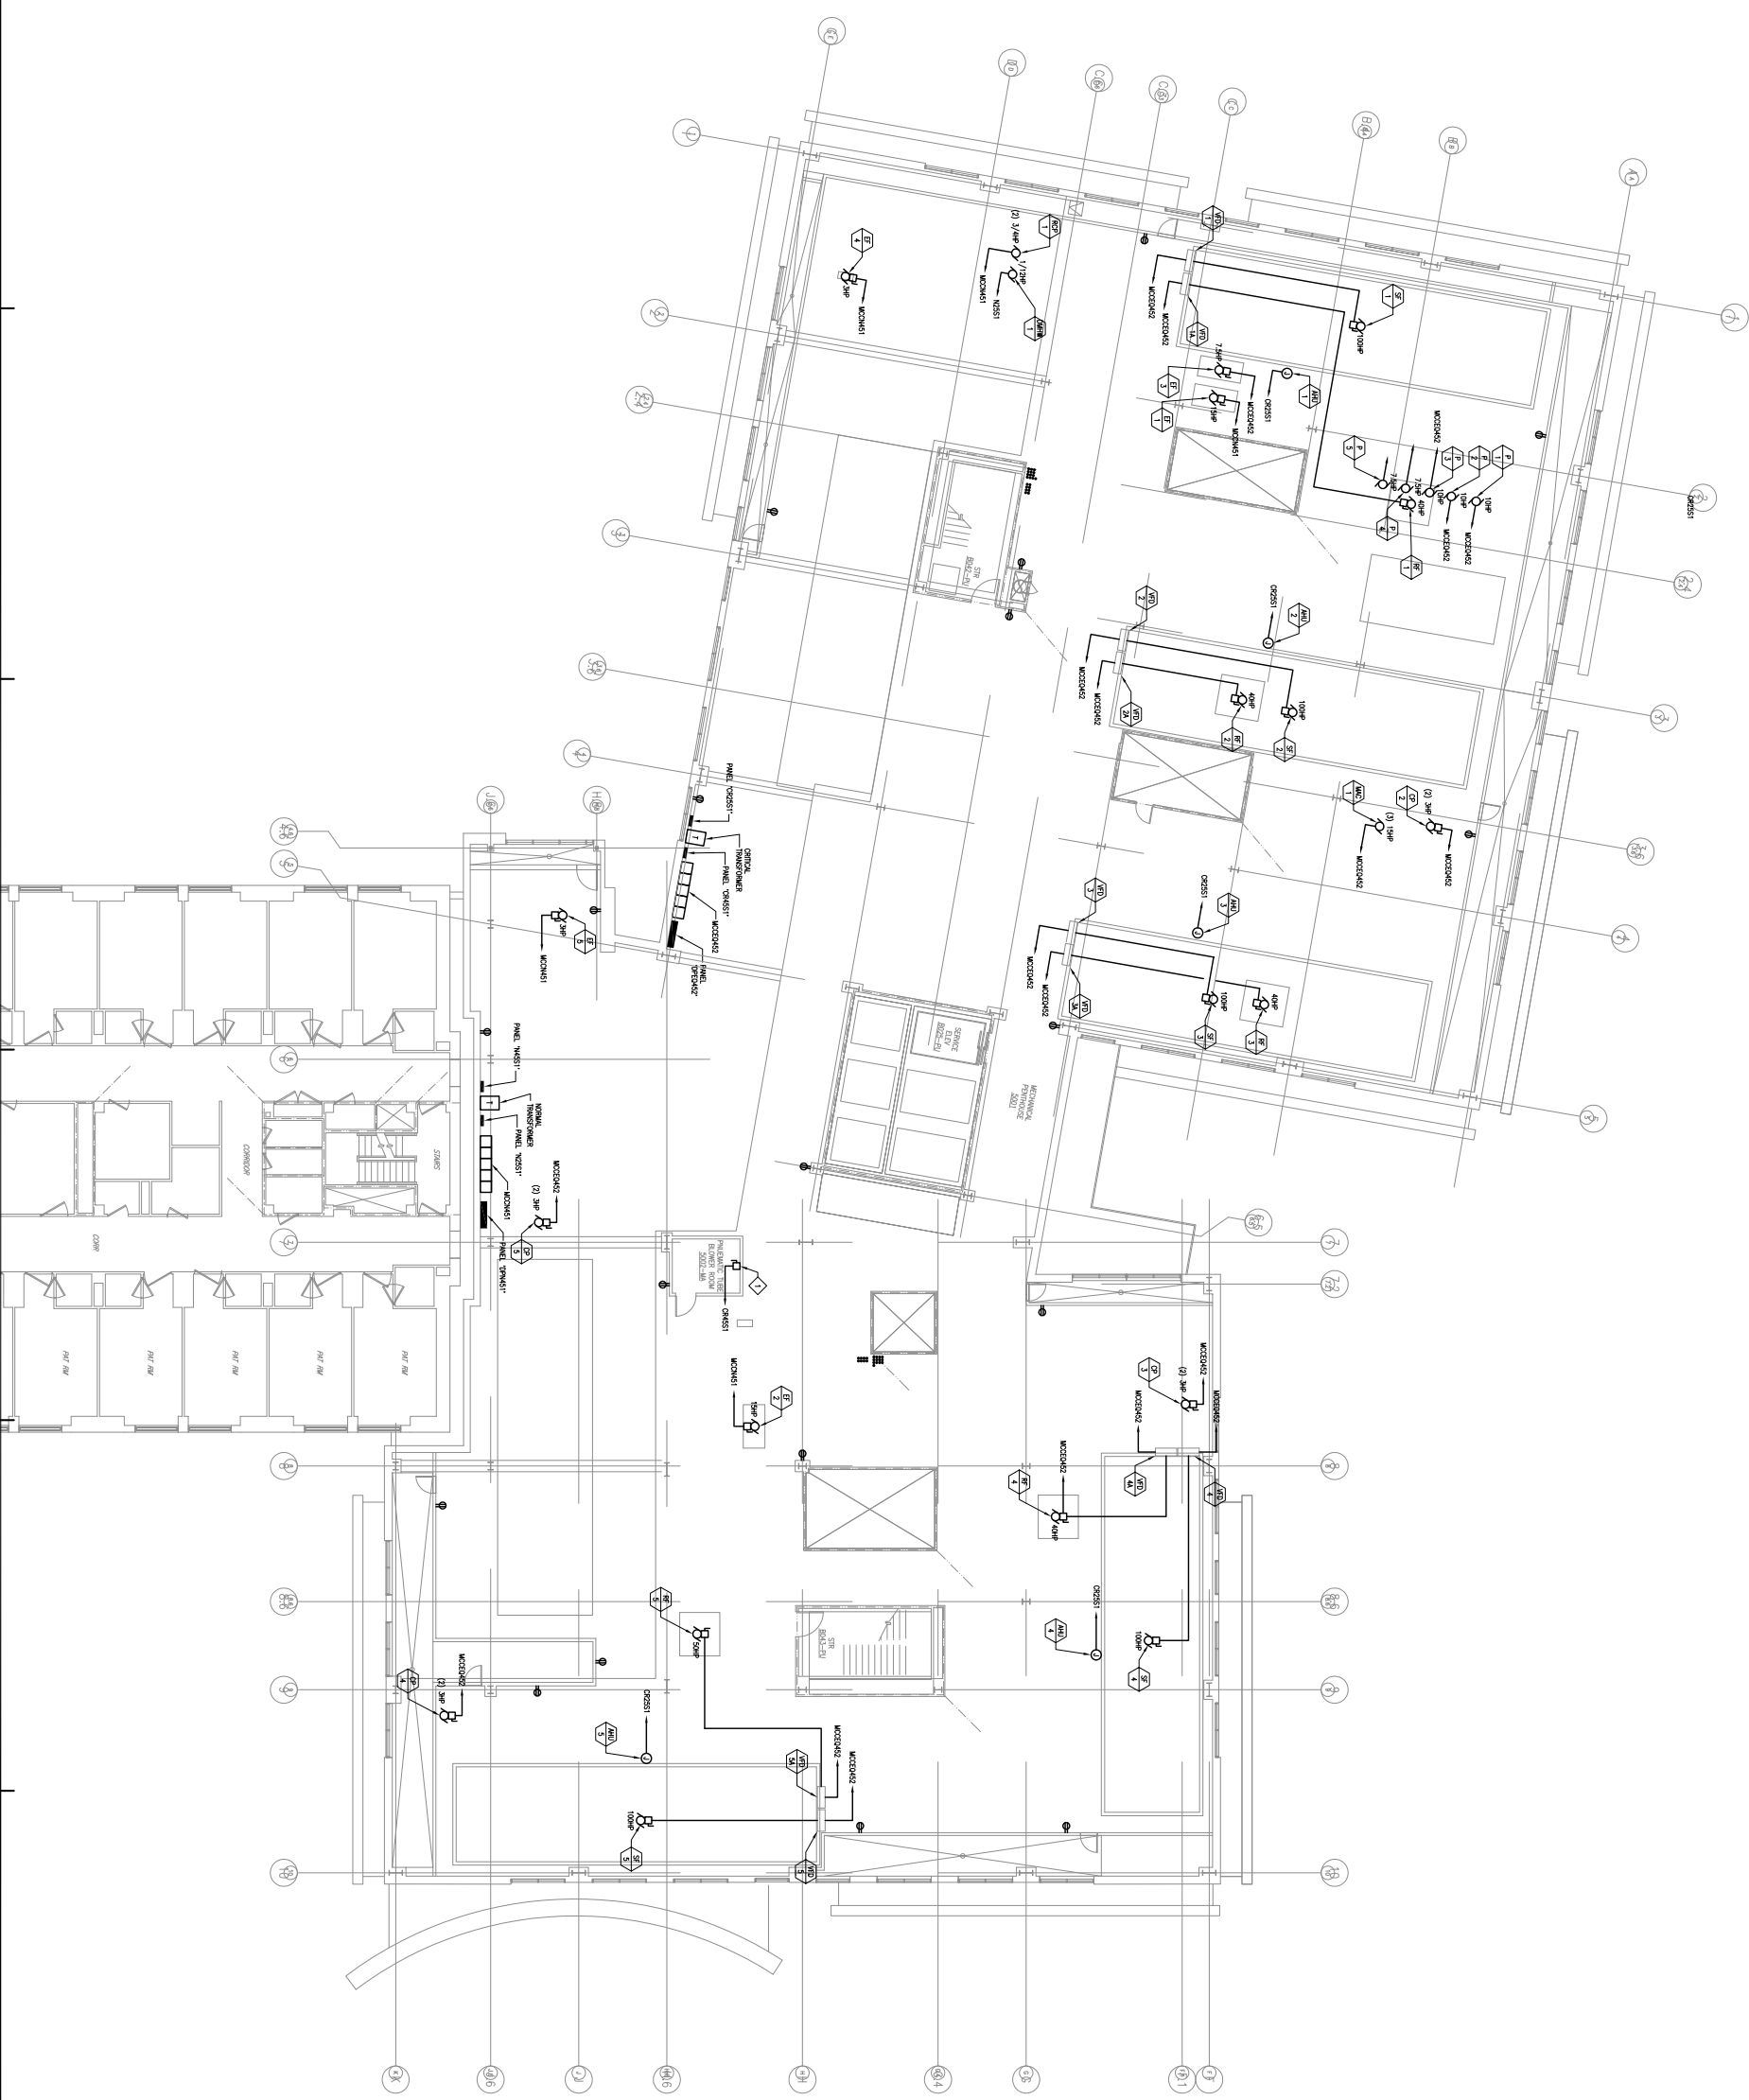

DATE: 09/24/14
 DRAWN BY: FERRIS ST - NET FOR CONSTRUCTION
 CHECKED BY: 09/24/14
 SCALE: 1/8" = 1'-0"
 PROJECT: 5TH FLOOR POWER PLAN

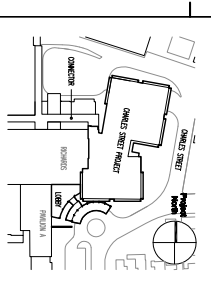

PRO
 A ARCHITECTURE
 PLANNING
 ENGINEERING
 INTERIORS
 DESIGN
 CONSTRUCTION
 MANAGEMENT
 800-541-4444
 1000 BROADWAY
 SUITE 1000
 PORTLAND, ME 04101

Maine Medical Center
 Charles Street Project
 Portland, Maine
 MMC Project No. 21841

**ELECTRICAL
 5TH FLOOR
 POWER PLAN**

Commission No. 48123
 Scale: 1/8" = 1'-0"
 Date: 09/24/14
 Project: 5TH FLOOR POWER PLAN
 E305